

PHASING NOTES:
REFER TO PHASING ON SHEETS
GC119 THRU GC125 FOR PHASED
AREAS OF WORK.

GENERAL NOTES

1. REFER TO SHEET FX001 FOR LEGEND, ABBREVIATIONS, SCHEDULES AND GENERAL NOTES.
2. VERIFY EXISTING FIRE SPRINKLER RISERS AND STAND-UP PIPE IN STAIR WELL.
3. ALL FIRE SPRINKLER PIPING SHALL BE REMOVED. THIS SHALL INCLUDE ALL SPRINKLERS, BRANCH PIPING AND MAIN PIPE FROM VERTICAL RISER AND/OR STAND PIPE FEEDING THE FLOOR PLATE. EXISTING STAND PIPE, VERTICAL FIRE MAIN, ALL AUXILIARY EQUIPMENT ATTACHED TO STAND PIPE, FLOW SWITCHES AND TAMPER SWITCHES SHALL REMAIN UNDISTURBED.
4. ANY SPRINKLER MAINS SERVING SPACES IN OTHER PHASES AND/OR OUTSIDE OF THE PROJECT SCOPE SHALL REMAIN.
5. PRIOR TO THE START OF THE DEMOLITION, CONTRACTOR SHALL COORDINATE WITH THE COR TO ENSURE THERE IS NO DISRUPTION OF SERVICE DURING ANY PHASE OF CONSTRUCTION.

SHEET KEYNOTES

1. REMOVE EXISTING FIRE MAIN SERVING PHASE AREA.
2. LAY-IN CEILING REMOVAL SHALL BE RESTRICTED TO THIS AREA ONLY. REMOVE ESCUTCHEON PLATE AND LEAVE SPRINKLER IN PLACE.
3. SPRINKLER AND PIPING WITHIN MECHANICAL AREA SHALL BE REVISED TO ACCOMMODATE REVISED MECHANICAL EQUIPMENT ORIENTATION.

PARTITION GRAPHICS


PARTITION PHASING

- Solid line: EXISTING ELEMENT TO REMAIN
- Dashed line: EXISTING ELEMENT TO BE DEMOLISHED
- Diagonal hatching: TEMPORARY 1-HOUR RATED ELEMENT TO BE CONSTRUCTED AND DEMOLISHED IN SAME PHASE

PARTITION RATING

- No hatching: NO RATING
- Vertical hatching: SMOKE RESISTIVE PARTITION - NON RATED
- Horizontal hatching: 1 HOUR FIRE BARRIER
- Diagonal hatching (top-left to bottom-right): 1 HOUR FIRE/SMOKE BARRIER
- Horizontal hatching (dashed): 2 HOUR FIRE BARRIER
- Diagonal hatching (bottom-left to top-right): 2 HOUR FIRE/ SMOKE BARRIER

KEY PLAN

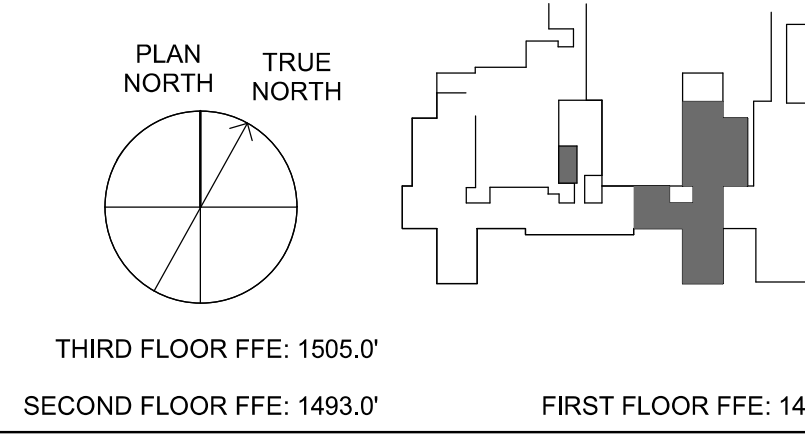

D1 PARTIAL 2 SECOND FLOOR DEMOLITION FIRE PROTECTION PLAN - PHASE 1A
1/4" = 1'-0"

D2 PARTIAL 2B SECOND FLOOR DEMOLITION FIRE PROTECTION PLAN - PHASE 1
1/8" = 1'-0"

Revisions:		
No.	Description	Date

CONSULTANTS:

BRITT, PETERS AND ASSOCIATES, INC.
consulting engineers
8701 RED OAK BLVD, SUITE 500
CHARLOTTE, NC 28217
PHONE: 704.522.0405
WWW.BRITTPETERS.COM

Seal: Digital Signature not valid without Certificate below seal.
WILLIAM G. GRANT, P.E.
Professional Engineer
No. 054948
Exp. 12/31/24
By William G. Grant
Date: 2023.03.24
Scale: 1/8"=1'-0"

ARCHITECT / ENGINEERS:

HARRELL DESIGN GROUP, P.C.
formerly HARRELL, SALTRICK & HOPPER, PC
8016 TOWER POINT DRIVE
CHARLOTTE, NC 28227
P 704.814.1320
F 704.321.0833
HDP PROJECT: 18002
COPYRIGHT © 2021

Drawing Title:
PARTIAL 2B SECOND FLOOR DEMOLITION FIRE PROTECTION PLAN - PHASE 1

Project Phase:
BID DOCUMENTS
FULLY SPRINKLERED

Project Title:
RENOVATE MED SURGE WARDS

Location:
VETERANS HEALTHCARE SYSTEM OF THE OZARKS
Date:
MARCH 24, 2024
Checked:
WGG
Drawn:
DM

Project Number:
564-17-140
Building Number:
1
Drawing Number:
FD101
Sheet **91** of **162**

Engineering Service
VETERANS HEALTH CARE SYSTEM OF THE OZARKS
VA U.S. Department of Veterans Affairs