

PHASING NOTES:
REFER TO PHASING ON SHEETS GC119 THRU GC125 FOR PHASED AREAS OF WORK.

SEE DEDUCT ALTERNATE 5 ON SHEET G1001 FOR ALTERNATE WORK PHASE 2. REFER GC123a AND GC123b FOR MORE INFORMATION.

- GENERAL NOTES**
- REFER TO SHEET F1001 FOR LEGEND, ABBREVIATIONS, SCHEDULES AND GENERAL NOTES.
 - VERIFY EXISTING FIRE SPRINKLER RISERS AND STAND-UP PIPE IN STAIR WELL.
 - ALL FIRE SPRINKLER PIPING SHALL BE REMOVED. THIS SHALL INCLUDE ALL SPRINKLERS, BRANCH PIPING AND MAIN PIPE FROM VERTICAL RISER AND/OR STAND PIPE FEEDING THE FLOOR PLATE. EXISTING STAND PIPE, VERTICAL FIRE MAIN, ALL AUXILIARY EQUIPMENT ATTACHED TO STAND PIPE, FLOW SWITCHES AND TAMPER SWITCHES SHALL REMAIN UNDISTURBED.
 - ANY SPRINKLER MAINS SERVING SPACES IN OTHER PHASES AND/OR OUTSIDE OF THE PROJECT SCOPE SHALL REMAIN.
 - PRIOR TO THE START OF THE DEMOLITION, CONTRACTOR SHALL COORDINATE WITH THE COR TO ENSURE THERE IS NO DISRUPTION OF SERVICE DURING ANY PHASE OF CONSTRUCTION.

SHEET KEYNOTES

- REMOVE EXISTING FIRE MAIN SERVING PHASE AREA.

PARTITION GRAPHICS

PARTITION PHASING

EXISTING ELEMENT TO REMAIN

EXISTING ELEMENT TO BE DEMOLISHED

TEMPORARY 1-HOUR RATED ELEMENT TO BE CONSTRUCTED AND DEMOLISHED IN SAME PHASE

PARTITION RATING

NO RATING

SMOKE RESISTIVE PARTITION - NON RATED


1 HOUR FIRE BARRIER

1 HOUR FIRE/SMOKE BARRIER

2 HOUR FIRE BARRIER


2 HOUR FIRE/ SMOKE BARRIER

KEY PLAN

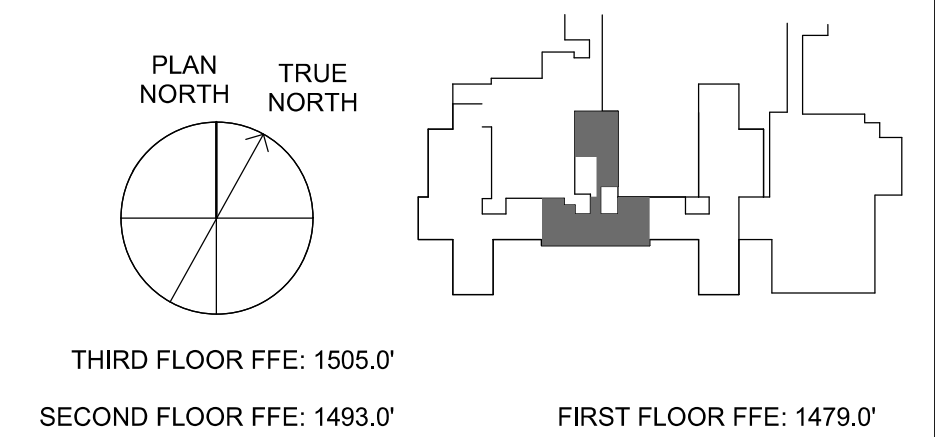

D2 PARTIAL 2 SECOND FLOOR DEMOLITION FIRE PROTECTION PLAN - PHASE 2

1/8" = 1'-0"

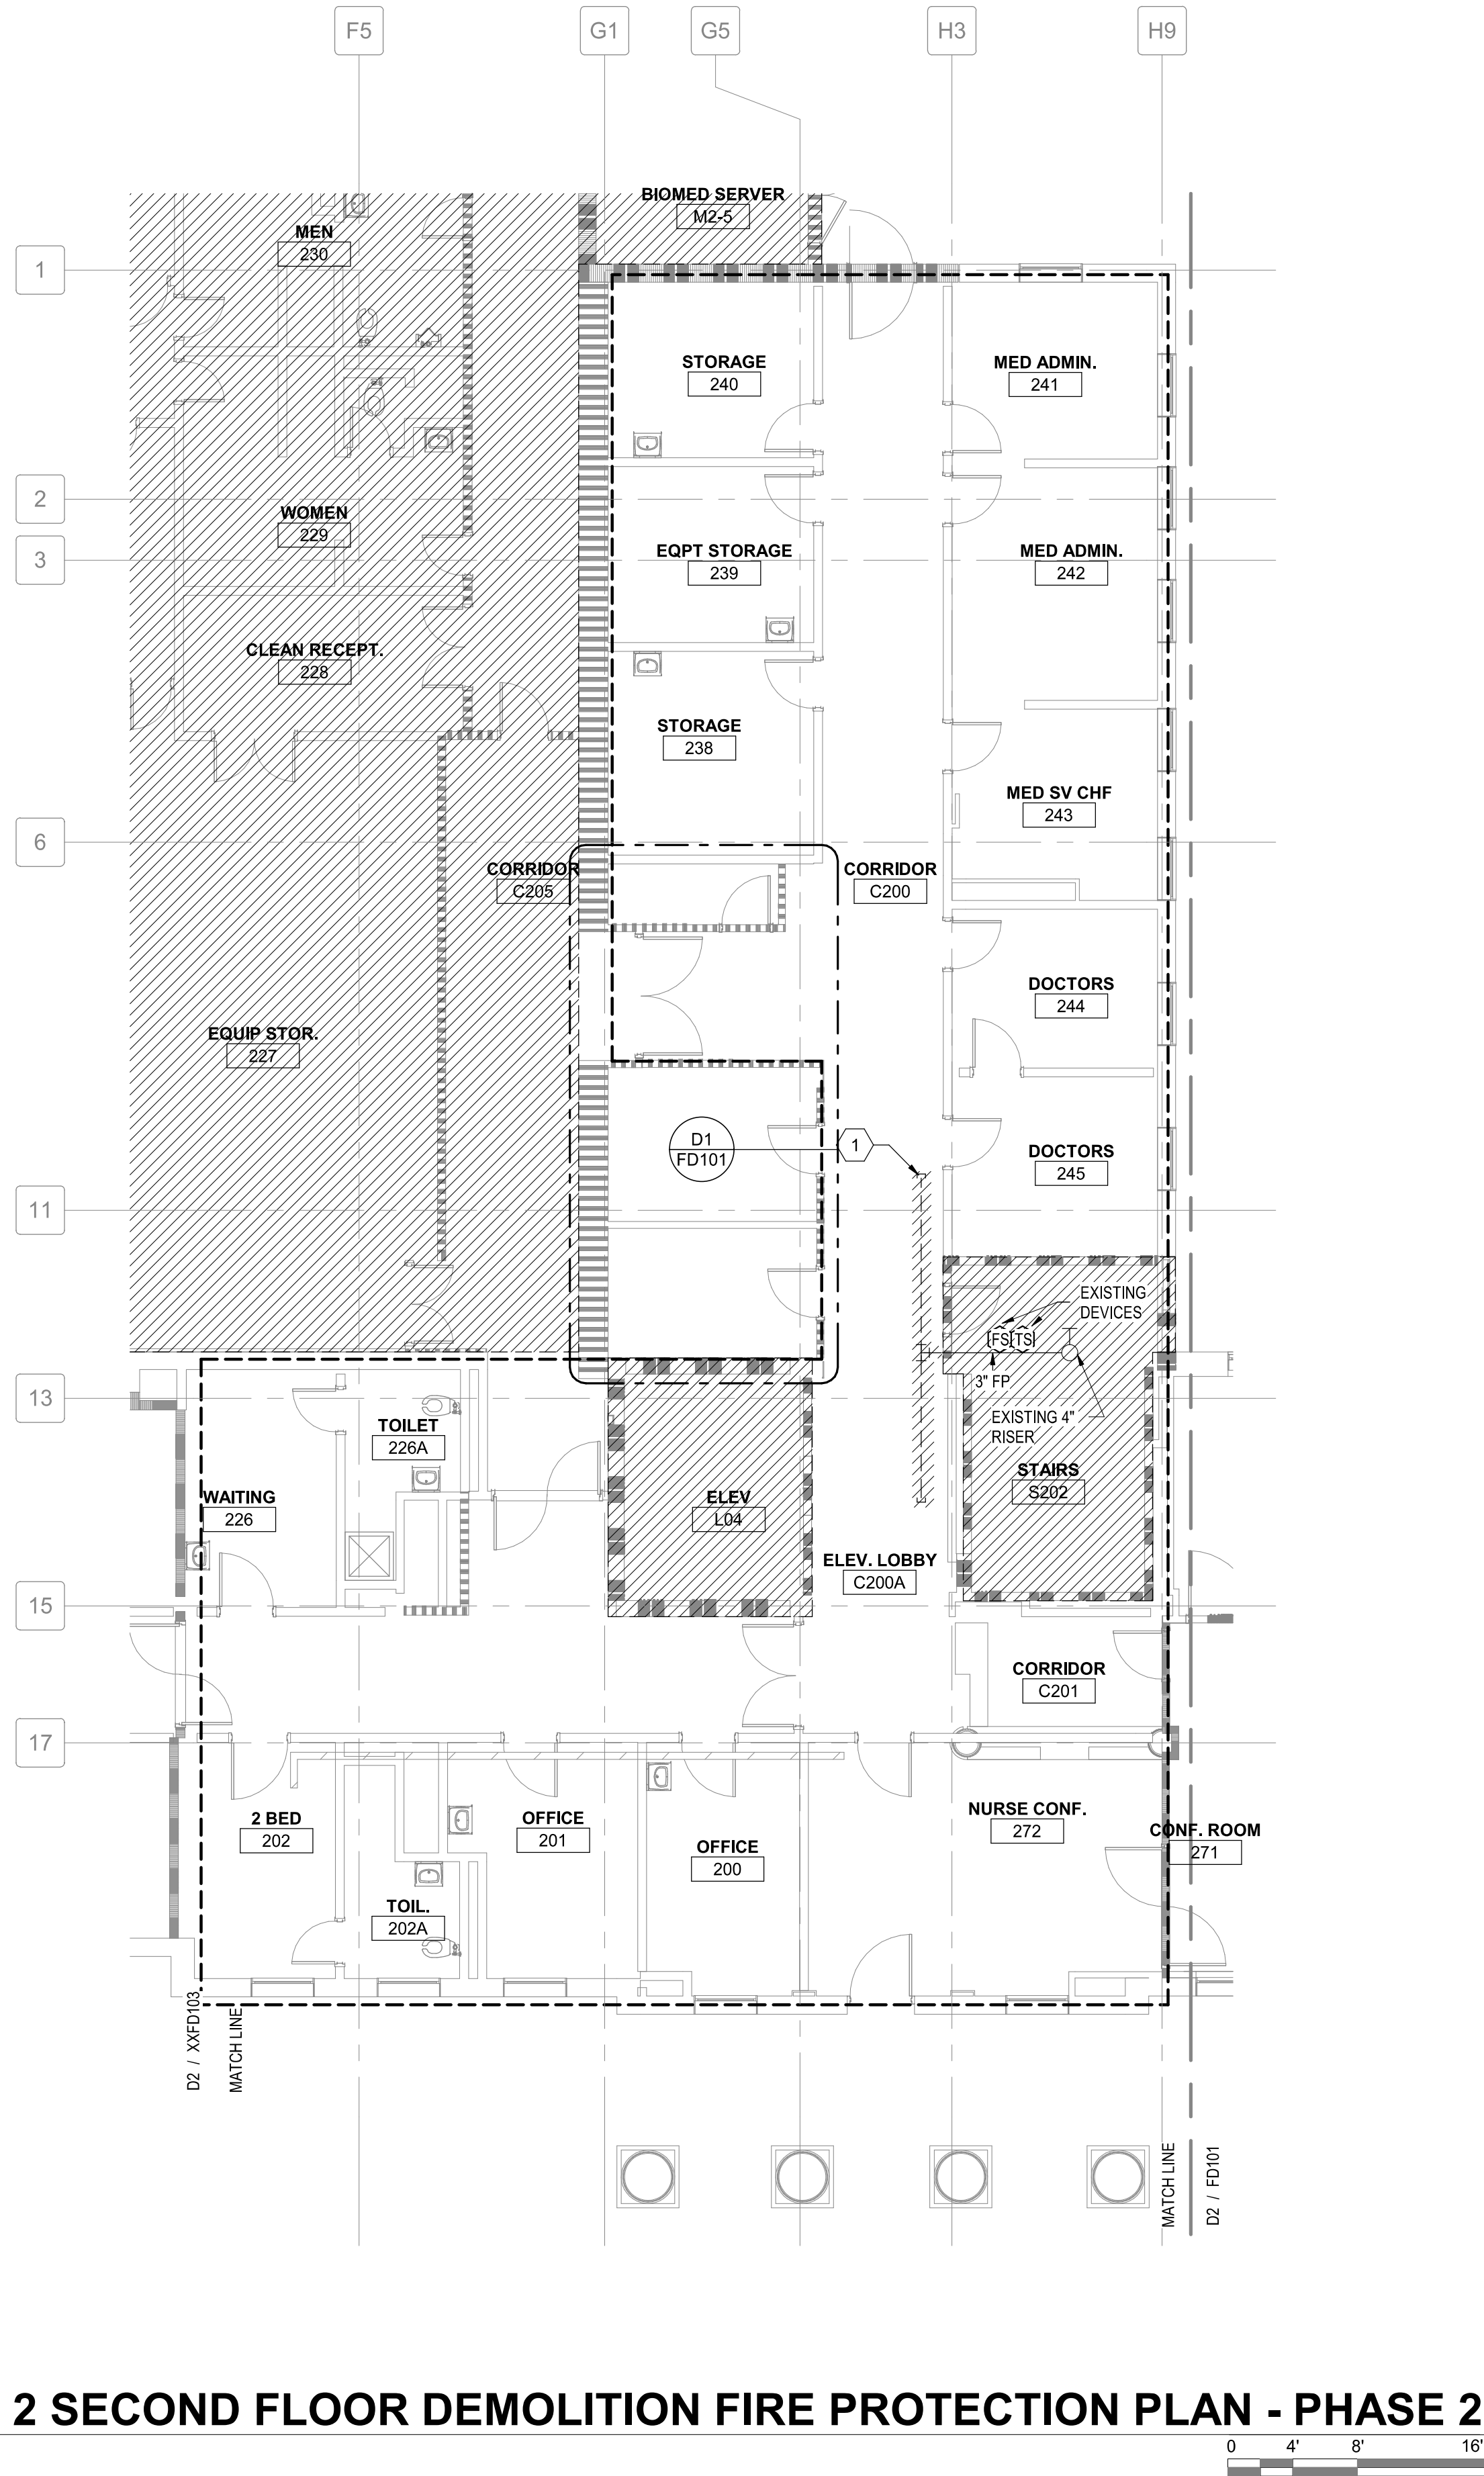

Revisions:		
No.	Description	Date

CONSULTANTS:

BRITT, PETERS AND ASSOCIATES
INC.
consulting engineers

8701 RED OAK BLVD, SUITE 500
CHARLOTTE, NC 28217
PHONE: 704.522.0405
WWW.BRITTPETERS.COM

Seal: Digital Signature not valid without Certificate below seal.

WILLIAM G. GRADY, JR.
Professional Engineer
No. 054948
Exp. 2023.03.24

ARCHITECT / ENGINEERS:

HARRELL
DESIGN GROUP, P.C.

8016 TOWER POINT DRIVE
CHARLOTTE, NC 28227

P 704.814.1320
F 704.321.0833

HDG PROJECT: 18002
COPYRIGHT © 2021

Drawing Title:
**PARTIAL 2 SECOND FLOOR
DEMOLITION FIRE PROTECTION
PLAN - PHASE 2**

Project Phase:
BID DOCUMENTS

FULLY SPRINKLERED

Project Title:
**RENOVATE MED SURGE
WARDS**

Location:
VETERANS HEALTHCARE SYSTEM
OF THE OZARKS

Date:
MARCH 24, 2024

Checked:
WGG

Drawn:
DM

Project Number:
564-17-140

Building Number:
1

Drawing Number:
FD102

Sheet **92** of **162**

Engineering Service

VETERANS HEALTH CARE SYSTEM
OF THE OZARKS

VA U.S. Department
of Veterans Affairs