

GENERAL NOTES

1. REFER TO SHEET FX001 FOR LEGEND, ABBREVIATIONS, SCHEDULES AND GENERAL NOTES.
2. INSTALL ALL NEW FIRE SPRINKLER PIPING MAIN AS HIGH AS POSSIBLE.
3. FURNISH AND INSTALL PIPING SUPPORTS IN COMPLIANCE WITH NFPA 13.
4. ALL NEW FIRE SPRINKLER PIPING PENETRATING RATED WALLS SHALL BE SEALED WITH FIRE CAULK ON EACH FACING OF THE WALL.
5. PRIOR TO THE START OF THE PROJECT, CONTRACTOR SHALL FIELD COORDINATE THE LOCATION OF ALL CEILING DEVICES WITH NEW FIRE SPRINKLERS. THIS INCLUDES BUT IS NOT LIMITED TO LIGHTS, AIR DEVICES, SPEAKERS, STROBES AND ETC.

SHEET KEYNOTES

1. INSTALL ESCUTCHEON PLATES ON EXISTING SPRINKLERS IN HARD CEILING AREAS.
2. INSTALL ESCUTCHEON PLATES ON EXISTING SPRINKLERS IN LAY-IN CEILING AREAS.
3. FOR ALTERNATE 6, REMOVE ALL WORK PERTAINING TO THE INSTALLATION OF THE BOOSTER PUMP ASSEMBLY. SEE G001 FOR MORE INFORMATION.

PARTITION GRAPHICS



PARTITION PHASING

- EXISTING ELEMENT TO REMAIN
- EXISTING ELEMENT TO BE DEMOLISHED
- TEMPORARY 1-HOUR RATED ELEMENT TO BE CONSTRUCTED AND DEMOLISHED IN SAME PHASE

PARTITION RATING

- NO RATING
- SMOKE RESISTIVE PARTITION - NON RATED
- 1 HOUR FIRE BARRIER
- 1 HOUR FIRE/SMOKE BARRIER
- 2 HOUR FIRE BARRIER
- 2 HOUR FIRE/ SMOKE BARRIER

KEY PLAN

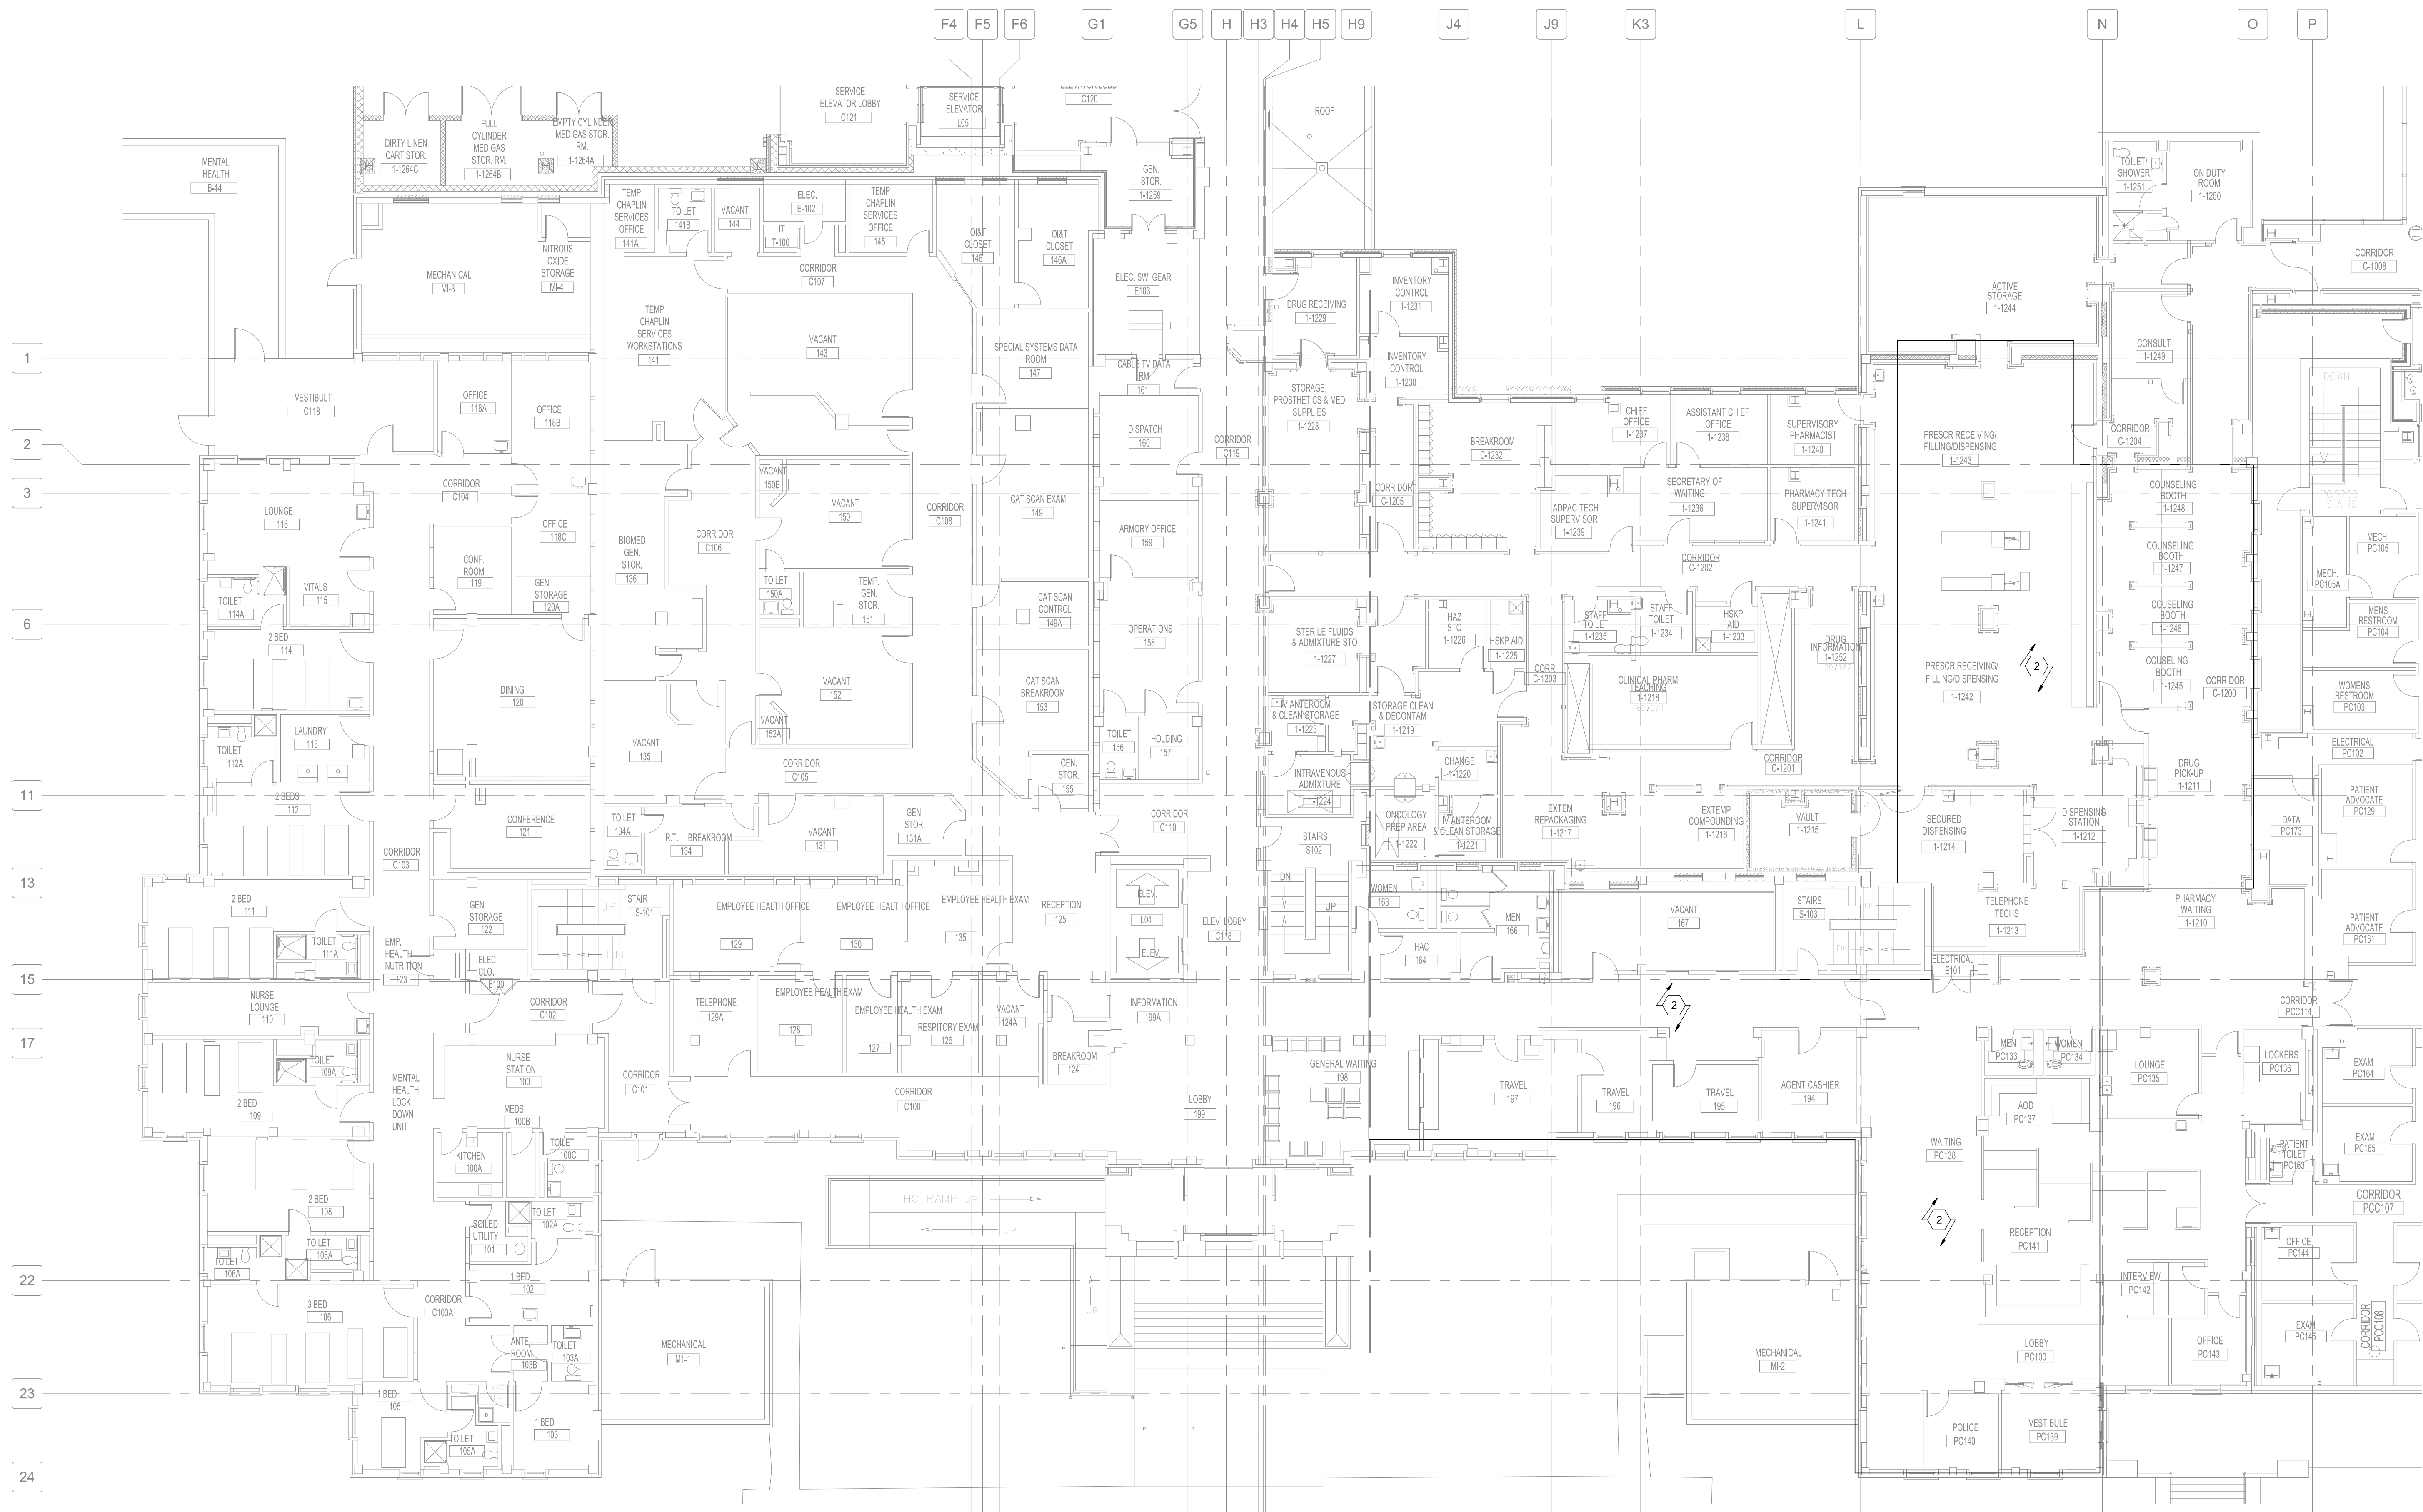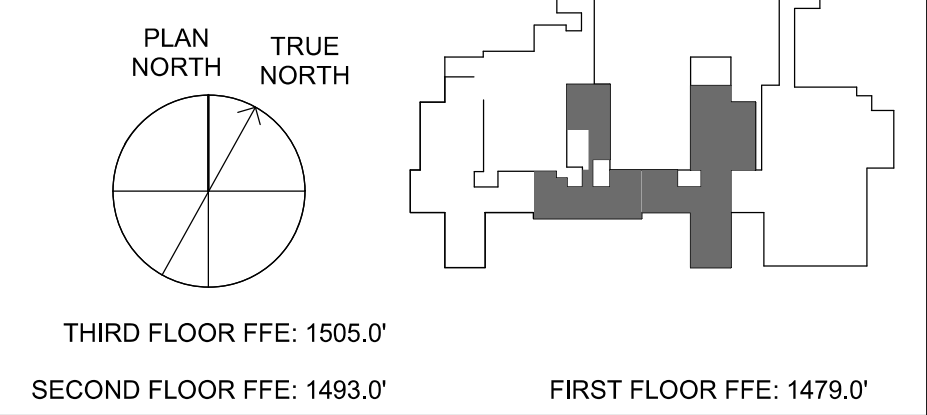

C1 FIRST FLOOR FIRE PROTECTION PLAN



D3 BASEMENT FIRE PROTECTION PLAN

Revisions:		
No.	Description	Date

CONSULTANTS:

BRITT, PETERS AND ASSOCIATES

8701 RED OAK BLVD, SUITE 500
CHARLOTTE, NC 28217
PHONE: 704.522.0405
WWW.BRITTPETERS.COM

Seal: Digital Signature not valid without Certificate below seal.

WILLIAM G. C. O'NEILL

Professional Engineer
No. 054948
Exp. 12-31-24

ARCHITECT / ENGINEERS:

HARRELL

DESIGN GROUP, P.C.

8016 TOWER POINT DRIVE
CHARLOTTE, NC 28227

P 704.814.1320
F 704.321.0833

HGD PROJECT: 18002
COPYRIGHT © 2021

Drawing Title:

BASEMENT FIRST FLOOR FIRE PROTECTION PLANS

Project Phase:

BID DOCUMENTS

FULLY SPRINKLERED

Project Title:

RENOVATE MED SURGE WARDS

Location:

VETERANS HEALTHCARE SYSTEM OF THE OZARKS

Date:

MARCH 24, 2024

Checked:

WGG

Drawn:

DM

Project Number:

564-17-140

Building Number:

Drawing Number:

FX100

Sheet 97 of 162

Engineering Service



VA U.S. Department of Veterans Affairs