
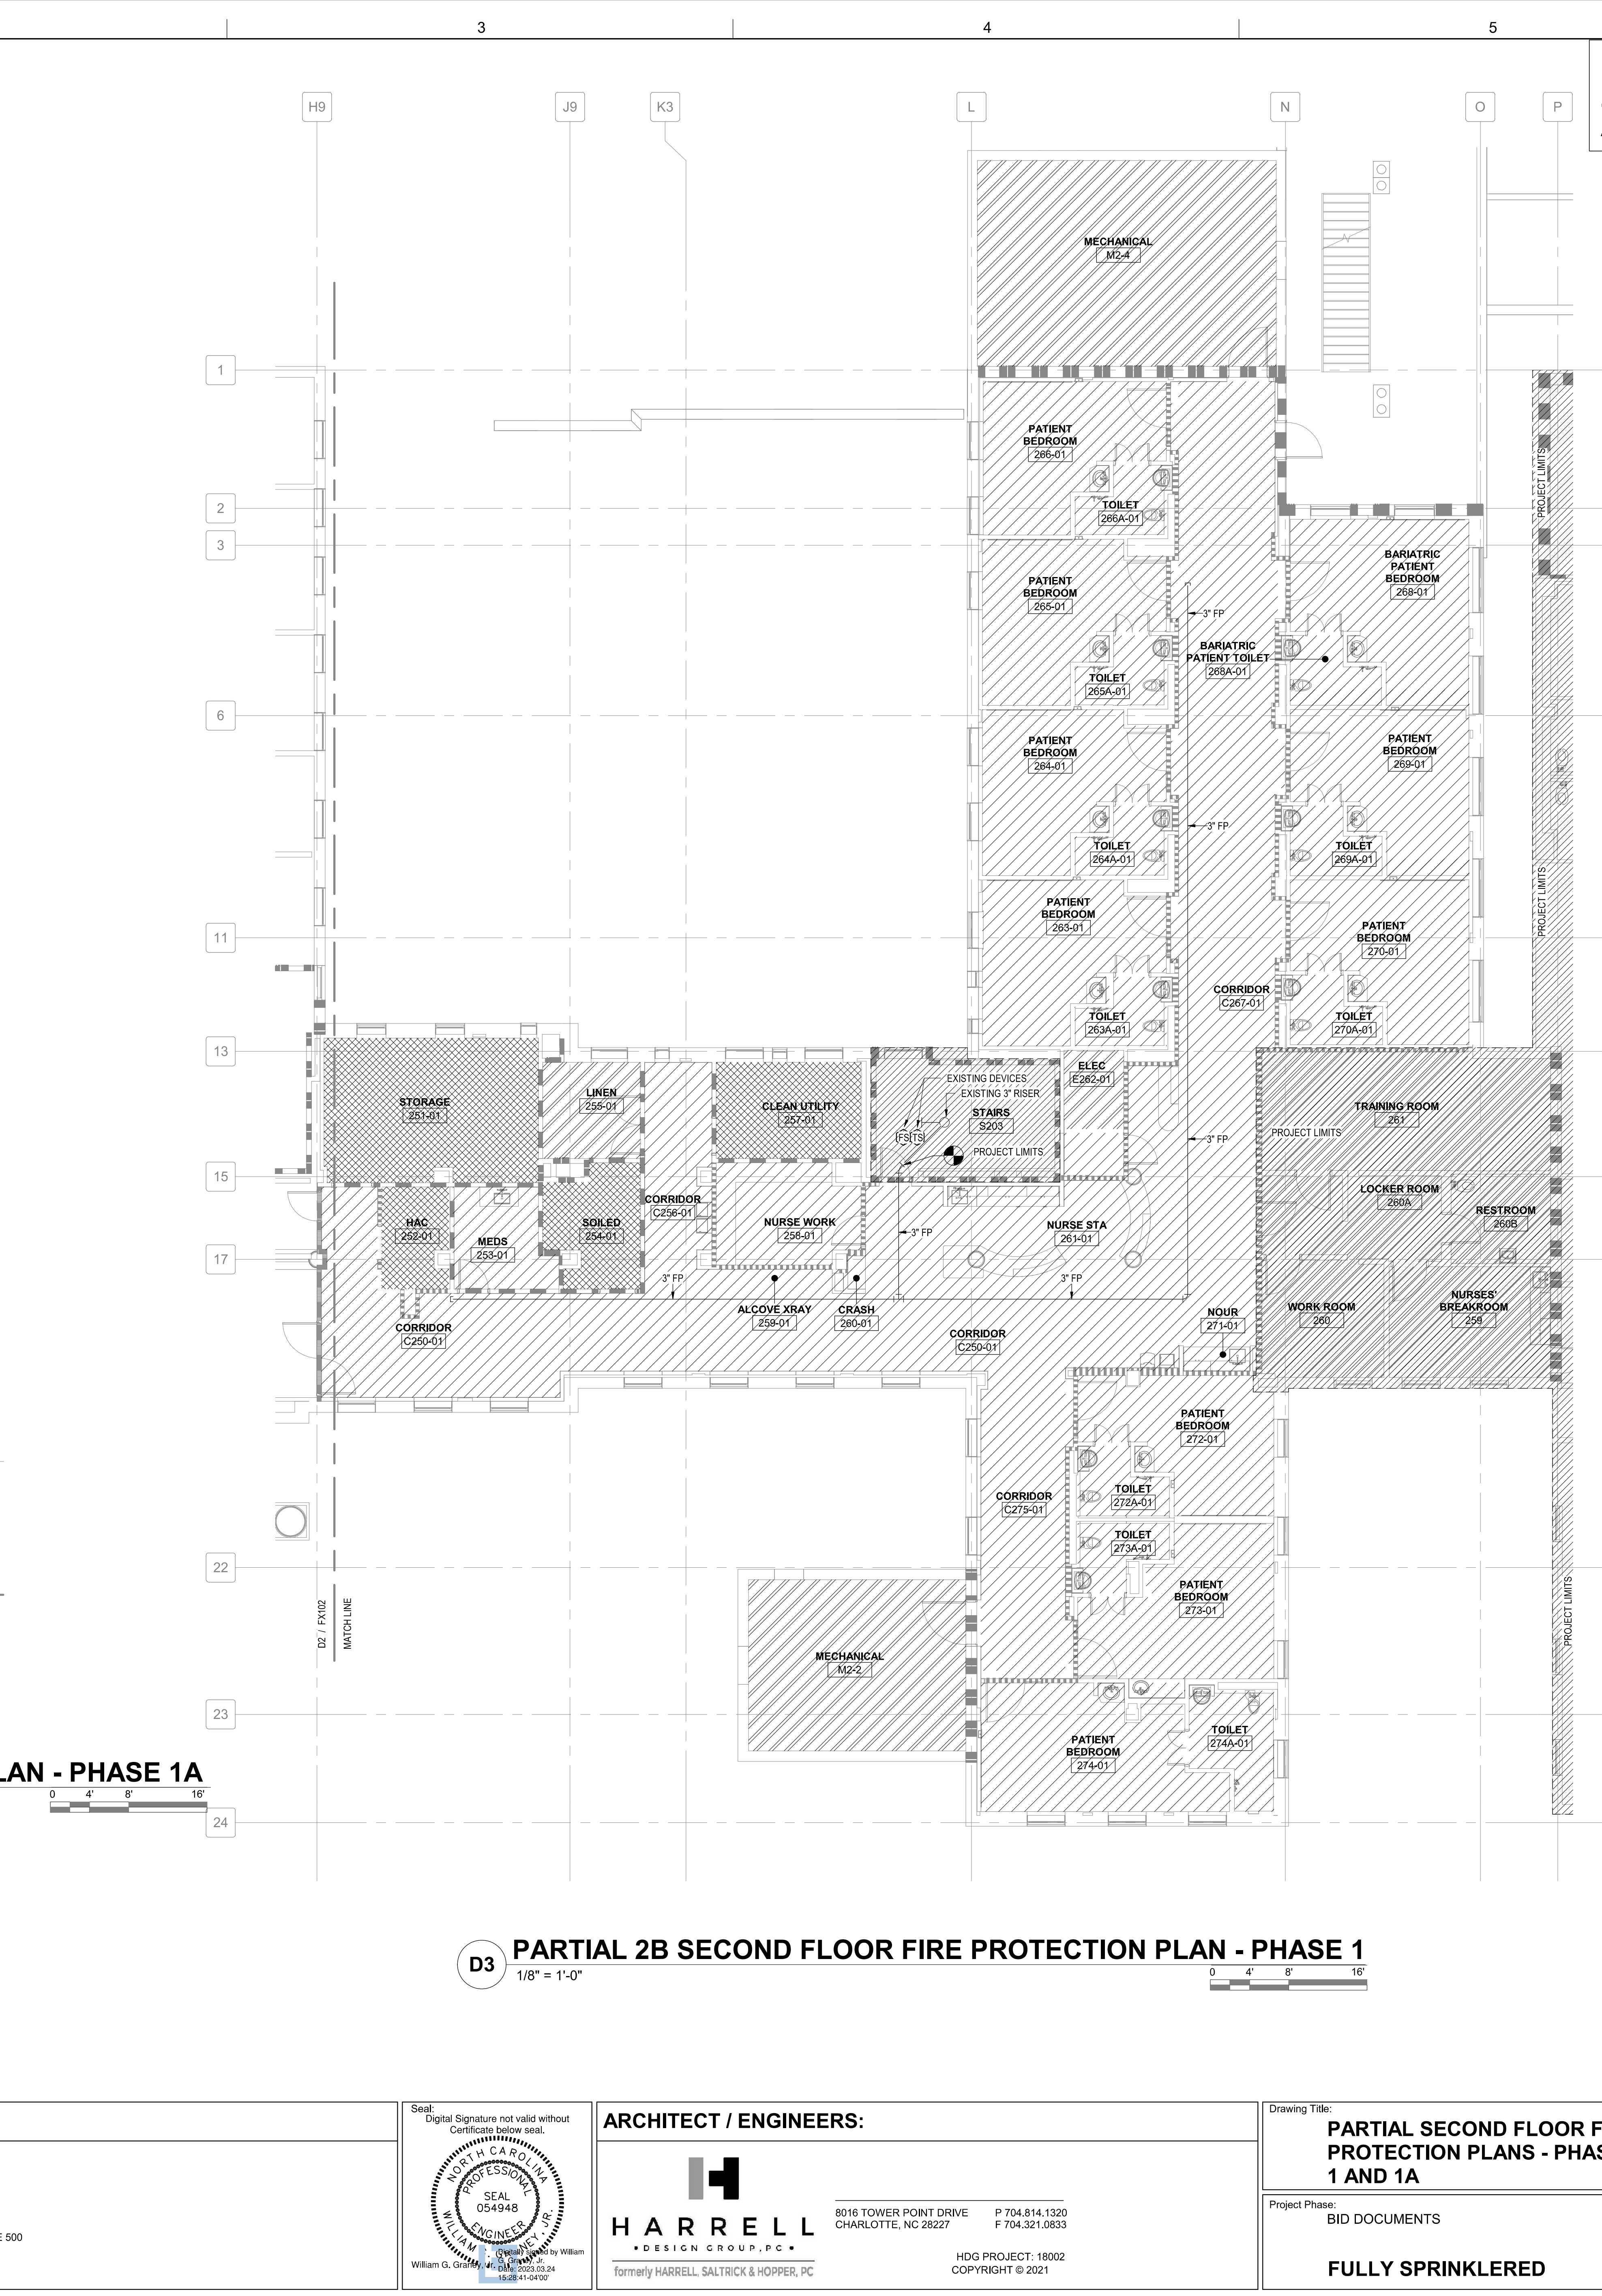


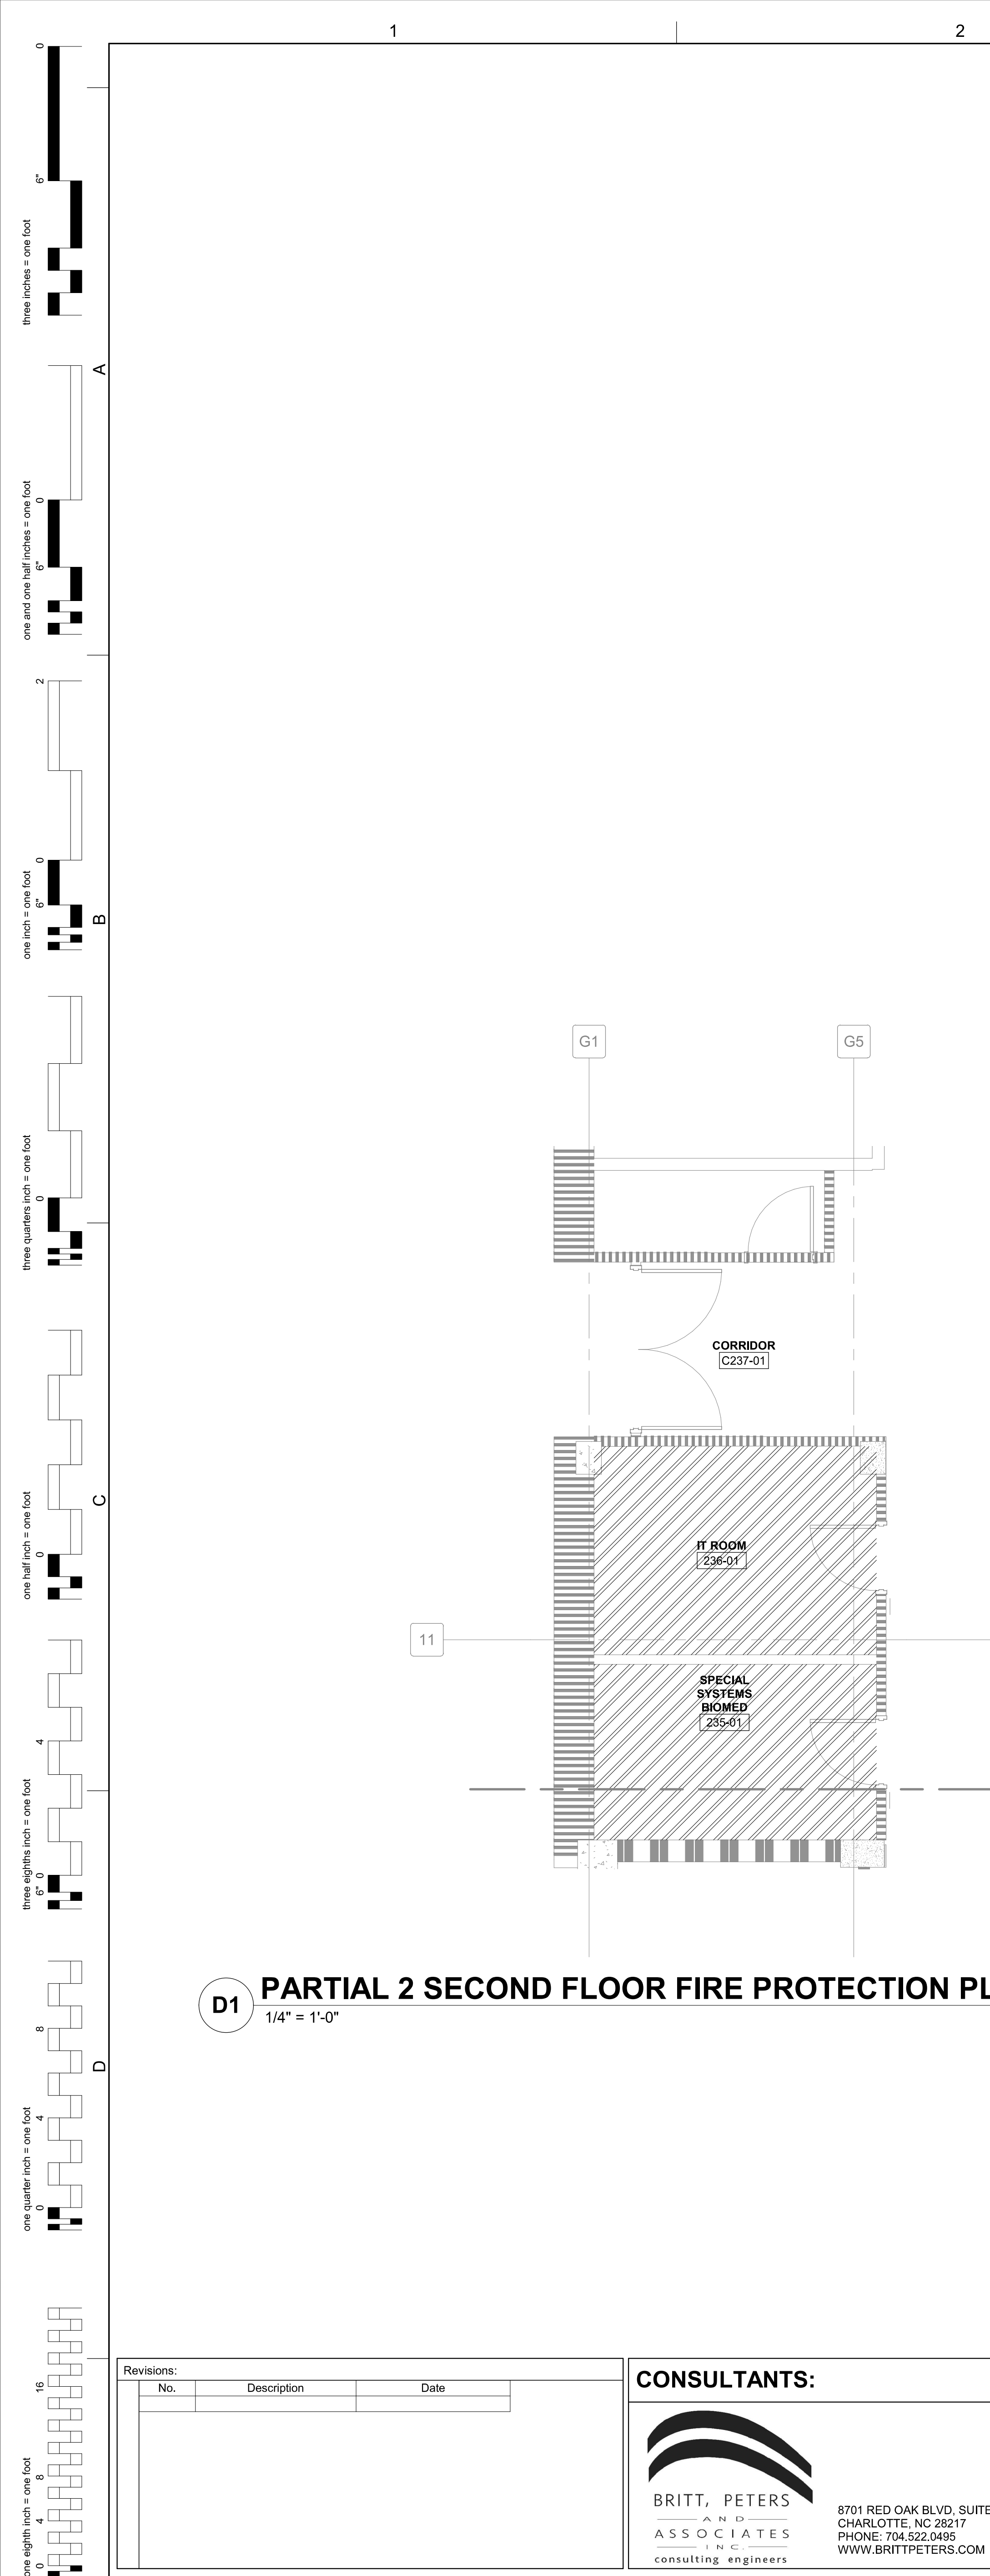

**PHASING NOTES:
REFER TO PHASING ON SHEETS
GC119 THRU GC125 FOR PHASED
AREAS OF WORK.**

GENERAL NOTES

1. REFER TO SHEET FX001 FOR LEGEND, ABBREVIATIONS, SCHEDULES AND GENERAL NOTES.
2. INSTALL ALL NEW FIRE SPRINKLER PIPING MAIN AS HIGH AS POSSIBLE.
3. FURNISH AND INSTALL PIPING SUPPORTS IN COMPLIANCE WITH NFPA 13.
4. ALL NEW FIRE SPRINKLER PIPING PENETRATING RATED WALLS SHALL BE SEALED WITH FIRE CAULK ON EACH FACING OF THE WALL.
5. PRIOR TO THE START OF THE PROJECT, CONTRACTOR SHALL FIELD COORDINATE THE LOCATION OF ALL CEILING DEVICES WITH NEW FIRE SPRINKLERS. THIS INCLUDES BUT IS NOT LIMITED TO LIGHTS, AIR DEVICES, SPEAKERS, STROBES AND ETC.

SHEET KEYNOTES

PARTITION GRAPHICS


PARTITION PHASING

	EXISTING ELEMENT TO REMAIN
	EXISTING ELEMENT TO BE DEMOLISHED
	TEMPORARY 1-HOUR RATED ELEMENT TO BE CONSTRUCTED AND DEMOLISHED SAME PHASE

PARTITION RATING

	NO RATING
	SMOKE RESISTIVE PARTITION - NON RATED
	1 HOUR FIRE BARRIER
	1 HOUR FIRE/SMOKE BARRIER
	2 HOUR FIRE BARRIER
	2 HOUR FIRE/ SMOKE BARRIER

KEY PLAN

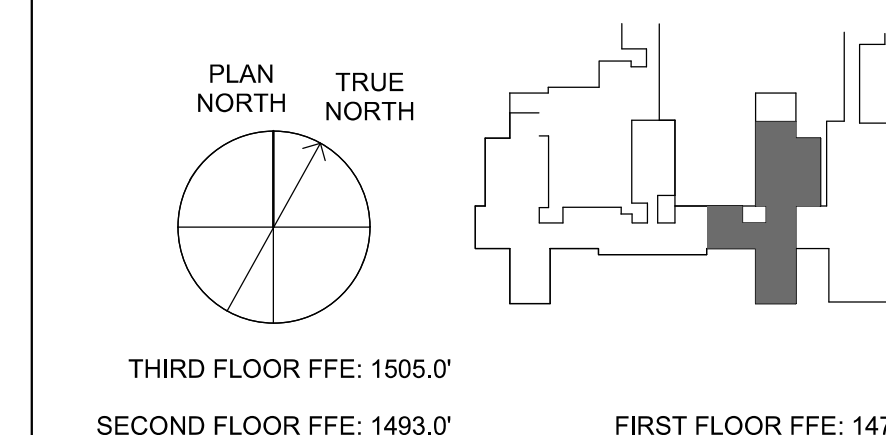

Revisions:		
No.	Description	Date

	CONSULTANTS:
--	---------------------



8701 RED OAK BLVD, SUITE 500
CHARLOTTE, NC 28217
PHONE: 704.522.0495
WWW.BRITTPETERS.COM

Seal:
Digital Signature not valid without
Certificate below seal.

**NORTH CAROLINA
PROFESSIONAL
SEAL
054948
WILLIAM G. GRASHEW, JR.
ENGINEER**

Seal created by W
G. Grashew, Jr.
15-0381-04-0074
15-0381-04-0074

William G. Grashew, Jr.

ARCHITECT / ENGINEERS:



HARRELL
• DESIGN GROUP, P.C. •
formerly HARRELL, SALTRICK & HOPPER, P.C.

8016 TOWER POINT DRIVE P 704.814.1320
CHARLOTTE, NC 28227 F 704.321.0833

HDG PROJECT: 18002
COPYRIGHT © 2021

Drawing Title:

PARTIAL SECOND FLOOR FIRE PROTECTION PLANS - PHASES 1 AND 1A

Project Phase:
BID DOCUMENTS

FULLY SPRINKLERED

Project Title:

Project Title:

**RENOVATE MED SURGE
WARDS**

Location: **VETERANS HEALTH**

S HEALTH
ZARKS

RE SYS

Project Number:

Project Number: 564-17-140

Building Number: 1

Drawing Number:

FATI
Start 94 163

**Engineering
Service**



VA U.S. Department
of Veterans Affairs