

0

8"

three inches = one foot

0

2

one and one half inches = one foot

0

2

one inch = one foot

0

3

three quarters inch = one foot

0

4

one half inch = one foot

0

4

one quarter inch = one foot

0

8

one eighth inch = one foot

0

16

one sixteenth inch = one foot

A

B

C

D

E

F

PHASING NOTES:
REFER TO PHASING ON SHEETS GC119 THRU GC125 FOR PHASED AREAS OF WORK.

SEE DEDUCT ALTERNATE 5 ON SHEET GI001 FOR ALTERNATE WORK PHASE 2. REFER GC123a AND GC123b FOR MORE INFORMATION.

- GENERAL NOTES**
- REFER TO SHEET FX001 FOR LEGEND, ABBREVIATIONS, SCHEDULES AND GENERAL NOTES.
 - INSTALL ALL NEW FIRE SPRINKLER PIPING MAIN AS HIGH AS POSSIBLE.
 - FURNISH AND INSTALL PIPING SUPPORTS IN COMPLIANCE WITH NFPA 13.
 - ALL NEW FIRE SPRINKLER PIPING PENETRATING RATED WALLS SHALL BE SEALED WITH FIRE CALK ON EACH FACING OF THE WALL.
 - PRIOR TO THE START OF THE PROJECT, CONTRACTOR SHALL FIELD COORDINATE THE LOCATION OF ALL CEILING DEVICES WITH NEW FIRE SPRINKLERS. THIS INCLUDES BUT IS NOT LIMITED TO LIGHTS, AIR DEVICES, SPEAKERS, STROBES AND ETC.

SHEET KEYNOTES

PARTITION GRAPHICS

PARTITION PHASING

EXISTING ELEMENT TO REMAIN

EXISTING ELEMENT TO BE DEMOLISHED

TEMPORARY 1-HOUR RATED ELEMENT TO BE CONSTRUCTED AND DEMOLISHED IN SAME PHASE

PARTITION RATING

NO RATING

SMOKE RESISTIVE PARTITION - NON RATED

1 HOUR FIRE BARRIER

1 HOUR FIRE/SMOKE BARRIER

2 HOUR FIRE BARRIER

2 HOUR FIRE/ SMOKE BARRIER

KEY PLAN


PLAN NORTH

TRUE NORTH

THIRD FLOOR FFE: 1505.0'

SECOND FLOOR FFE: 1493.0'

FIRST FLOOR FFE: 1479.0'

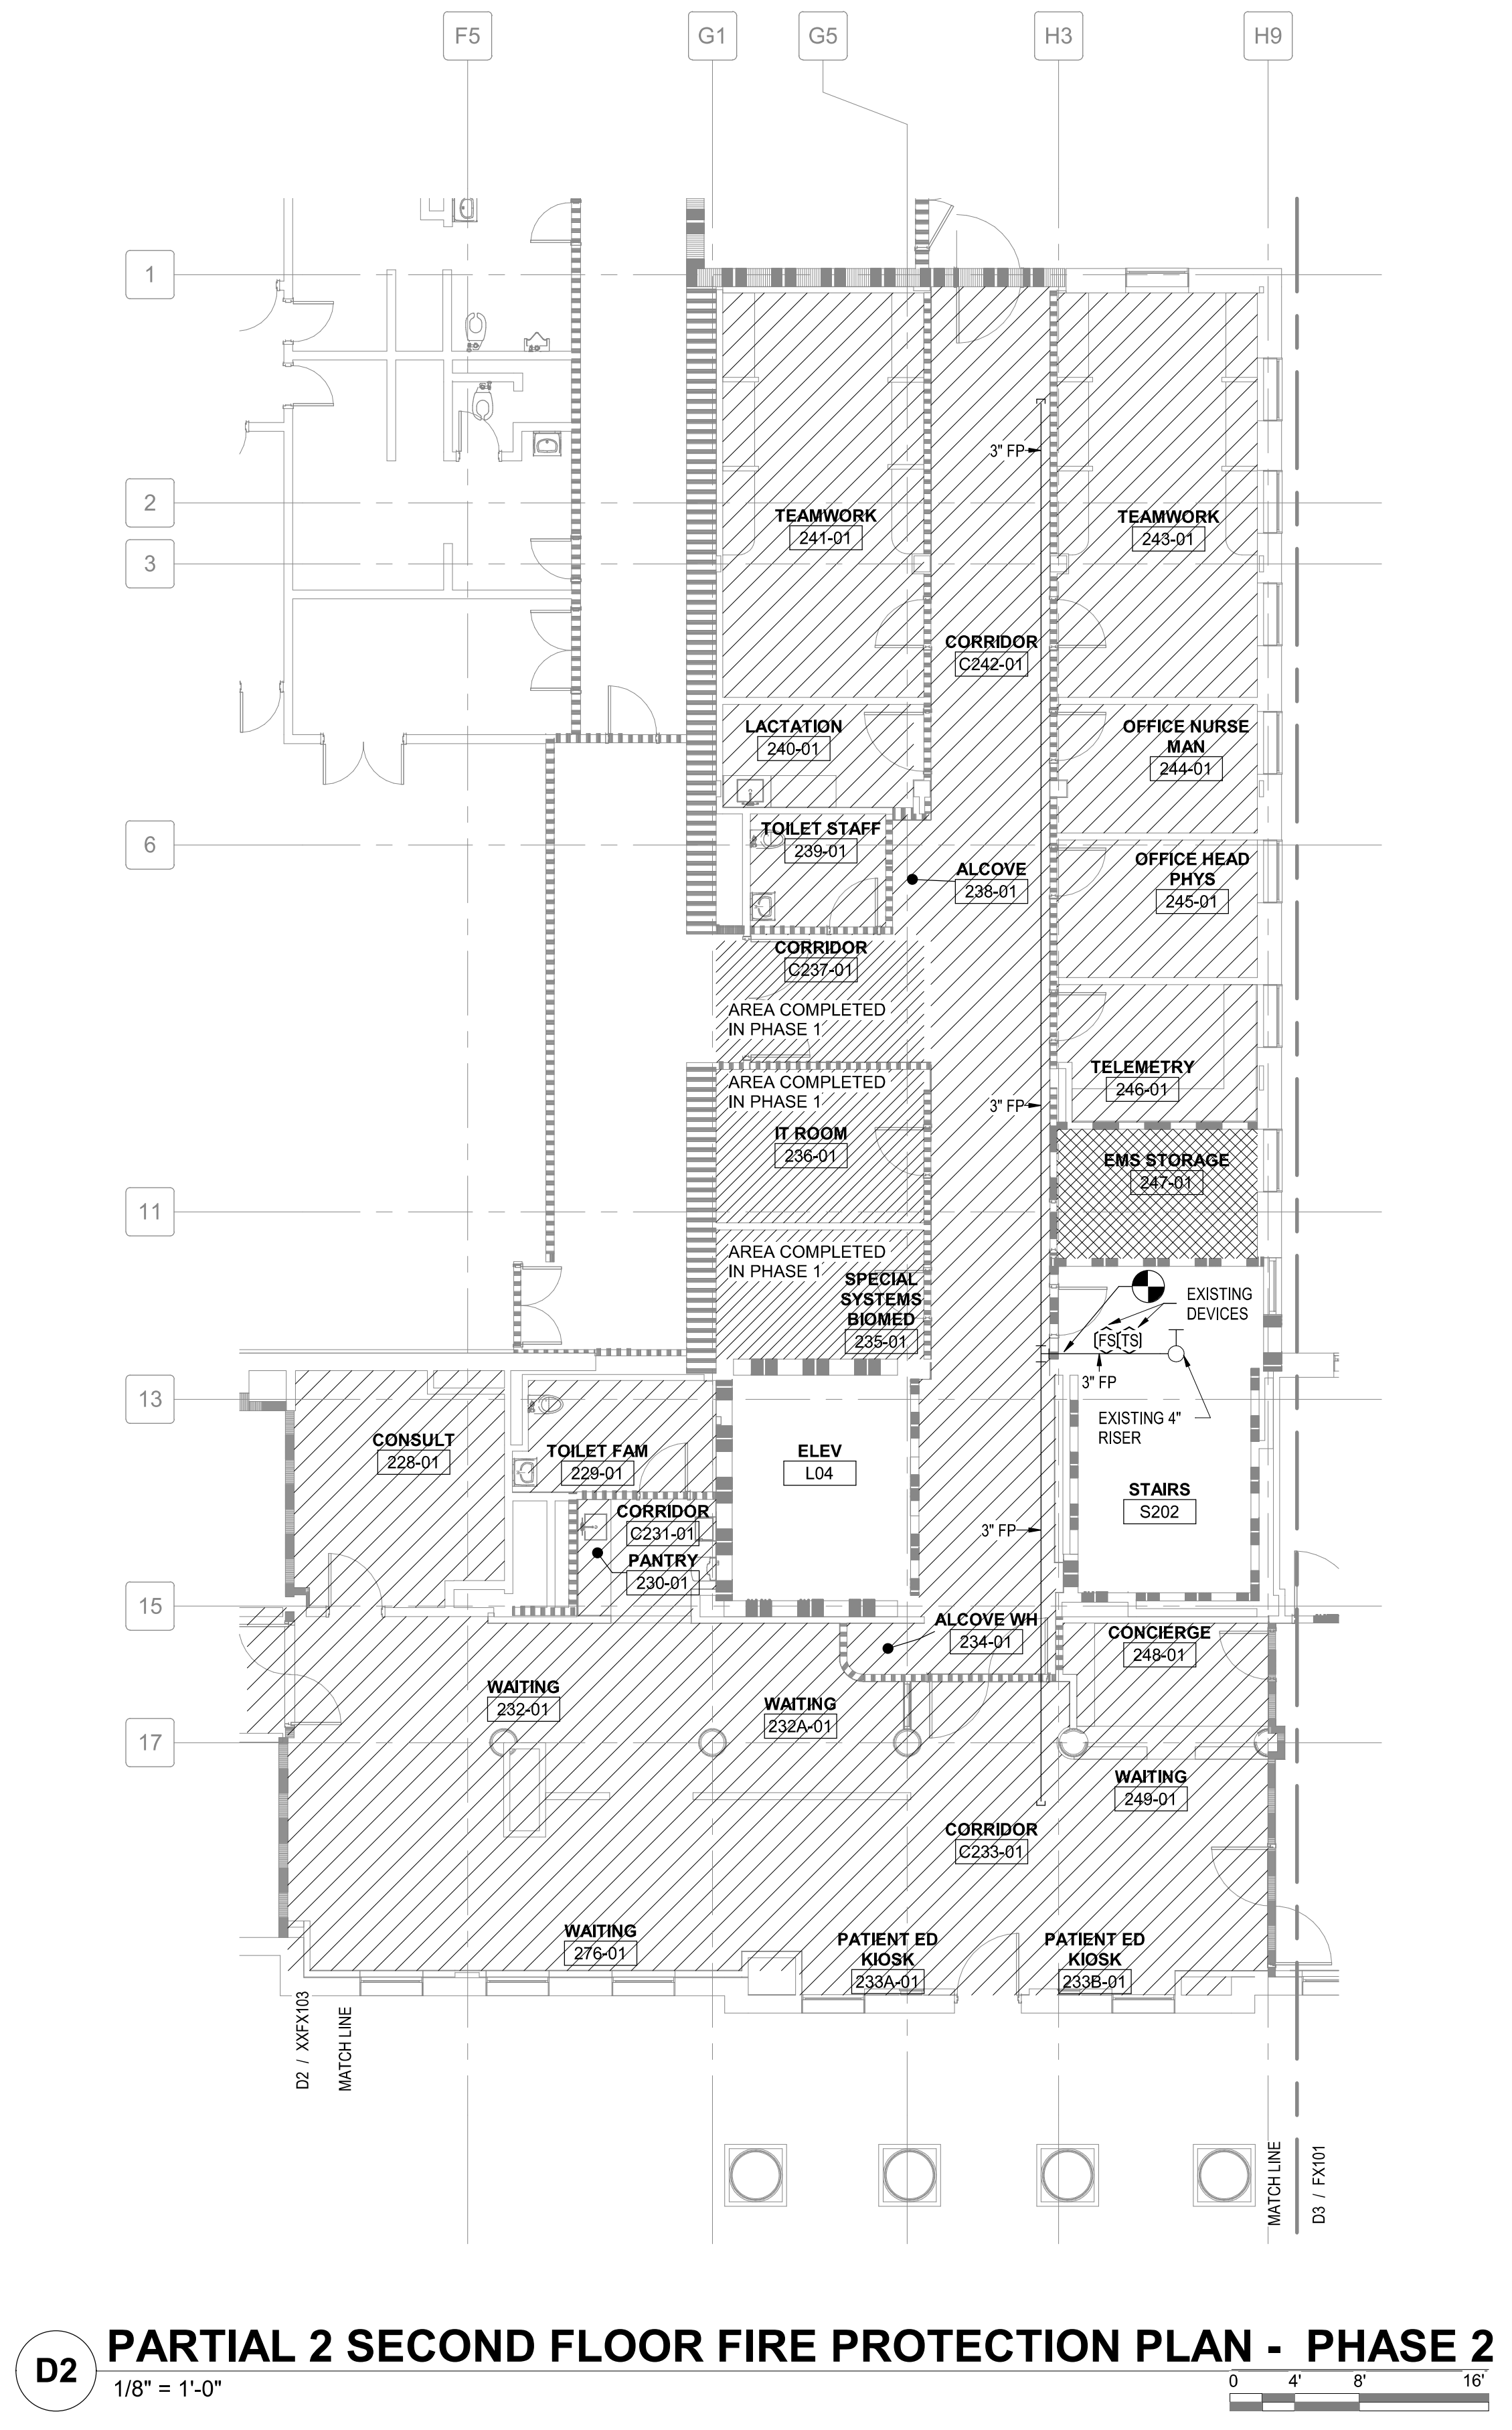

D2 PARTIAL 2 SECOND FLOOR FIRE PROTECTION PLAN - PHASE 2

1/8" = 1'-0"

Revisions:		
No.	Description	Date

CONSULTANTS:

BRITT, PETERS AND ASSOCIATES INC.
consulting engineers

8701 RED OAK BLVD, SUITE 500
CHARLOTTE, NC 28217
PHONE: 704.522.0405
WWW.BRITTPETERS.COM

Seal

Digital Signature not valid without Certificate below seal.

WILLIAM G. GRANLEY, JR.
Professional Engineer
No. 054948
Exp. 12/31/2024

William G. Granley, Jr.
Date: 2023.03.24
1932-26-0402

ARCHITECT / ENGINEERS:

HARRELL
DESIGN GROUP, P.C.

8016 TOWER POINT DRIVE
CHARLOTTE, NC 28227

P 704.814.1320
F 704.321.0833

HDG PROJECT: 18002
COPYRIGHT © 2021

Drawing Title:

PARTIAL 2 SECOND FLOOR FIRE PROTECTION PLAN - PHASE 2

Project Phase:

BID DOCUMENTS

FULLY SPRINKLERED

Project Title:

RENOVATE MED SURGE WARDS

Location:

VETERANS HEALTHCARE SYSTEM OF THE OZARKS

Date:

MARCH 24, 2024

Checked:

WGG

Drawn:

DM

Project Number:

564-17-140

Building Number:

1

Drawing Number:

FX102

Sheet **95** of **162**

Engineering Service

VETERANS HEALTH CARE SYSTEM OF THE OZARKS

VA U.S. Department of Veterans Affairs