

SUITE DESCRIPTIONS

SUITE NUMBER	SUITE NAME	SUITE SIZE	EXIT NUMBER	TYPE OF SUITE
1	SURGERY SUITE	6,707 Sq. Ft.	2	NON PATIENT CARE
2	ICU SUITE	4,178 Sq. Ft.	2	NON PATIENT CARE
3	OUTPATIENT SURGERY SUITE	1,835 Sq. Ft.	1	NON SLEEPING PATIENT CARE

KEY NOTES:

- A

SPRINKLER LAYOUT MEETS FLOOR OBSTRUCTION REQUIREMENTS OF SECTION 8.6.5.2.2 OF NFPA 13-2013 EDITION.
- B

SEE EQUIVALENCY FOR OVER SIZED PROTECTIVE PLATES ON FIRE DOORS.
- C

FIRE SPRINKLERS INSTALLED PER THE 3:1 MAXIMUM DIMENSION OBSTRUCTION REQUIREMENTS OF SECTION 8.6.5.2.1.3 OF NFPA 13-2013 EDITION.
- D

EXISTING HEALTH CARE OCCUPANCY DEAD END CORRIDORS EXCEEDING 30 FEET PERMITTED PER SECTION 19.2.5.2 OF NFPA 101-2015 EDITION. SEE ADDITIONAL DOCUMENTS IN SOC BINDER.

SYMBOLS LIST

- 2 HOUR FIRE/SMOKE BARRIER
- 1 HOUR FIRE/SMOKE BARRIER
- 2 HOUR FIRE BARRIER
- 1 HOUR FIRE BARRIER
- SMOKE RESISTIVE HAZARDOUS AREA
- NON RATED SMOKE PARTITION
- NON-RATED SMOKE BARRIER (COMMUNICATING SPACE)
- NON-FIRE-RATED PARTITION
- HE

HORIZONTAL EXIT PASSAGEWAY
- EX


EXIT
- EP

EXIT PASSAGEWAY
- LC

LINEN CHUTE
- TC

TRASH CHUTE
- SUITE DESIGNATIONS
- AREA OPEN TO CORRIDOR - WITH SMOKE DETECTION
- AREA OPEN TO CORRIDOR - NO SMOKE DETECTION REQUIRED
- EXIT STAIR OR PASSAGEWAY
- FIRE EXTINGUISHER
- DIRECTION OF EXIT SIGN CHEVRON
- DIRECTION OF EXIT SIGN ILLUMINATION
- BATTERY PACK LIGHT
- EWS

EYE WASH STATION

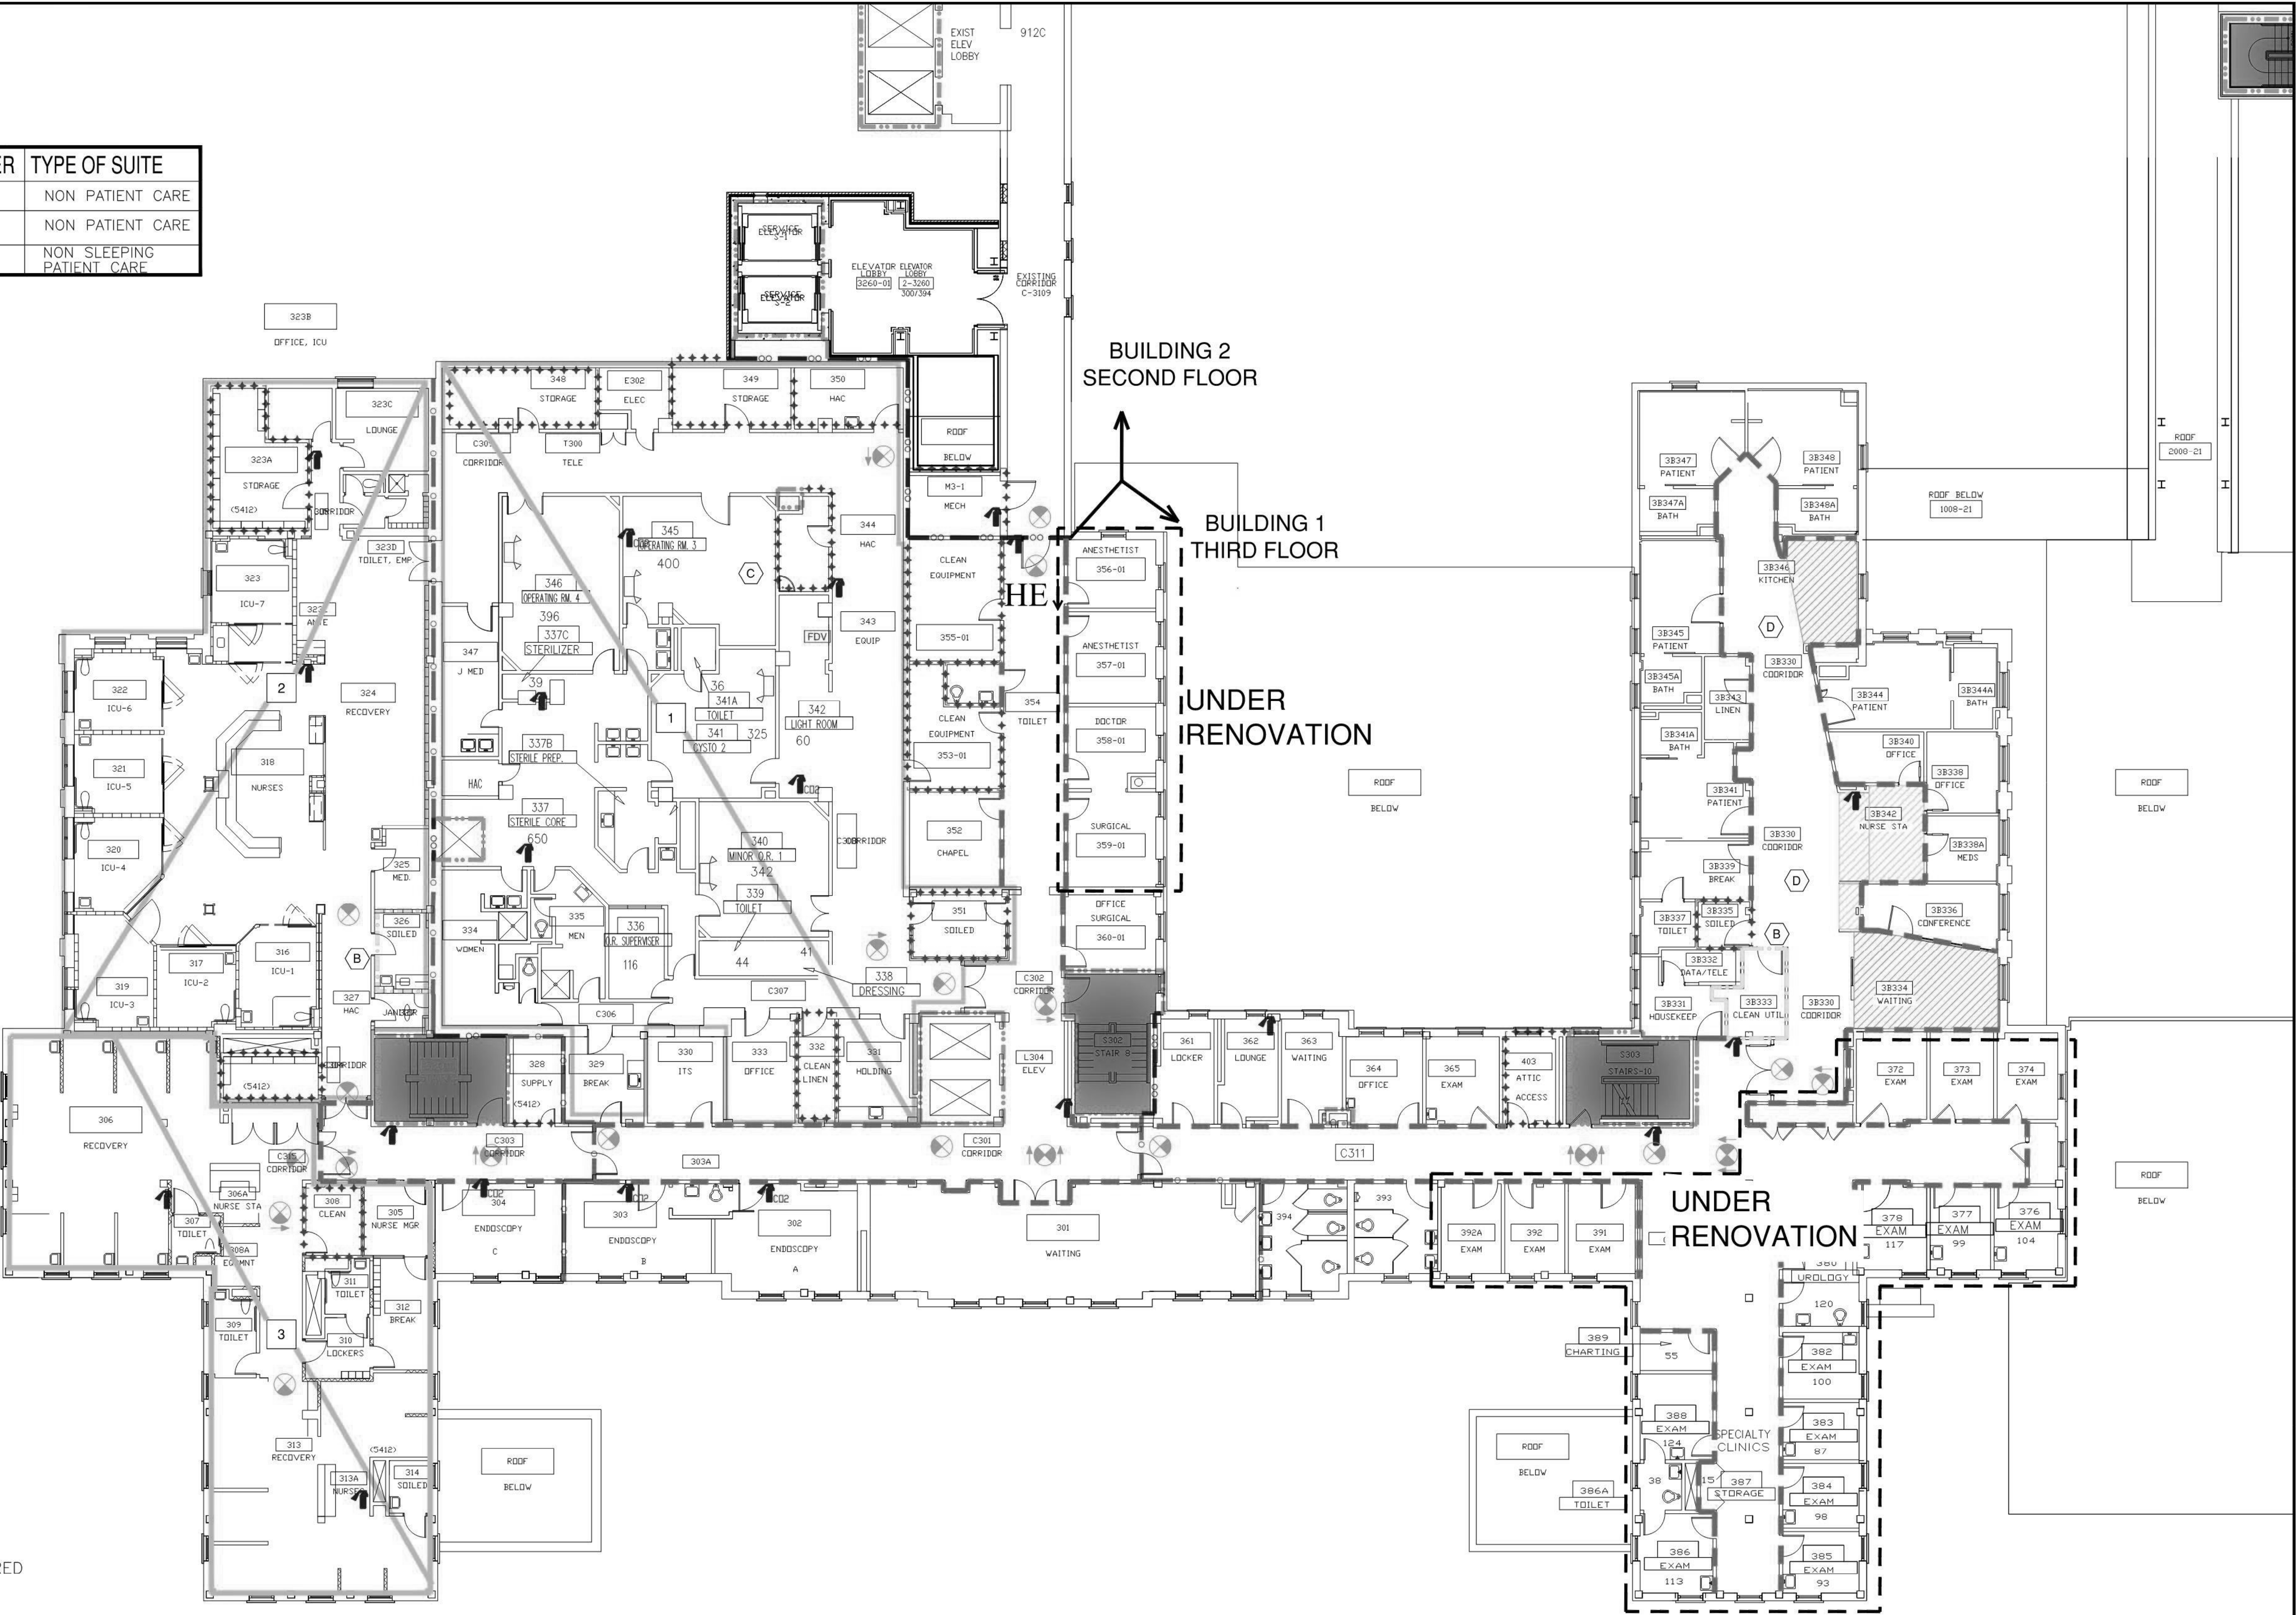

BUILDING 1 THIRD FLOOR



FULLY SPRINKLERED
HEALTH CARE OCCUPANCY

FOR REFERENCE ONLY

Revisions	Date	 Dept. of Veterans Affairs VA Medical Center 1100 North College Fayetteville, AR 72703	 Goodwin Facilities Solutions 19375 Highway 74 Elkins, AR 72727	 FIRE PROTECTION & CODE CONSULTANTS, L.L.C. 1520 MAIN STREET INDIANAPOLIS, IN 46224 (317)486-5188	Drawing Title BUILDING 1 THIRD FLOOR	Contract No. AutoCAD File Name SOC04 1-3	Project Title STATEMENT OF CONDITIONS	Designed By FVO	Checked By FVO	Drawn By KW/DN	Date 1/26/17	Drawing No. SOC-9 Sht. 22 of 162
FP&C Proj. #:	1552.27							Location	VA MEDICAL CENTER FAYETTEVILLE, ARKANSAS	Scale:	N.T.S.	
GFS Proj. #:												