


FLAG NOTES

- 1 REMOVE WIRING TO EXISTING FAN COIL UNIT.
- 2 REMOVE WIRING TO EXISTING FURNACE.
- 3 REMOVE WIRING TO EXISTING WINDOW/PORTABLE AIR CONDITIONER.
- 4 EXISTING RADIATOR REMOVE BY MECHANICAL CONTRACTOR.

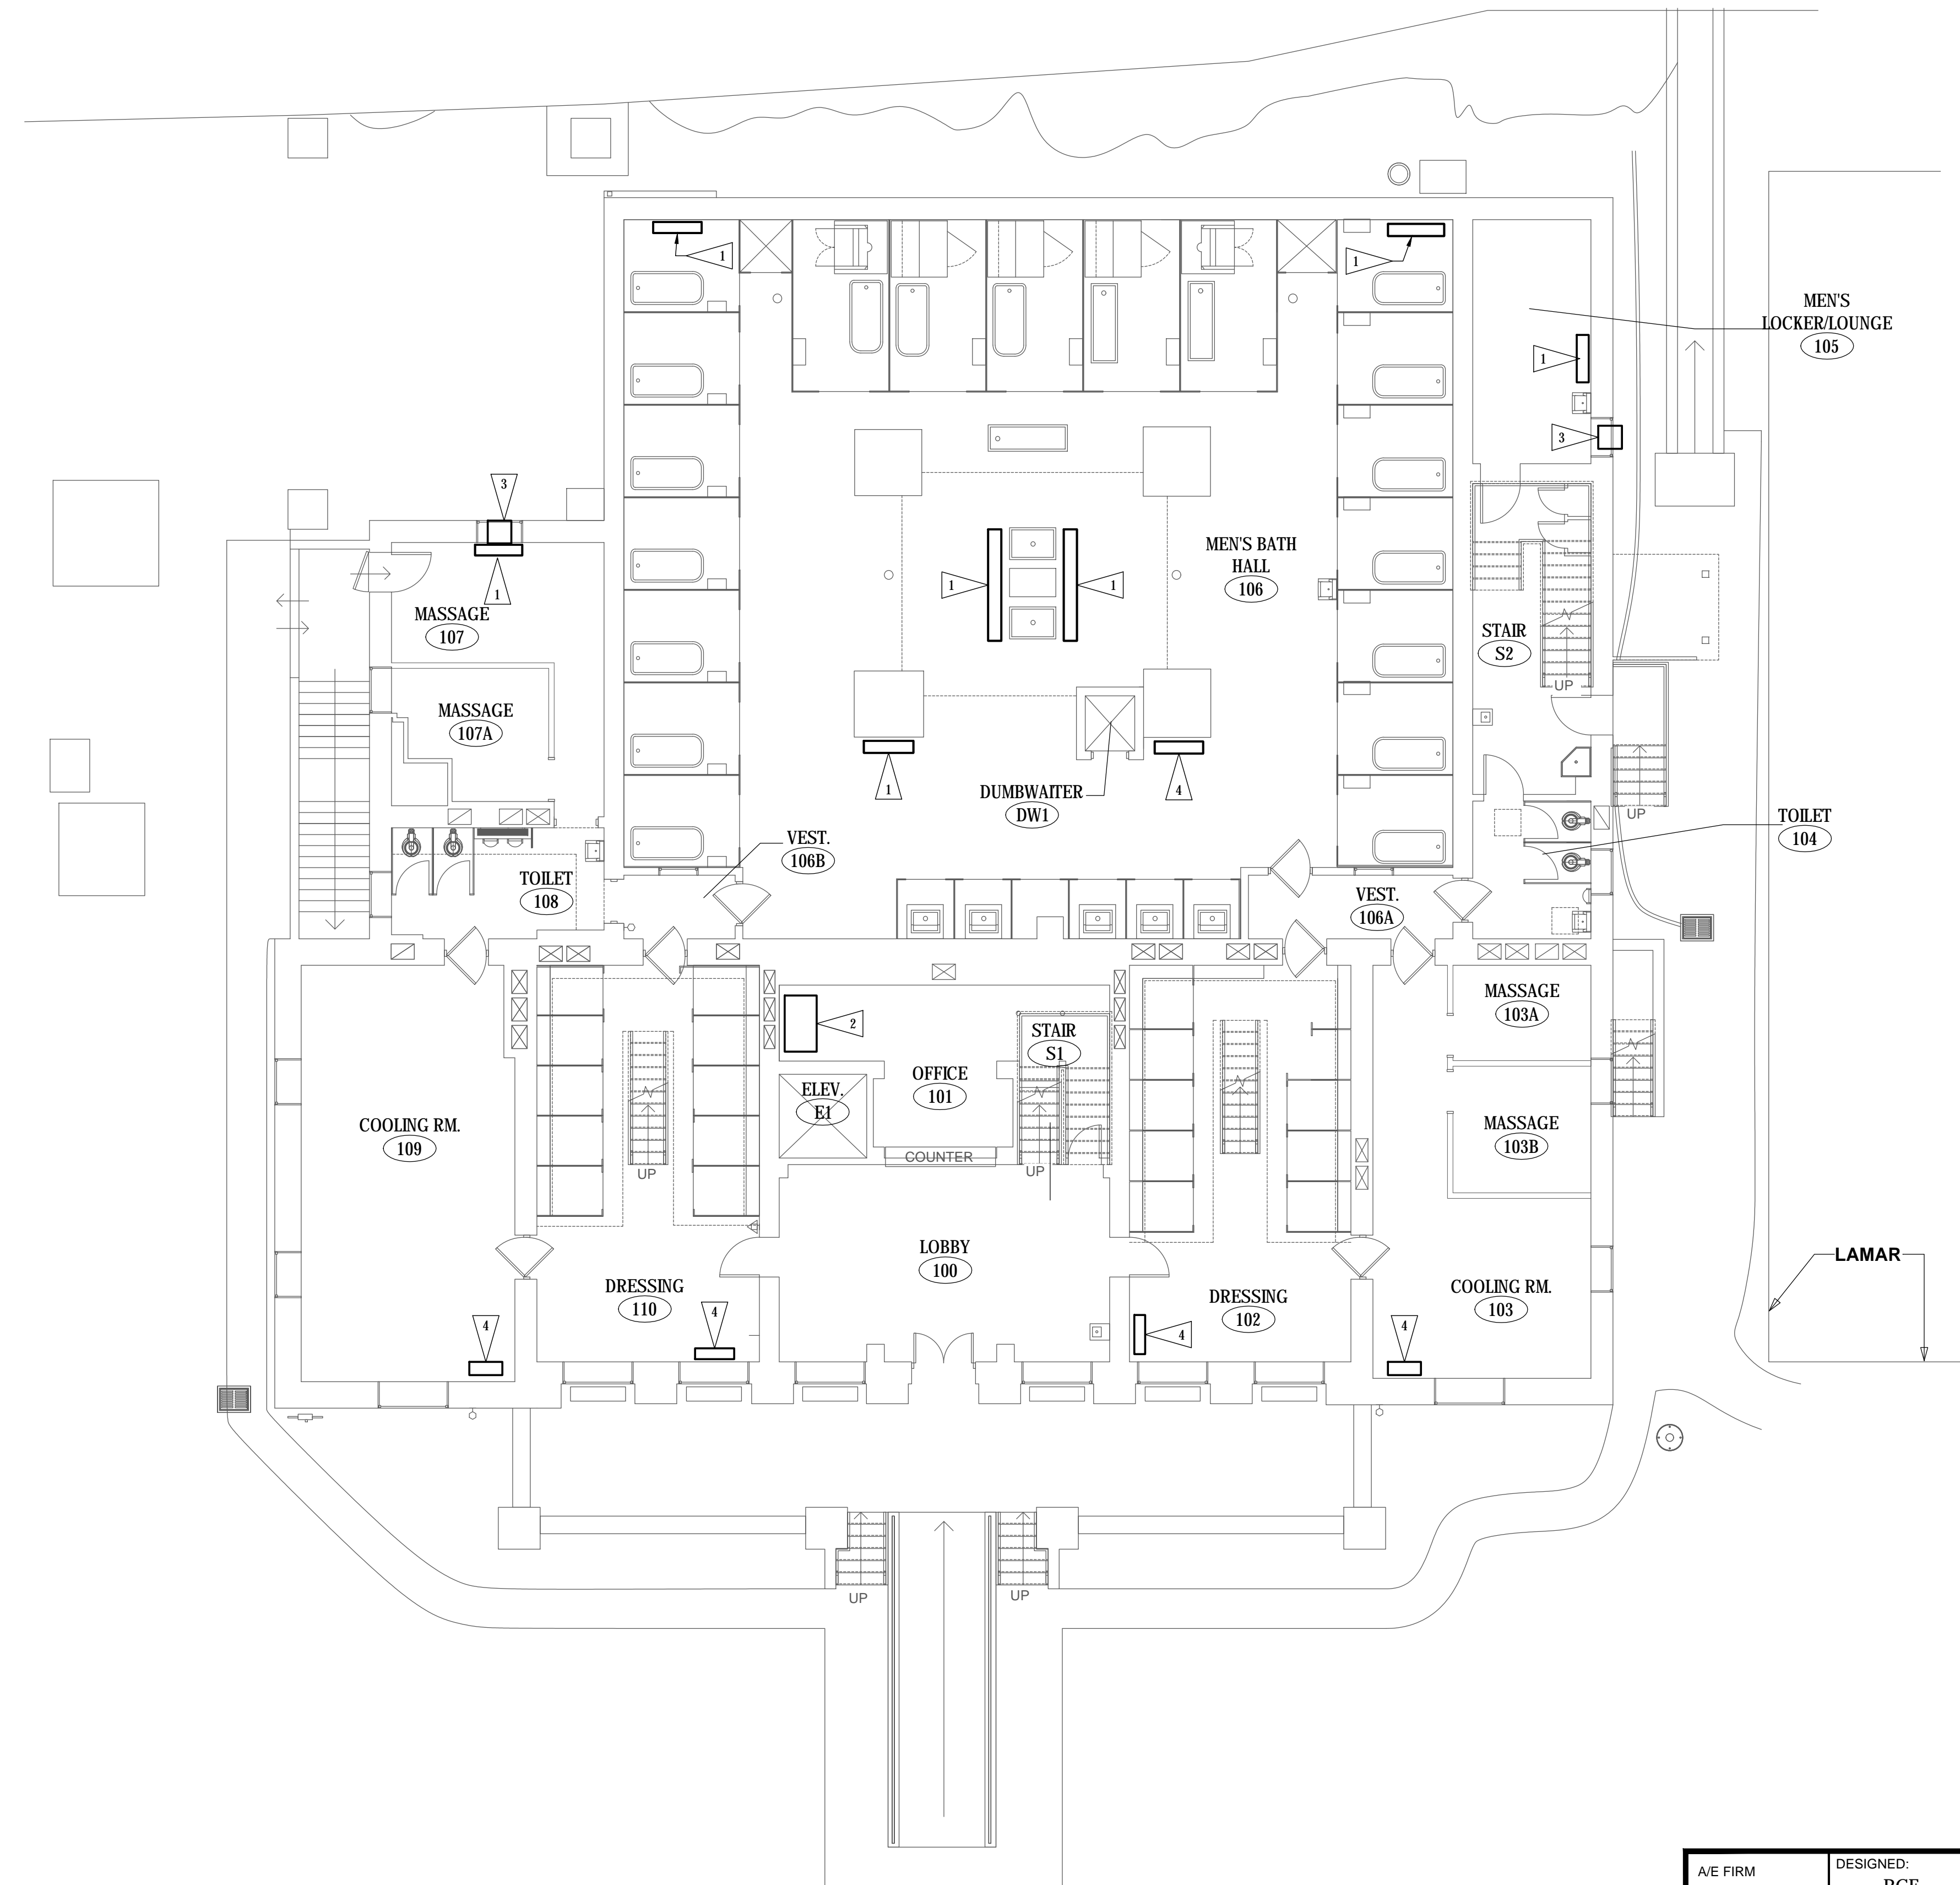

© COPYRIGHT 2024 AEF 20239955
 Permission to reproduce all or part of this drawing is hereby granted solely for the limited purpose of construction of this project or archiving. Unauthorized copying, disclosure or construction use without written permission of Alvine Engineering is prohibited by copyright law.
NOTE:
 DO NOT SCALE DRAWINGS. VERIFY ALL DIMENSIONS and clearances from ARCHITECTURAL, STRUCTURAL, shop and other appropriate drawing or at site. lay out and coordinate all work prior to installation to provide clearances required for operation, maintenance, and codes and verify non-interference with other work. DO NOT FABRICATE PRIOR TO VERIFICATION OF CLEARANCE FOR ALL TRADES. READ SPECIFICATIONS.

FINAL CONSTRUCTION DOCUMENTS

GROUND FLOOR PLAN - ELECTRICAL DEMOLITION
 SCALE: 1/8" = 1'-0"

A/E FIRM PRIME: KENNETH HAHN ARCHITECTS, INC. OMAHA, NE. SUBCONTRACTOR: ALVINE ENGINEERING OMAHA, NE.	DESIGNED: RCF	SUB SHEET NO. E1-2	TITLE OF SHEET	DRAWING NO. XXX/XXXX
	DRAWN BY: JAS		GROUND FLOOR PLAN - ELECTRICAL DEMOLITION BUCKSTAFF BATHHOUSE HVAC HOT SPRINGS NATIONAL PARK HOT SPRINGS, AK	PMIS NO. 177425
	TECH. REVIEW: GAN			SHEET
	DATE: 2/15/2024			38 OF 60