


FLAG NOTES

- 1 REMOVE EXISTING HEATING ONLY FAN COIL UNIT AND ASSOCIATED HEATING HOT WATER SUPPLY AND RETURN PIPING UP THROUGH FLOOR BELOW SERVING FAN COIL UNIT COMPLETE.
- 2 REMOVE EXISTING ABANDONED RADIATOR AND ANY ASSOCIATED PIPING DOWN THROUGH FLOOR.
- 3 EXISTING ABANDONED RADIATOR TO REMAIN.
- 4 REMOVE EXISTING FURNACE SHOWN DARK COMPLETE. REMOVE ANY ASSOCIATED SUPPLY AND RETURN DUCTWORK, CONDENSATE PIPING FROM UNIT DOWN TO BASEMENT, REFRIGERANT PIPING FROM UNIT DOWN TO BASEMENT LOCATED CONDENSING UNIT, AND ASSOCIATED CONTROLS. CONTRACTOR SHALL RECLAIM REFRIGERANT BEFORE REMOVING REFRIGERANT PIPING.
- 5 REMOVE EXISTING WINDOW AIR CONDITIONING UNIT AND TURN OVER TO GOVERNMENTS REPRESENTATIVE.
- 6 EXISTING OUTSIDE AIR INTAKE GRILLES SHALL REMAIN AND BE REUSED FOR INTAKE AIR.
- 7 EXISTING OUTSIDE AIR INTAKE GRILLES SHALL REMAIN AND BE REUSED FOR RELIEF AIR.
- 8 REMOVE EXISTING CONTROL THERMOSTAT SHOWN BOLD COMPLETE. REMOVE CONTROL AIR TUBING BACK INTO WALL AND ABANDON IN PLACE.

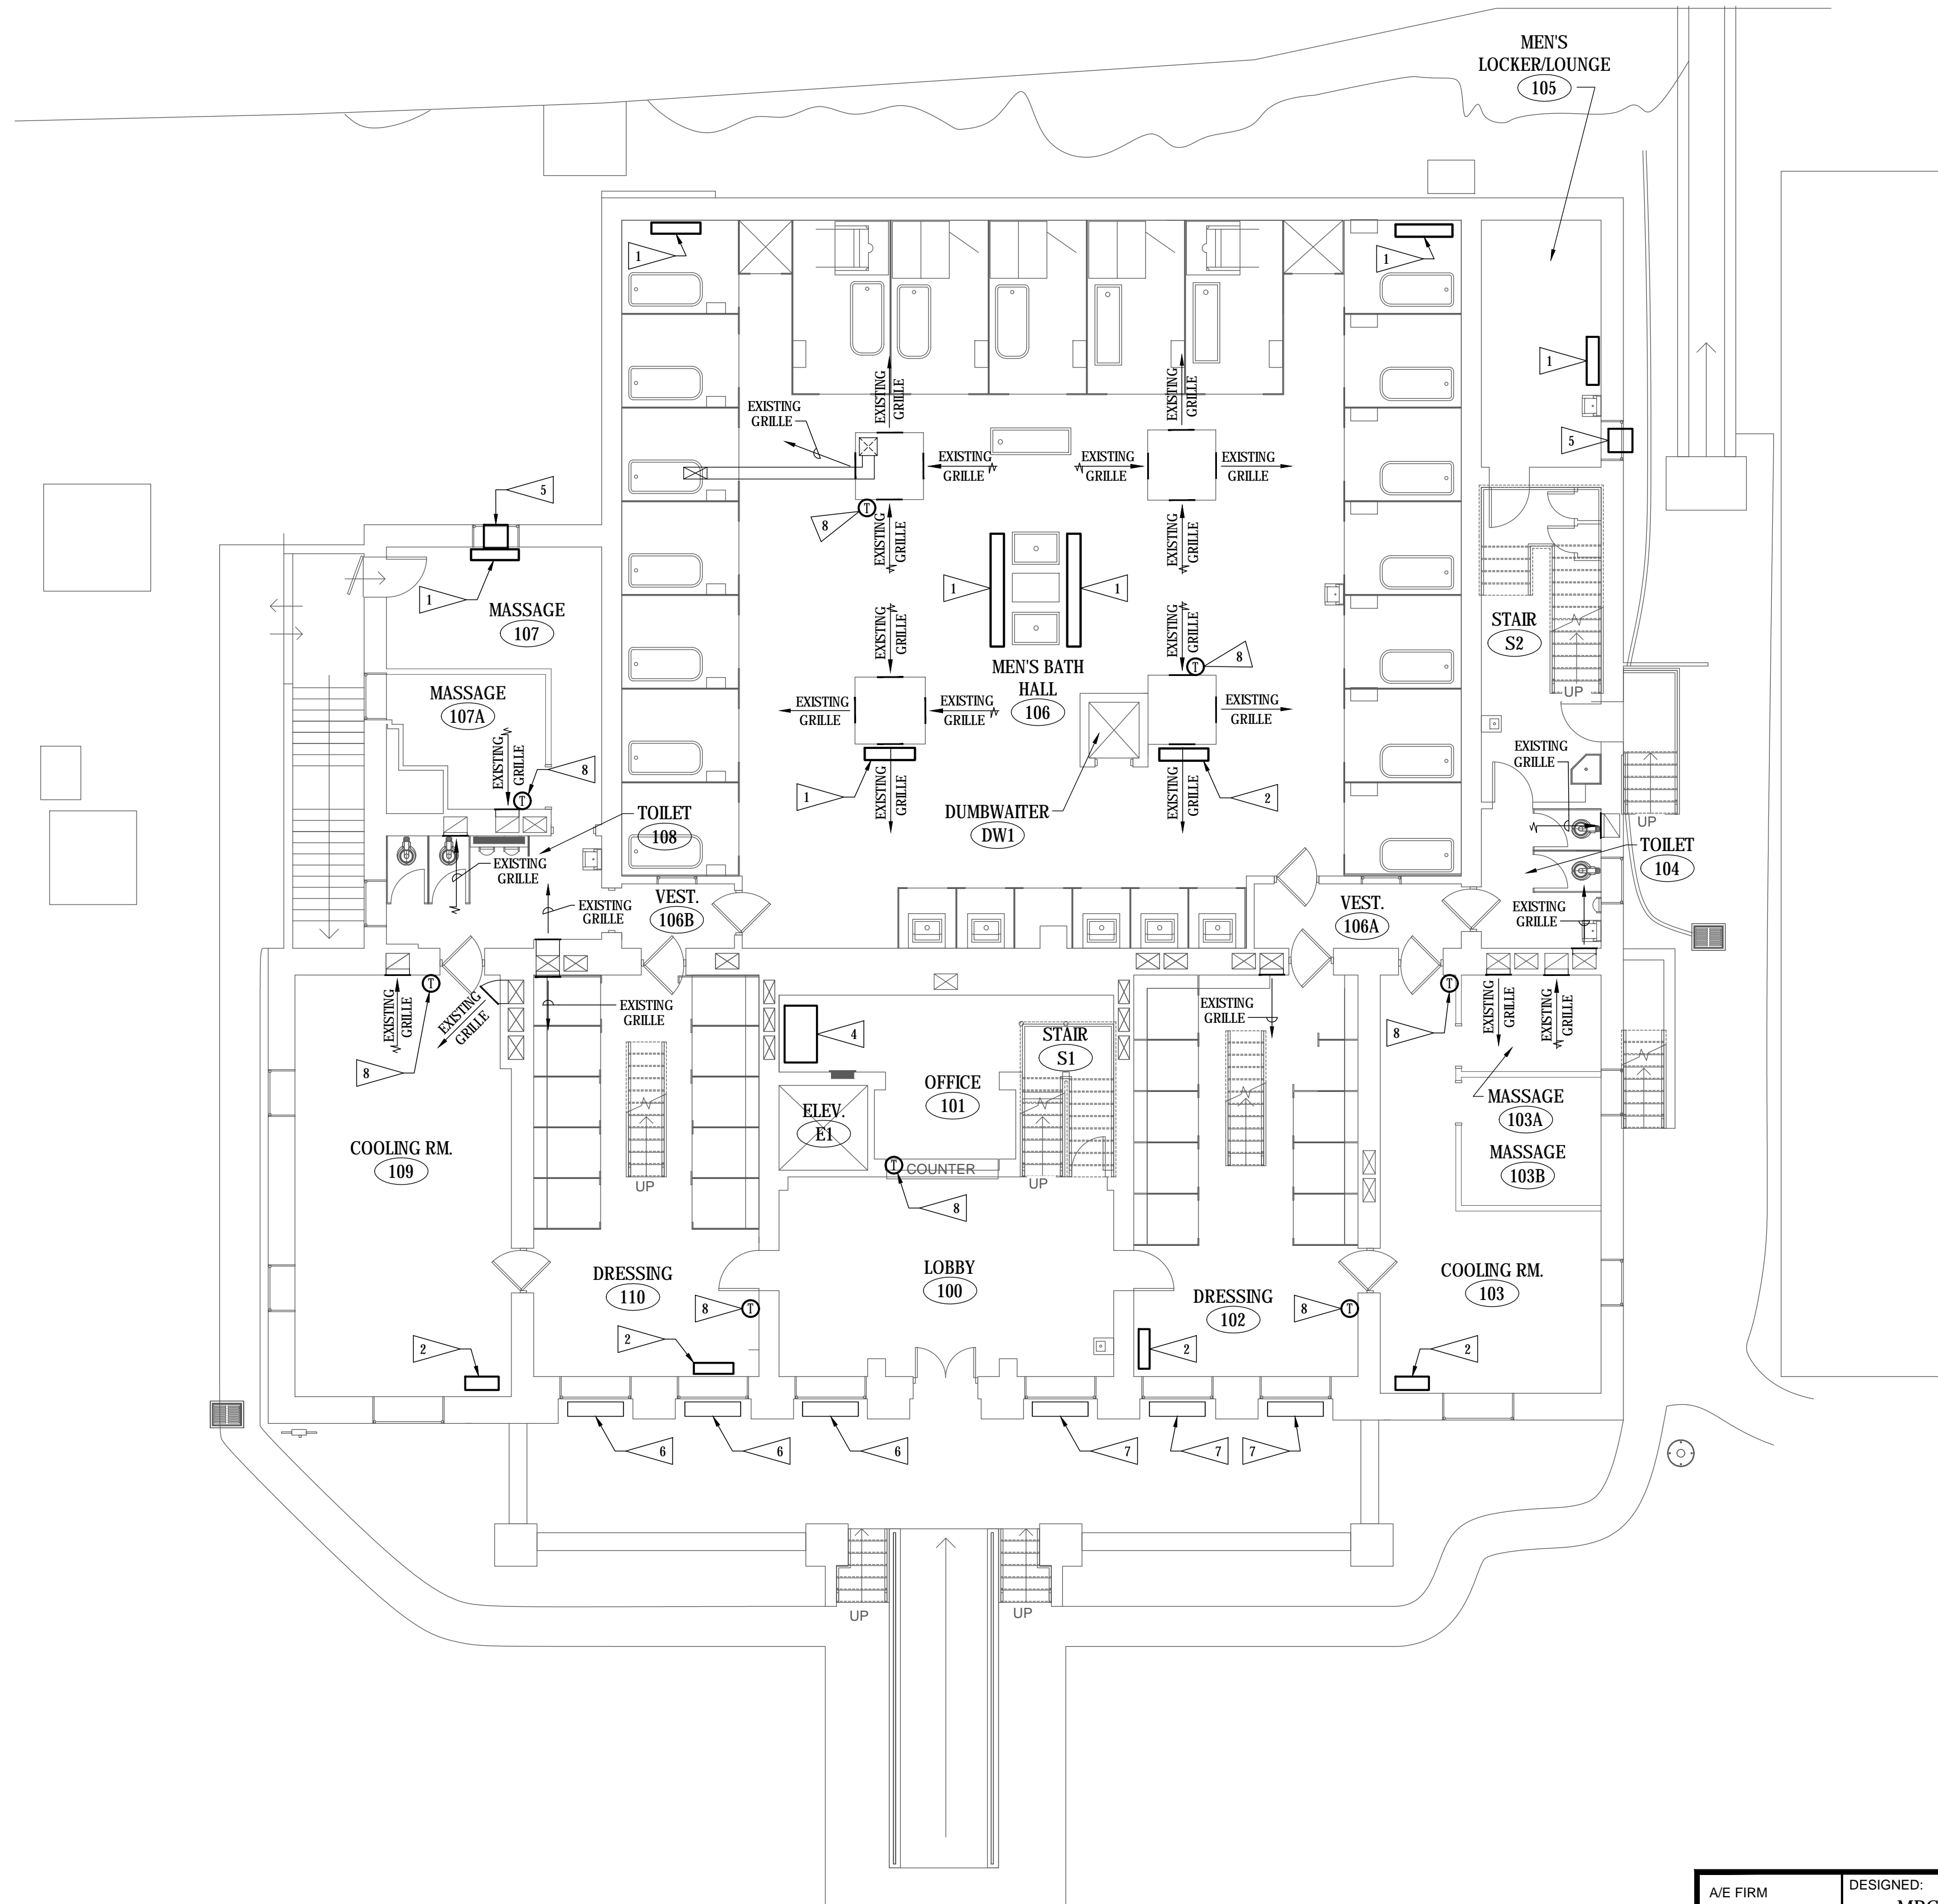

© COPYRIGHT 2024 AEF 20239955
 Permission to reproduce all or part of this drawing is hereby granted solely for the limited purpose of construction of this project or archiving. Unauthorized copying, disclosure or construction use without written permission of Alvine Engineering is prohibited by copyright law.
NOTE:
 DO NOT SCALE DRAWINGS. VERIFY ALL DIMENSIONS and clearances from ARCHITECTURAL, STRUCTURAL, shop and other appropriate drawing or at site. lay out and coordinate all work prior to installation to provide clearances required for operation, maintenance, and codes and verify non-interference with other work. DO NOT FABRICATE PRIOR TO VERIFICATION OF CLEARANCE FOR ALL TRADES. READ SPECIFICATIONS.

FINAL CONSTRUCTION DOCUMENTS

GROUND FLOOR PLAN - MECHANICAL DEMOLITION
 SCALE: 1/8" = 1'-0"

A/E FIRM PRIME: KENNETH HAHN ARCHITECTS, INC. OMAHA, NE. SUBCONTRACTOR: ALVINE ENGINEERING OMAHA, NE.	DESIGNED: MRG DRAWN BY: MRG TECH. REVIEW: BAH DATE: 2/15/2024	SUB SHEET NO. <div style="font-size: 2em; font-weight: bold; text-align: center;">M1-2</div>	TITLE OF SHEET <div style="font-size: 1.2em; font-weight: bold;">GROUND FLOOR PLAN - MECHANICAL DEMOLITION</div> BUCKSTAFF BATHHOUSE HVAC HOT SPRINGS NATIONAL PARK HOT SPRINGS, AK	DRAWING NO. XXX/XXXX PMIS NO. 177425 SHEET 15 OF 60
---	--	---	--	--