


**FLAG NOTES**

- 1 REMOVE EXISTING HEATING ONLY FAN COIL UNIT AND ASSOCIATED HEATING HOT WATER SUPPLY AND RETURN PIPING UP THROUGH FLOOR BELOW SERVING FAN COIL UNIT COMPLETE.
- 2 REMOVE EXISTING ABANDONED RADIATOR AND ASSOCIATED PIPING.
- 3 REMOVE EXISTING WINDOW AIR CONDITIONING UNIT AND TURN OVER TO GOVERNMENTS REPRESENTATIVE.
- 4 REMOVE WALL EXHAUST FAN, EXHAUST DUCT AND EXTERIOR EXHAUST HOOD SHOWN BOLD COMPLETE. PATCH WALL TO MATCH ADJACENT SURFACES.
- 5 REMOVE EXISTING CONTROL THERMOSTAT SHOWN BOLD COMPLETE. REMOVE CONTROL AIR TUBING BACK INTO WALL AND ABANDON IN PLACE.

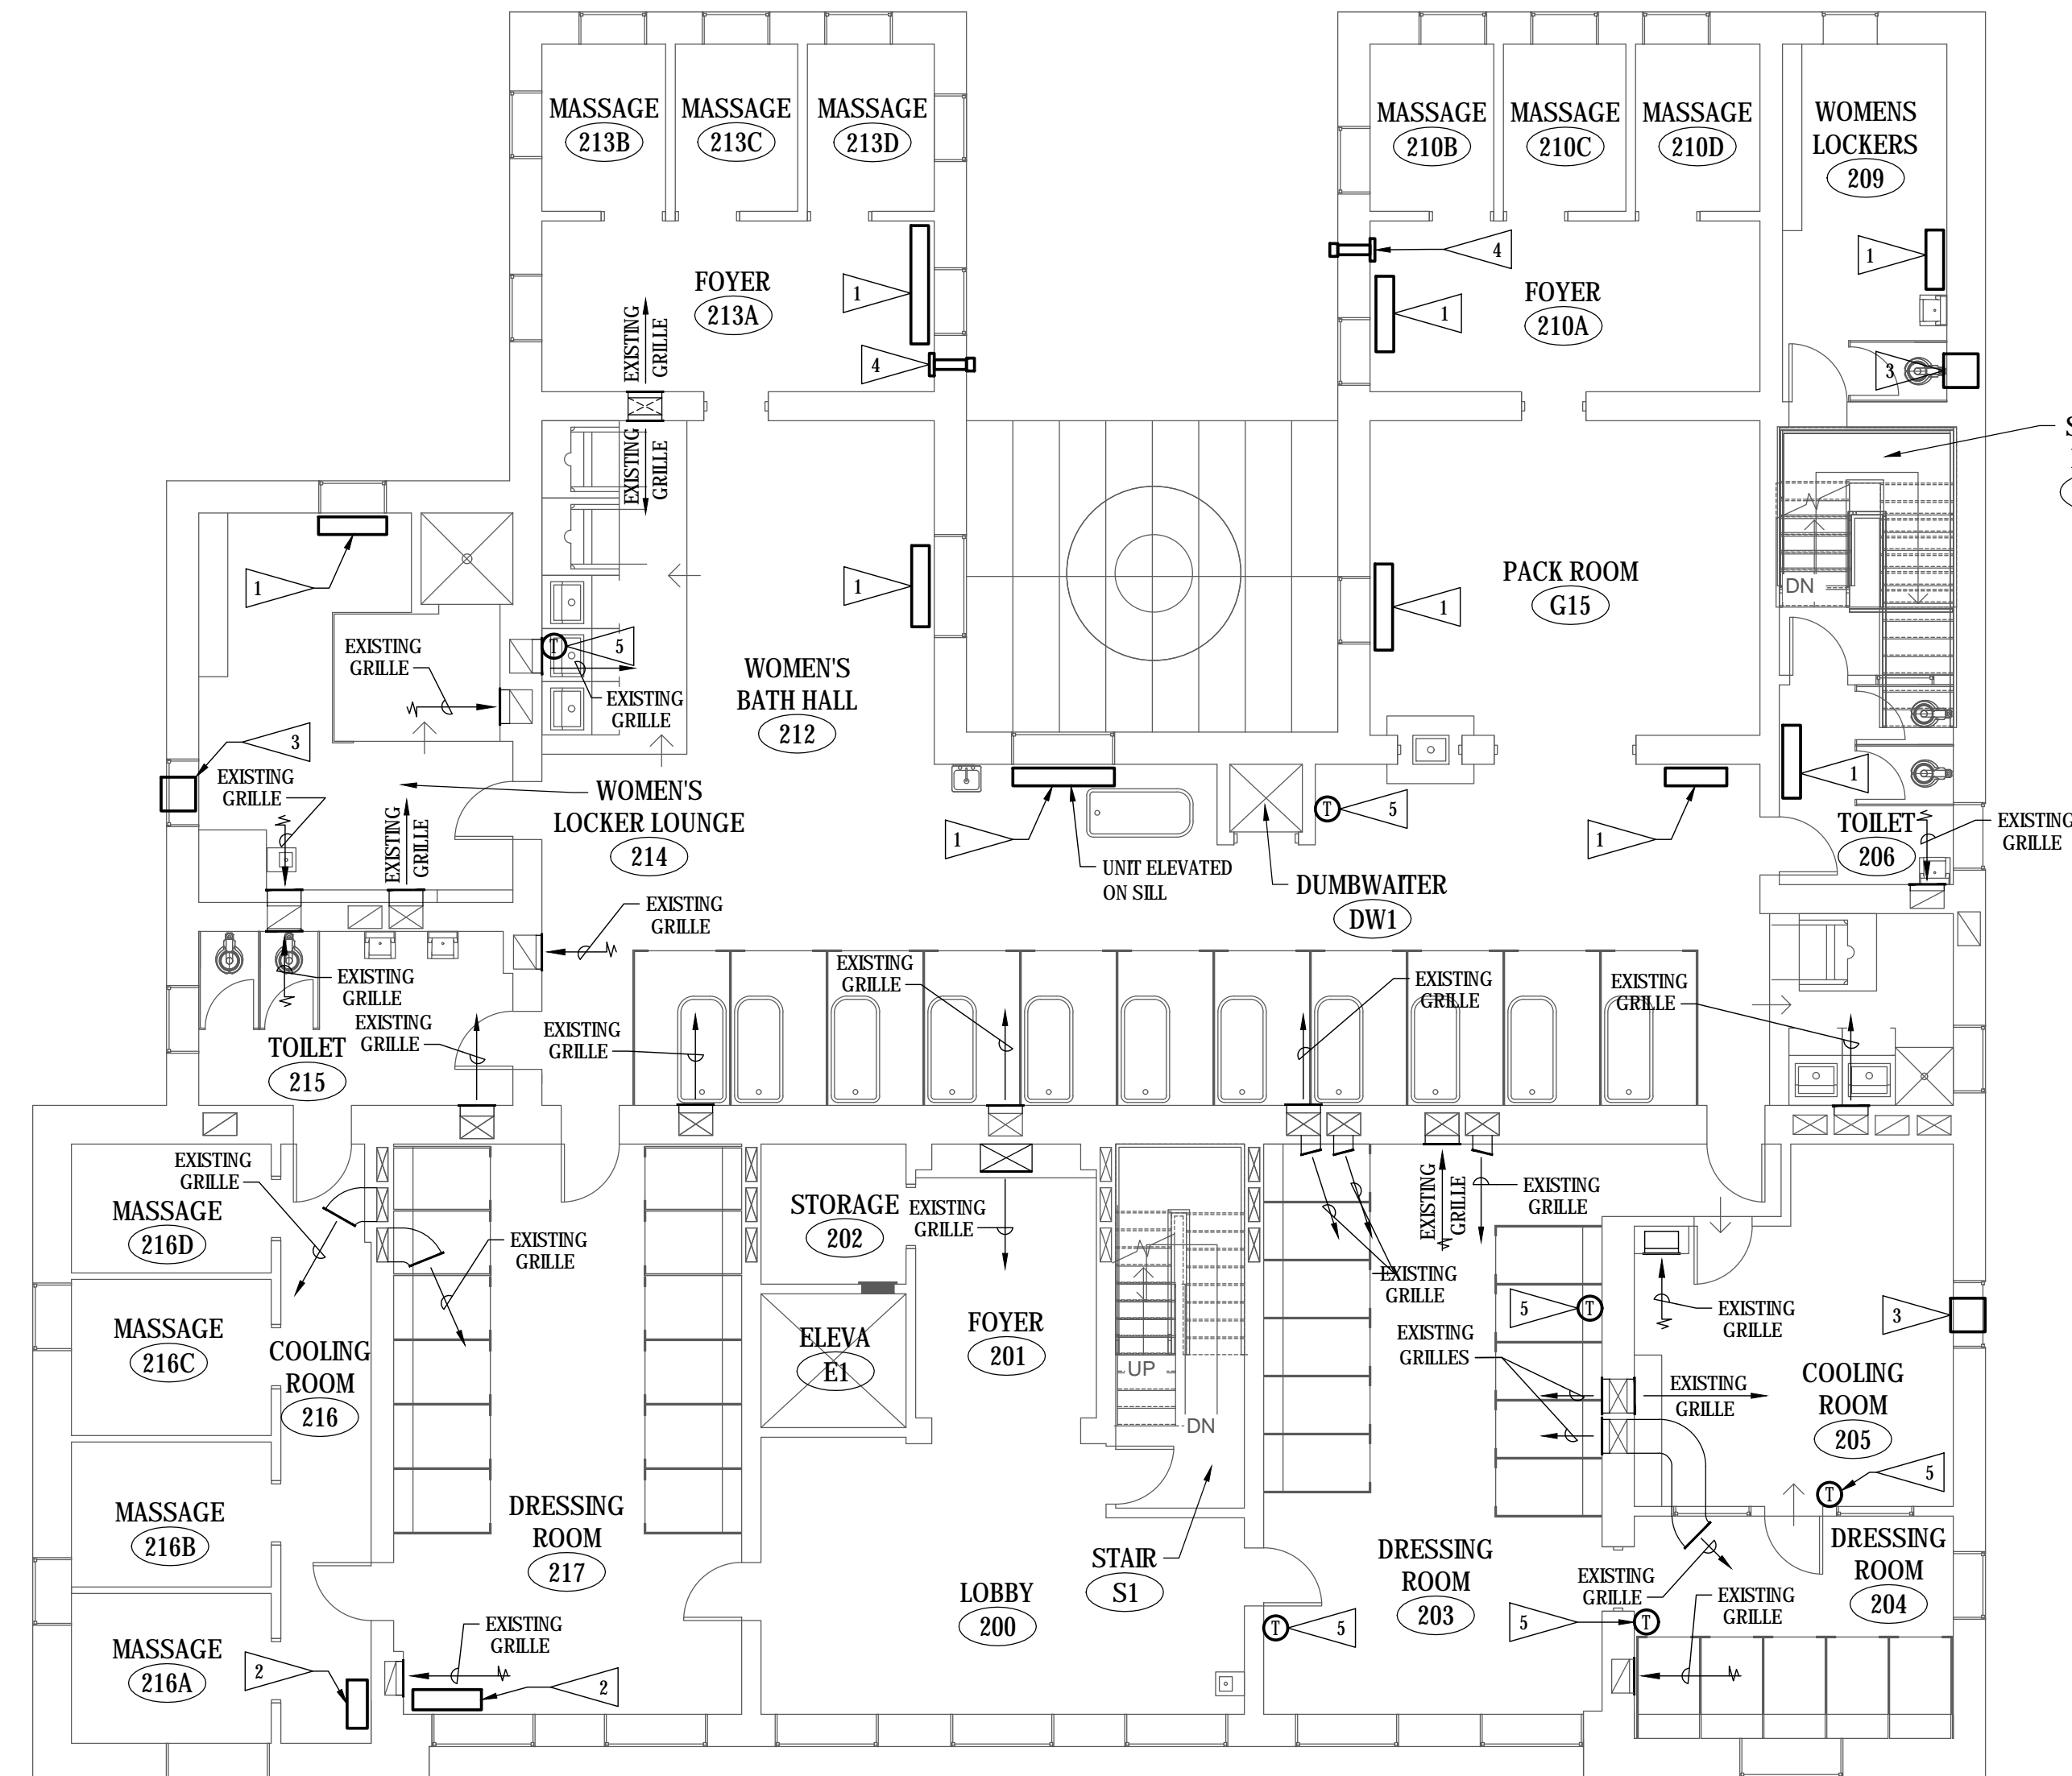

© COPYRIGHT 2024 A/E 20239955  
 Permission to reproduce all or part of this drawing is hereby granted solely for the limited purpose of construction of this project or archiving. Unauthorized copying, disclosure or construction use without written permission of Alvine Engineering is prohibited by copyright law.  
**NOTE:**  
 DO NOT SCALE DRAWINGS. VERIFY ALL DIMENSIONS and clearances from ARCHITECTURAL, STRUCTURAL, shop and other appropriate drawing or at site. lay out and coordinate all work prior to installation to provide clearances required for operation, maintenance, and codes and verify non-interference with other work. DO NOT FABRICATE PRIOR TO VERIFICATION OF CLEARANCE FOR ALL TRADES. READ SPECIFICATIONS.

FINAL CONSTRUCTION DOCUMENTS

**SECOND FLOOR PLAN - MECHANICAL DEMOLITION**  
 SCALE: 1/8" = 1'-0"

A/E FIRM PRIME: KENNETH HAHN ARCHITECTS, INC. OMAHA, NE. SUBCONTRACTOR: ALVINE ENGINEERING OMAHA, NE.	DESIGNED: MRG	M1-3	TITLE OF SHEET	DRAWING NO.
	DRAWN BY: MRG		<b>SECOND FLOOR PLAN -                  MECHANICAL DEMOLITION</b> BUCKSTAFF BATHHOUSE HVAC HOT SPRINGS NATIONAL PARK HOT SPRINGS, AK	XXX/XXX
	TECH. REVIEW: BAH			PMIS NO. 177425
	DATE: 2/15/2024			SHEET 16 OF 60

February 16, 2024 7:23am M: L.dwg impregnoy