

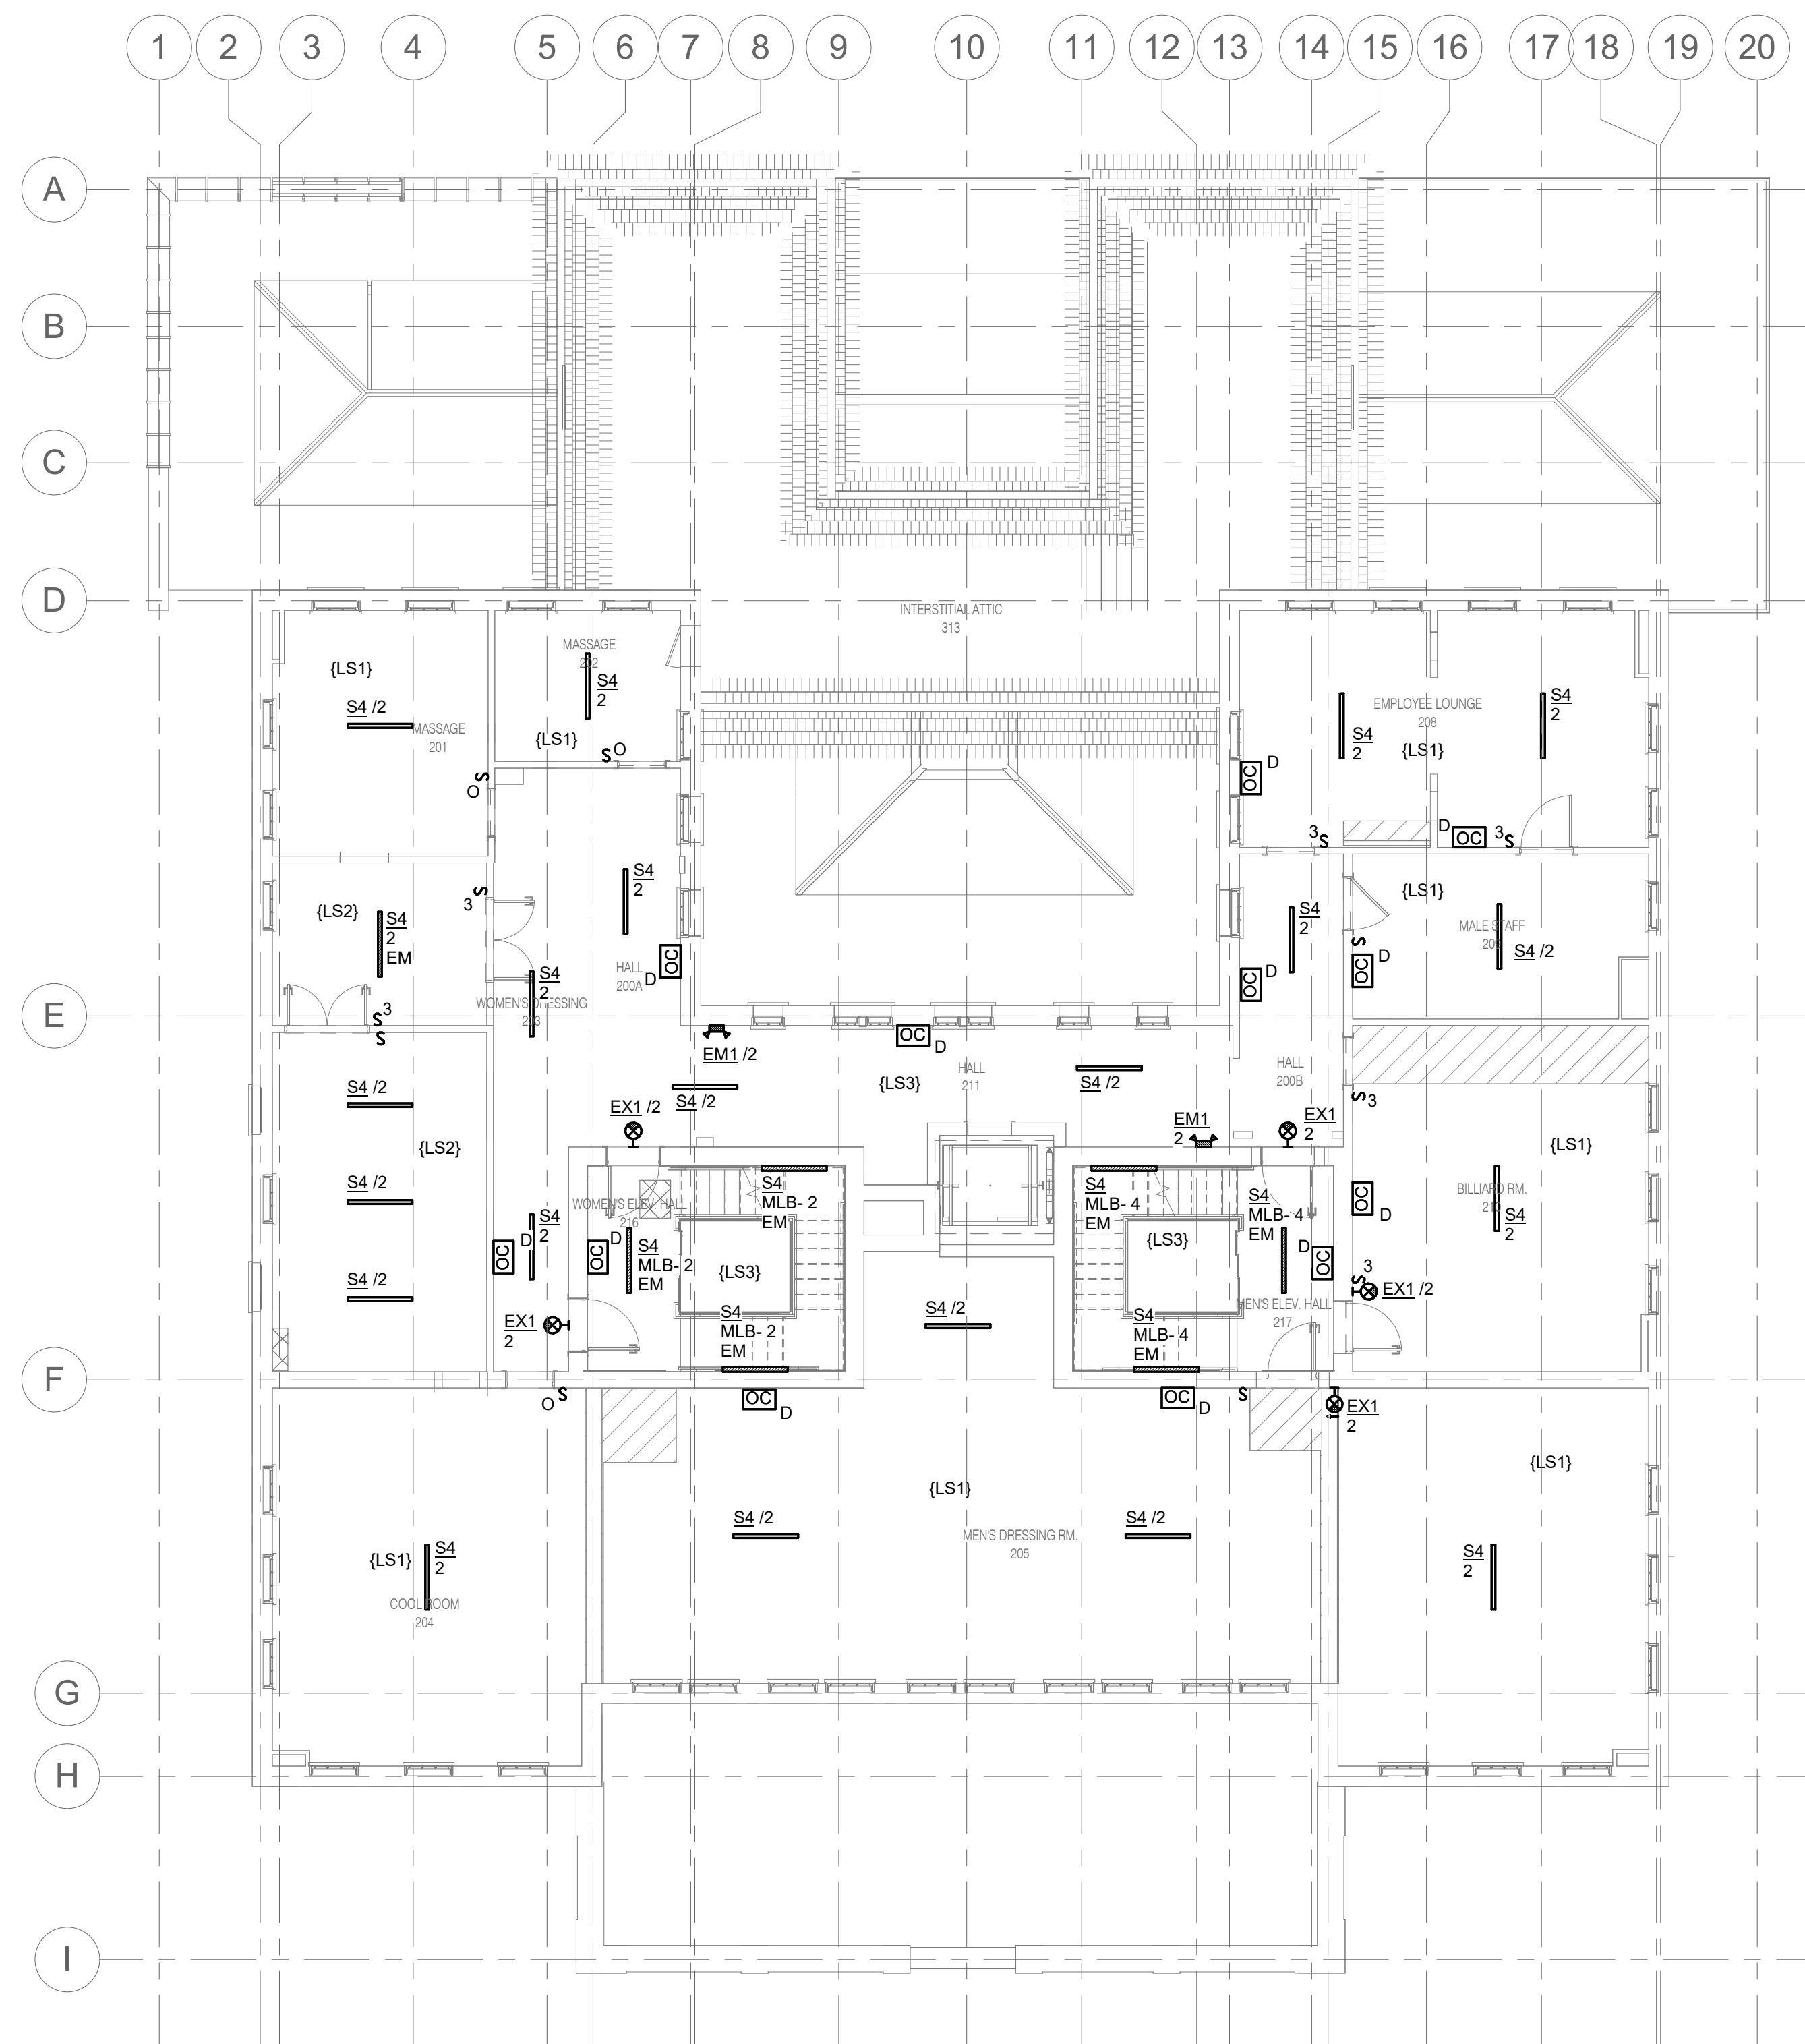


SHEET NOTES:

1. REFER TO SHEET E0.0 AND E0.1 FOR GENERAL NOTES AND SYMBOLS.
2. ALL LIGHTING CIRCUITS ON THIS SHEET SHALL BE CONNECTED TO PANEL ML2, UNLESS NOTED OTHERWISE.

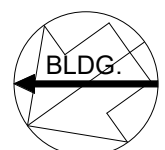

1
EL1.2 SECOND FLOOR LIGHTING PLAN
 1/8" = 1'-0"

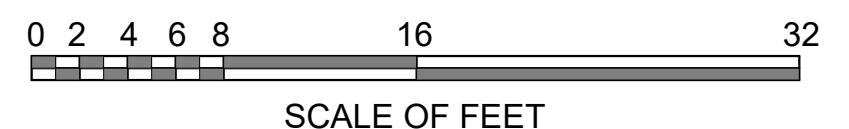

10.27.2023

A/E FIRMS PRIME/ARCH: STRATA ARCHITECTURE 1703 OAK STREET, SUITE 100 KANSAS CITY, MO T: 816.474.0900 WEBSITE: IMEG CORP. 1400 BALTIMORE STREET, SUITE 300 KANSAS CITY, MO T: 816.842.8437	DESIGNED: PIP	SUB SHEET NO. 01 EL1.2	TITLE OF SHEET MAURICE BATHHOUSE SECOND FLOOR LIGHTING PLAN REHABILITATE BATHHOUSES HOT SPRINGS NATIONAL PARK	DRAWING NO. 626 180065
	CADD: WMM			PMIS/PKG NO. 318674
	TECH. REVIEW: PIP			SHEET 173 OF 286
	DATE: 10.27.2023			

10/27/2023 11:34:01 PM