



SHEET NOTES:

- ROUTING OF TERMINAL EQUIPMENT, DUCTWORK AND PIPING SHALL BE VERY CAREFULLY COORDINATED WITH EXISTING CONDITIONS, PRESERVATION ZONES AND HISTORIC NATURE OF BUILDING TO CONFORM WITH THE SECRETARY OF THE INTERIOR'S REHABILITATION REQUIREMENTS AND PRESERVATION BRIEFS RELATED TO MEP DESIGN AND INSTALLATION.

KEYNOTES: #

- PEDISTAL MOUNTED FINNED TUBE RADIATOR COVER WITH TWO (2) 3-ELEMENT SECTIONS FED FROM THE NORTH & SOUTH ENDS WITH RETURN PIPING ROUTED IN COVER.
- 3/4\"/>

1 THIRD FLOOR MECHANICAL PIPING PLAN
MP1.3 1/8" = 1'-0"

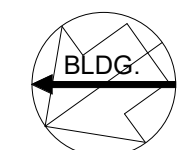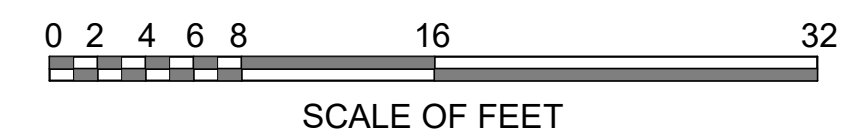

10.27.2023

A/E FIRMS STRATA ARCHITECTURE 1703 OAK STREET, SUITE 100 KANSAS CITY, MO T: 816.474.0900 MEPE/ENG: IMEG CORP. 1420 BALTIMORE STREET, SUITE 300 KANSAS CITY, MO T: 816.842.8437	DESIGNED:	SUB SHEET NO.	TITLE OF SHEET	DRAWING NO.
	CADD:	01 MP1.3	THIRD FLOOR MECHANICAL PIPING PLAN	626 180065
	TECH. REVIEW:			PMIS/PKG NO.
	DATE: 10.27.2023			REHABILITATE BATHHOUSES HOT SPRINGS NATIONAL PARK

10/27/2023 1:14:48 PM