

LITTLE ROCK, ARKANSAS

POLSHEK PARTNERSHIP LLP
320 West 13th Street
New York, New York 10014
212.807.7171

POLK STANLEY YEARY ARCHITECTS, Ltd
700 South Schiller Street
Little Rock Arkansas 72201
501 378 0878

WITSELL EVANS RASCO
901 West Third Street
Little Rock Arkansas 72201
501 374.5300

WOODS CARADINE ARCHITECTS
2200 South Main Street
Little Rock, Arkansas 72206
501 374 4060

HARGREAVES ASSOCIATES
118 Magazine Street
Cambridge Massachusetts 02139
617 661 0070

LANDSCAPE ARCHITECTURE, Inc.
2300 Cottdale Lane Suite 202
Little Rock Arkansas 72202
501 374.5610

LESLIE E. ROBERTSON ASSOC RLLP
30 Broad Street 47th Floor
New York, New York 10004
212 750.9000

FLACK + KURTZ Inc.
475 Fifth Avenue
New York, New York 10017
212.532.9600

CROMWELL ARCHITECTS ENGINEERS
101 South Spring Street
Little Rock, Arkansas 72201
501 372.2900

R. A. HEINTGES ARCHITECTS
126 Fifth Avenue, 9th Floor
New York, New York 10011
212 652 2966

STATE OF
ARKANSAS
REGISTERED
PROFESSIONAL
ENGINEER
No 9395
12/19/02

100% Construction Documents	09/27/02
90% Progress Printing	08/30/02
100% Design Development	03/01/02
Issue	Date

Scale $1/8" = 1'-0"$


Date _____

Title **MUSEUM**

MUSEUM
 UPPER LEVEL
 MECHANICAL
 PARTIAL PLAN


Sheet No

M304a

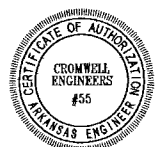

178

1	BEFORE INSTALLATION OF ANY DUCTWORK, THE CONTRACTOR SHALL COORDINATE ALL PLUMBING FIRE PROTECTION AND DUCTWORK ROUTING	5	VERIFY ROOM SENSOR (THERMOSTAT) LOCATIONS WITH THE CONSTRUCTION MANAGER.
2	REFER TO THE ARCHITECTURAL REFLECTED CEILING PLANS AND ELEVATIONS FOR EXACT LOCATION OF AIR DEVICES AND LOUVERS	6	COORDINATE LOCATION OF CONDUITS IN BLOCK WALLS FOR ROOM SENSORS WITH CONSTRUCTION MANAGER. SURFACE MOUNTED CONDUIT IS NOT ALLOWED
3	ALL SUPPLY AND RETURN BRANCHES TO AND FROM AIR DEVICES IN AREAS WITH LAY IN CEILING SHALL BE PROVIDED WITH A VOLUME DAMPER AT THE MAIN DUCT	7	PROVIDE DYNAMIC FIRE DAMPERS OF PROPER RATING AT ALL DUCT PENETRATIONS THROUGH RAISED WALLS
4	PROVIDE 5'-0" MAXIMUM FLEX DUCT AT AIR DEVICES	8	PROVIDE ACCESS DOORS IN DRYWALL CEILINGS AS REQUIRED TO PROVIDE ACCESS FOR MAINTENANCE TO VALVES, DAMPERS, FIRE DAMPERS ETC

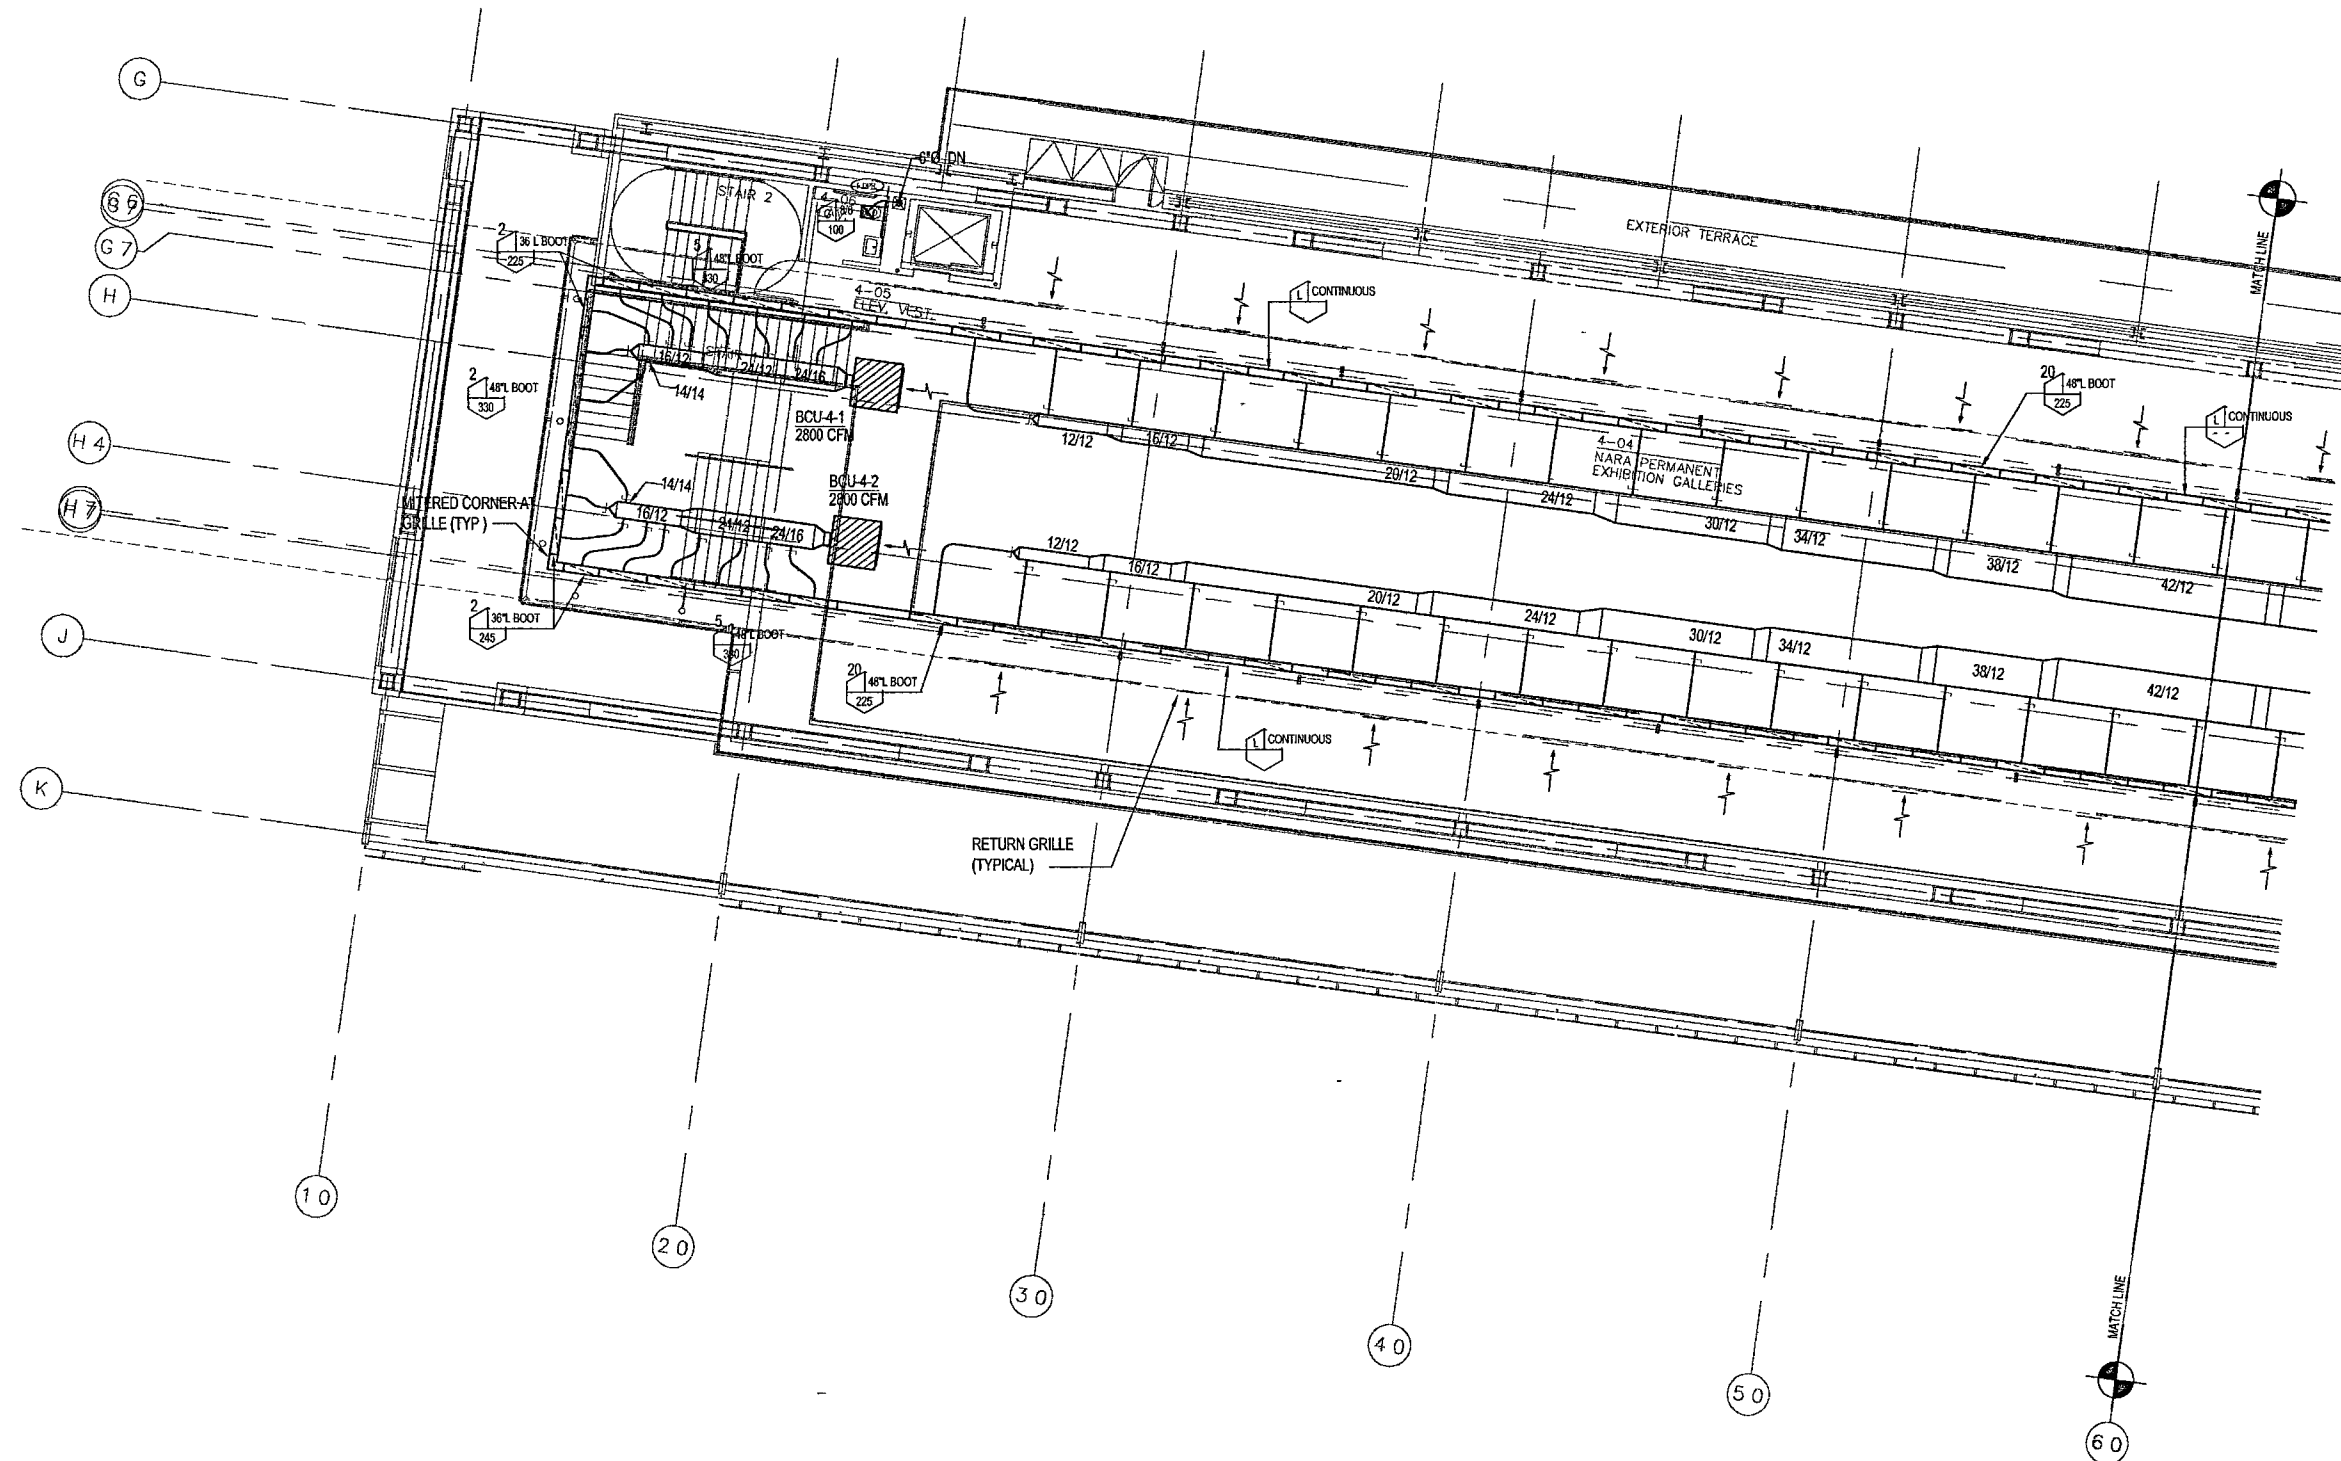

1 MUSEUM - UPPER LEVEL MECHANICAL PLAN

