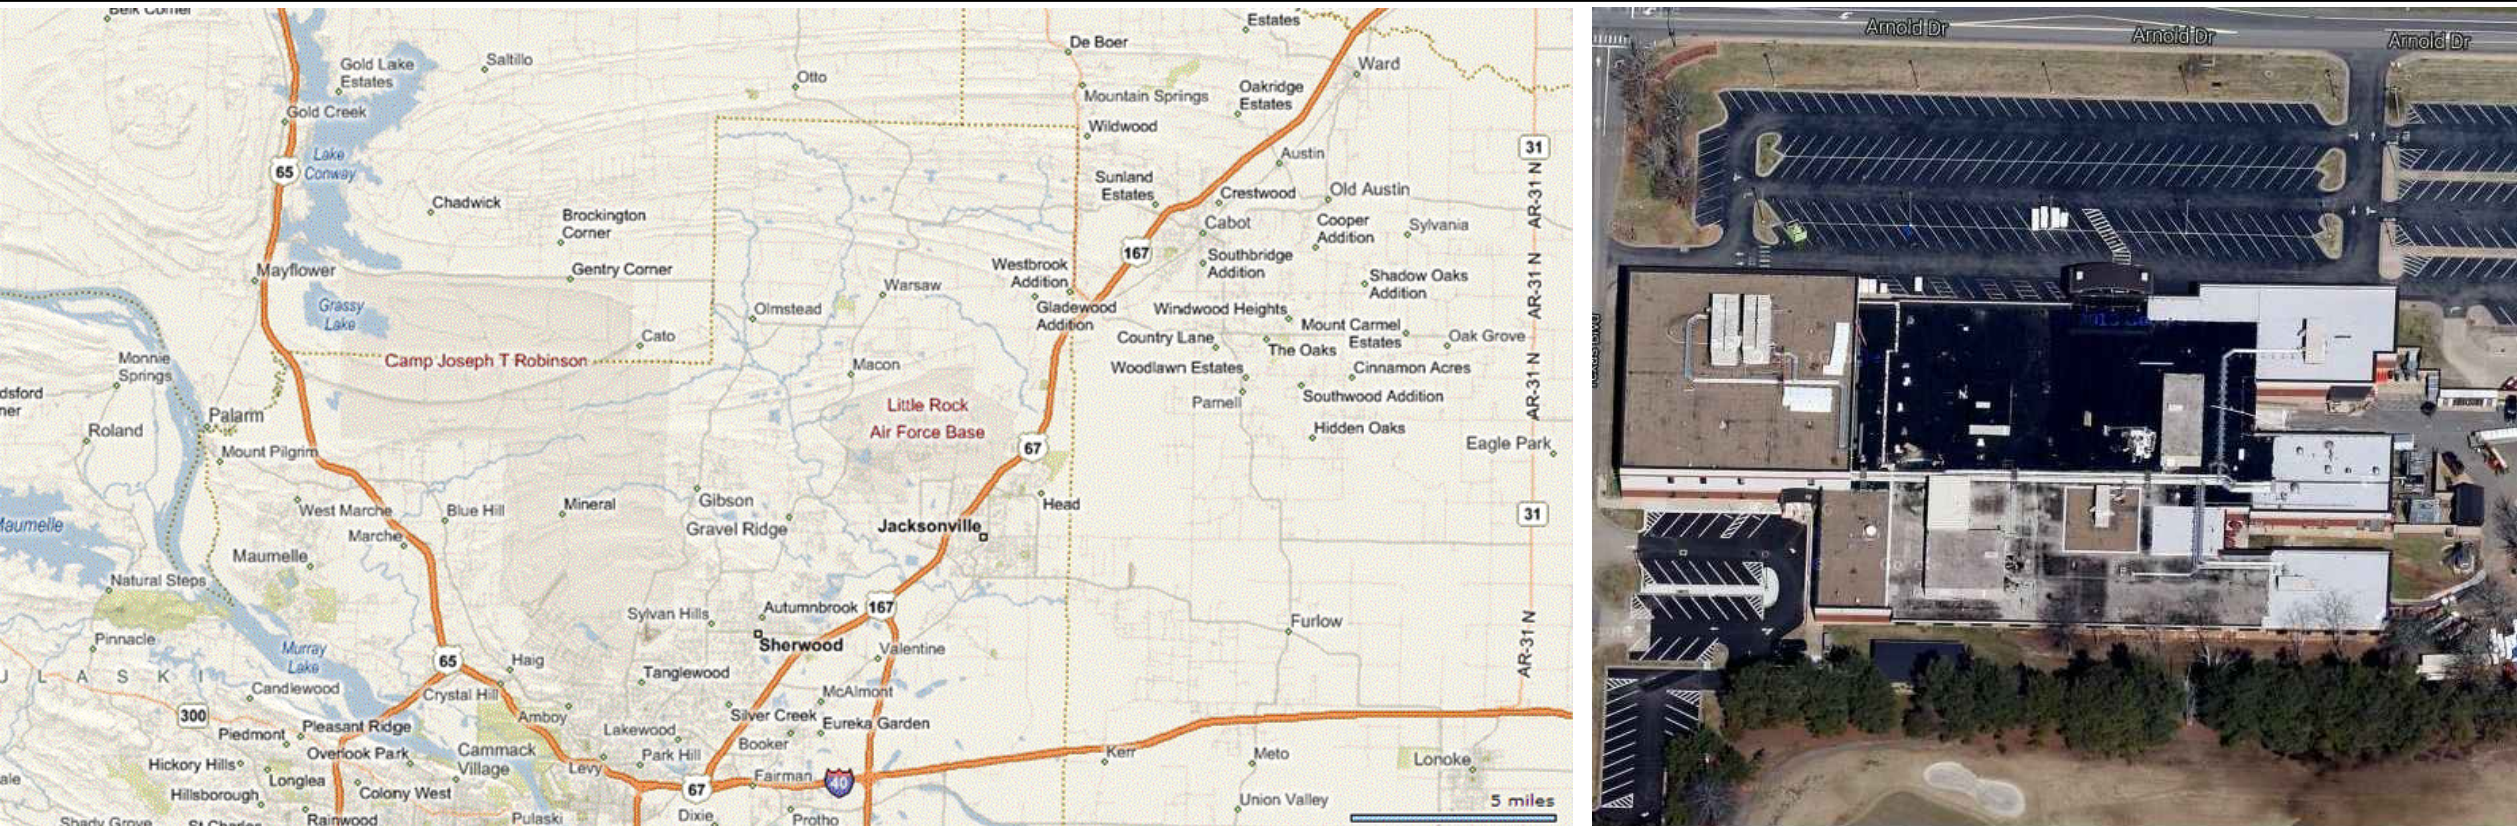


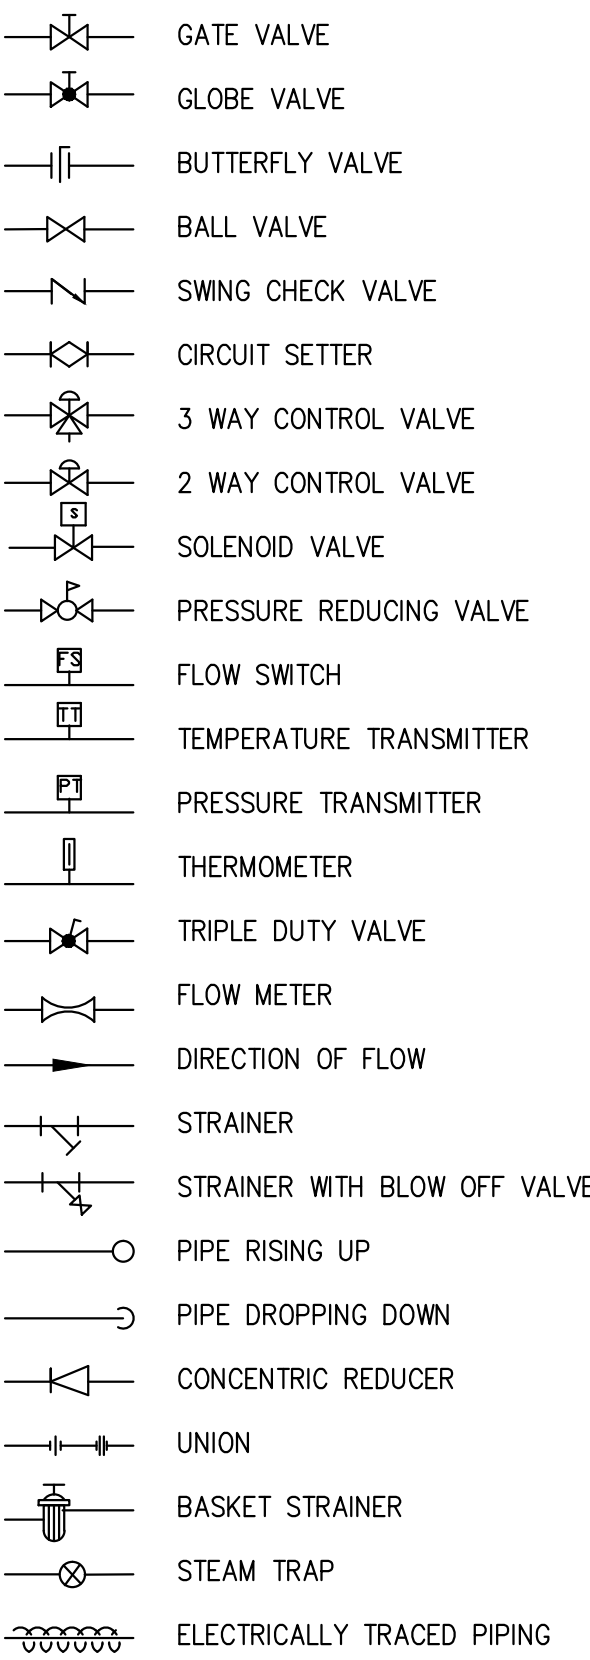
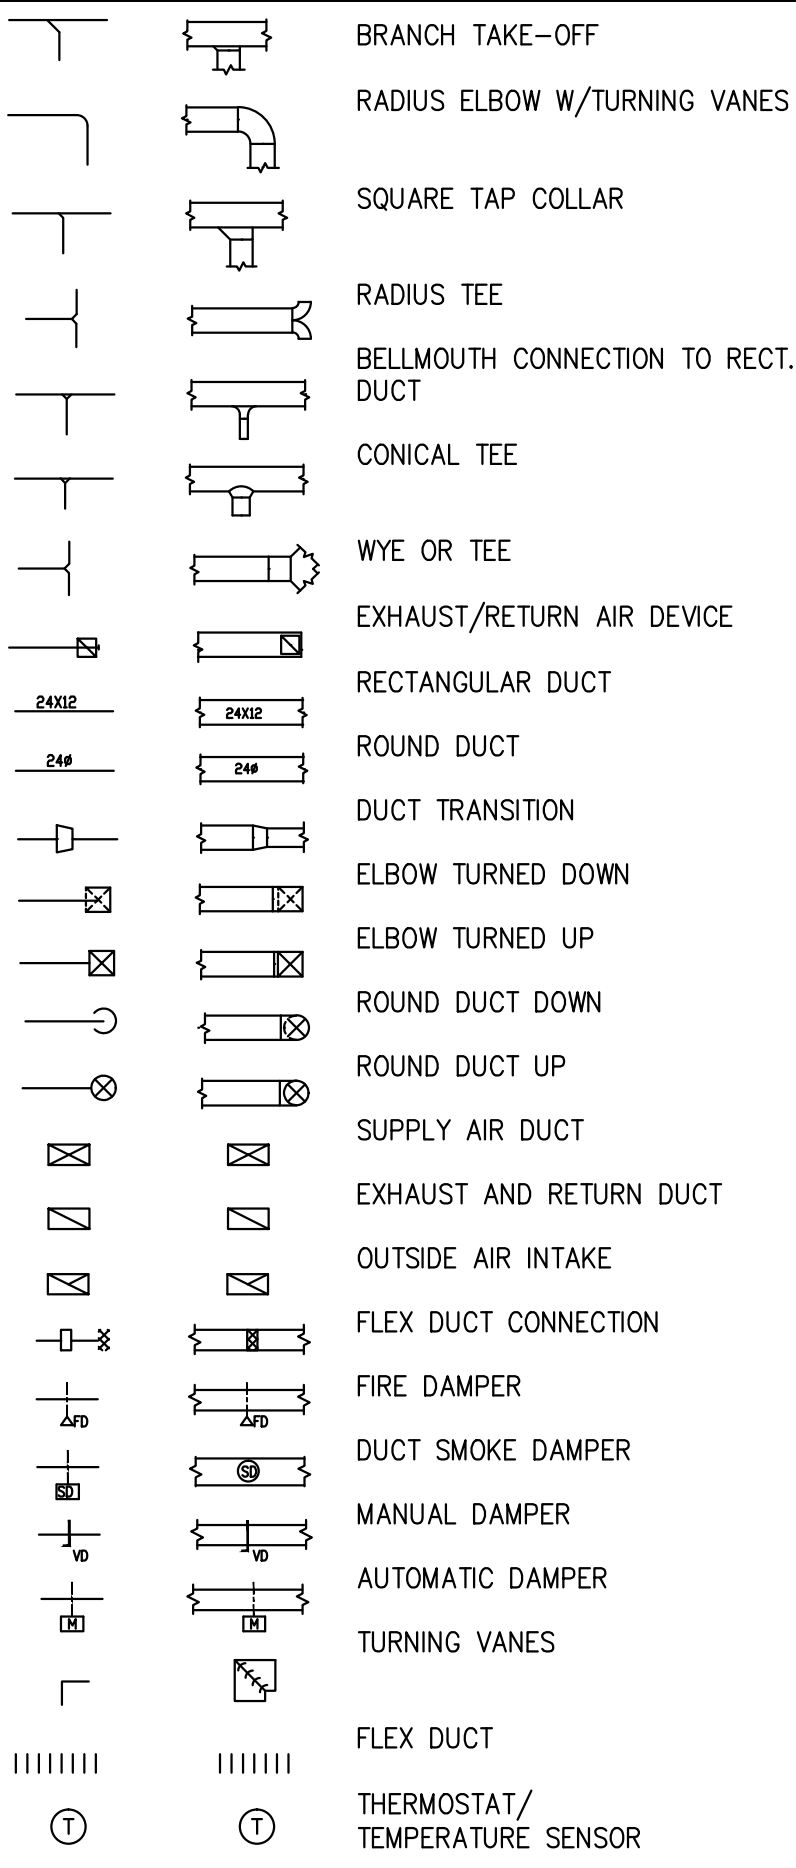
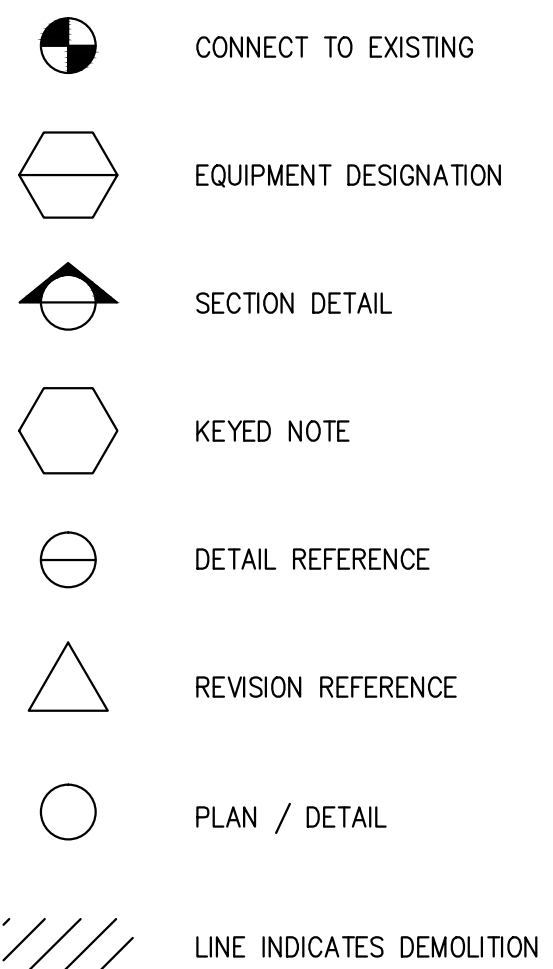
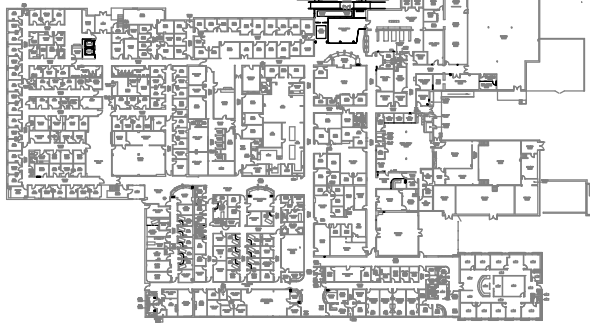
 


REPAIR OF MECHANICAL BUILDING INFRASTRUCTURE SYSTEM
19TH. MEDICAL GROUP
LITTLE ROCK AFB



JACKSONVILLE, AR
100% DESIGN DRAWINGS ~ 2/21/2014

SHEET INDEX						LOCATION MAP	
PG#	PAGE	PAGE TITLE	PG#	PAGE	PAGE TITLE		
1	M-100	COVER PAGE	18	E-0	COVER SHEET		
2	M-101	GENERAL NOTES	19	E-1	GENERAL NOTES, ABBREVIATIONS & SYMBOL LEGEND		
3	M-102	GENERAL NOTES	20	E-2	QUALITY STANDARDS FOR AFMA INFRASTRUCTURE SYSTEMS		
4	M-103	GENERAL NOTES	21	E-3	QUALITY STANDARDS FOR AFMA INFRASTRUCTURE SYSTEMS		
5	M-200	MECHANICAL ROOM DEMO PLAN	22	E-4	QUALITY STANDARDS FOR AFMA INFRASTRUCTURE SYSTEMS		
6	M-201	SERVER ROOM COOLING SYSTEM DEMO PLAN	23	E-5	ENLARGED MECH. RM DEMO POWER PLAN		
7	M-300	MECHANICAL ROOM PLAN	24	E-6	ENLARGED MECH. RM POWER PLAN		
8	M-301	1ST FLOOR PLAN FOR SERVER ROOM COOLING SYSTEM	25	E-7	ENLARGED SERVER RM POWER PLANS		
9	M-302	ROOF PLAN FOR SERVER ROOM COOLING SYSTEM	26	E-8	PARTIAL ELECTRICAL SINGLE-LINE DEMO DIAGRAM		
10	M-600	CHILLED WATER DDC CONTROL DEMO DIAGRAM	27	E-9	PARTIAL ELECTRICAL SINGLE-LINE DIAGRAM		
11	M-601	CHILLED WATER DDC CONTROL DIAGRAM	28	E-10	PANELBOARD SCHEDULES		
12	M-800	MECHANICAL EQUIPMENT SCHEDULE	29	E-11	MAIN SWITCHGEAR ELEVATION		
13	TC-1	TEMPERATURE CONTROL COVER SHEET					
14	TC-2	QUALITY STANDARDS					
15	TC-3	DDC SYSTEM RISER, IT AND NOTES					
16	TC-4	CHW SYSTEM MODS					
17	TC-5	SCHEDULES					

PIPING ELEMENTS / VALVING	DUCTWORK SYMBOLS	ABBREVIATIONS	IDENTIFICATION SYMBOLS	GENERAL CONTRACTOR		KEY PLAN
<div><div><div>2/21/14 K/VF ON CADPUBLIC/CAD/AVR FORCE BARE/LITTLE ROCK/14554/WORKING MECH DRAWINGS/002 MECH DESIGN DRAWINGS/LITTLE ROCK COVER.DWG</div></div><div></div></div>	<div><div></div></div>	<div><div><div>AD AHU B BP BTU C CFM CHWR CHWS CO CT CUH CV CWP DB DIA DCW DHW DWP (E) EA EAT EF ESP ET EWT FCU FD FLR FPM FTR GC</div><div>ACCESS DOOR AIR HANDLING UNIT BOILER BOILER PUMP BRITISH THERMAL UNIT CHILLER CUBIC FEET PER MINUTE CHILLED WATER RETURN CHILLED WATER SUPPLY CLEAN OUT COOLING TOWER CABINET UNIT HEATER CONSTANT VOLUME CHILLED WATER PUMP DRY BULB DIAMETER DOMESTIC COLD WATER DOMESTIC HOT WATER DOMESTIC WATER PUMP EXISTING EACH ENTERING AIR TEMPERATURE EXHAUST FAN EXTERNAL STATIC PRESSURE EXPANSION TANK ENTERING WATER TEMPERATURE FAN COIL UNIT FIRE DAMPER FLOOR FEET PER MINUTE FINNED TUBE RADIATION GENERAL CONTRACTOR</div><div>GPM HWP HWR HWS HX HZ ID LAT LWT M NC NO NIC OA OAI OAT RA RHC RF SA SP TWP TWR TWS TYP UH VAV VD VTR WB</div><div>GALLONS PER MINUTE HOT WATER PUMP HEATING HOT WATER RETURN HEATING HOT WATER SUPPLY HEAT EXCHANGER HERTZ INSIDE DIAMETER LEAVING AIR TEMPERATURE LEAVING WATER TEMPERATURE MOTOR OPERATED DAMPER NORMALLY CLOSED NORMALLY OPEN NOT IN CONTRACT OUTSIDE AIR OUTSIDE AIR INTAKE OUTSIDE AIR TEMPERATURE RETURN AIR REHEAT COIL RETURN FAN SUPPLY AIR STATIC PRESSURE TOWER WATER PUMP TOWER WATER RETURN TOWER WATER SUPPLY TYPICAL UNIT HEATER VARIABLE AIR VOLUME UNIT VOLUME DAMPER VENT THRU ROOF WET BULB</div></div></div>	<div><div></div></div>	<div><div><div>dkjv Donley-Kirlin Joint Venture 515 DOVER RD. ROCKVILLE, MD. 20850 (301) 315-7456 / FAX: (240) 453-8722 DONLEYKIRLIN.COM</div><div>ENGINEER</div><div>KROESCHELL ENGINEERING Co. 3222 KENNICOTT AVE. ARLINGTON HEIGHTS, IL. 60004 (312) 649-7980 / FAX: (312) 337-1944 KROESCHELL.COM</div><div>WORK PLAN MANAGER</div><div>BMH ENGINEERING, LLC 3500 PIEDMONT RD. NE ATLANTA, GA 30305 (678) 886-8220</div></div></div>	<div><div><div>TRUE NORTH ARROW</div><div>PLAN NORTH ARROW</div></div></div>	<div><div><div> 1ST. FLOOR</div><div><div><div>CAD Filename: Little Rock Cover.dwg</div><div><div>ORIGINAL SHEET SIZE: D SIZE 36x24</div><div>DATE REVISIED</div></div><div><div>ADDITIONS AND REVISIONS</div><div><div>35% DESIGN DRAWINGS10/04/2013</div><div>65% DESIGN DRAWINGS11/29/2013</div><div>65% DESIGN DRAWINGS -- REVISION 01/10/2014</div><div>100% DESIGN DRAWINGS02/21/2014</div></div></div></div><div><div><div>KROESCHELL ENGINEERING Co. 3222 KENNICOTT AVE. ARLINGTON HEIGHTS, IL. 60004 (312) 649-7980 / FAX: (312) 337-1944 KROESCHELL.COM</div><div>dkjv Donley-Kirlin Joint Venture 515 DOVER RD. ROCKVILLE, MD. 20850 (301) 315-7456 / FAX: (240) 453-8722 DONLEYKIRLIN.COM</div></div><div><div>COVER 19TH MEDICAL SUPPORT GROUP JACKSONVILLE, AR REPAIR OF BUILDING INFRASTRUCTURE SYSTEMS</div><div><div><div>DRAWN BY CHECKED BY APPROVED BY SCALE DATE</div><div><div>JWT BJK - SEE PAGE OCTOBER 2013</div></div></div><div><div>JOB No. 14554</div><div>Sheet No. M-100</div></div></div></div></div></div></div></div>

NOTICE: THIS IS THE PERSONAL PROPERTY OF KROESCHELL ENGINEERING CO.
AND ALL USE IS FORBIDDEN EXCEPT UPON WRITTEN CONSENT.