

REVISIONS  
DATE  
BY  
DESCRIPTION

8  
7  
6  
5  
4  
3  
2  
1

A B C D E F G H




1 ROOF PLAN

SCALE: 1/16" = 1'-0"

NOTES

1. SEE DRAWING M3.12 FOR ENLARGED PLAN OF PENTHOUSE 1.

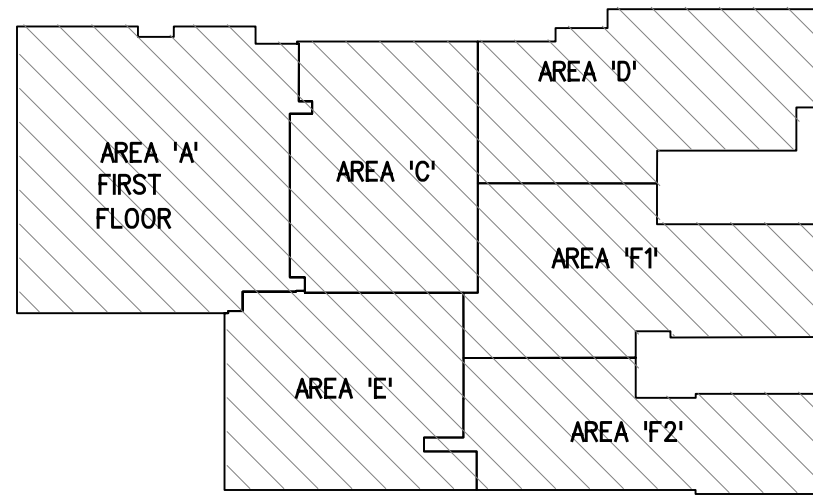


KEY PLAN

N.T.S.



SCALE

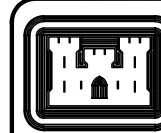

US Army Corps  
of Engineers  
Huntsville  
Alabama

REVISIONS AS-BUILT	DATE	APPROVED	SYMBOL	AMENDMENT	DESCRIPTION
1	8/07/2005				ISSUED FOR FINAL WORK PLAN
2	10/31/2003				ISSUED FOR BID
3	10/17/2003				AMENDMENT

DESIGNED BY: DATE: 08/04/2003	PROJECT NO. 6503
DRAWN BY: C.S.	DRAWING CODE: 6503
CHECKED BY: R.W.H.	REVIEWED BY: SOLICITATION NUMBER:
U.S. ARMY ENGINEERING AND SUPPORT CENTER CORPS OF ENGINEERS HUNTSVILLE, ALABAMA	
EARTHTECH 2001 Huntsville, AL 35894-0001	
FLM FLM Design	

RENOVATE CLINIC  
BUILDING 1090  
LITTLE ROCK AFB, ARKANSAS  
**LEVEL ONE ZONE A HVAC  
EQUIPMENT ROOF PLAN  
AS-BUILT**

SHEET  
REFERENCE  
NUMBER:  
**M3.11**  
SHEET X OF XX

SCALE: 1/16" = 1'-0"

1

2

3

4

5

6

7

8