


PARTIAL FIRST FLOOR MECHANICAL PLAN  
S-4 - RETURN DUCT

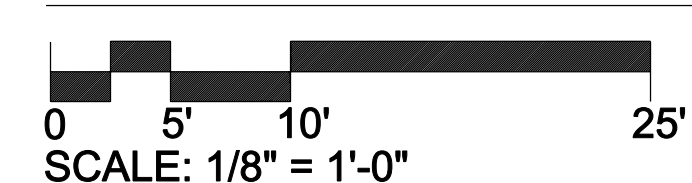

LEGEND	
	EXHAUST GRILLE
	RETURN GRILLE
	SUPPLY GRILLE
	HARD CEILING AREA
	DAMPER LOCATION (BY COLOR)
	ABOVE FINISHED FLOOR HEIGHT (BY COLOR)
	SMOKE DAMPER LOCATION
	DUCT DETECTOR LOCATION
	EXHAUST DUCT
	SUPPLY DUCT
	RETURN DUCT
	HEAT DUCT
	FLEX DUCT (BY COLOR)
	THERMOSTAT LOCATION
	DIGITAL CONTROLLER
	FIRE DAMPER
	PICTURE LOCATION

KEYED NOTES:

- SEE SPACE SCHEDULES THIS SHEET FOR AIR BALANCE DATA FOR SUPPLY, RETURN AND EXHAUST SYSTEMS. NOTE THAT AFTER EXISTING ROOF MOUNTED UNITS HAVE BEEN REPLACED PROVIDE AIR BALANCE. PROVIDE COMPLETE AIR BALANCE DATA FOR REVIEW. NOTE THAT PRESSURE RELATIONSHIPS AS INDICATED ON THE SCHEDULES MUST BE BALANCED.
- NOTE THAT THE DUCT ROUTING AND SIZE AS INDICATED ON THIS DRAWING HAS BEEN FIELD VERIFIED.



LITTLE ROCK A.F.B.  
ARKANSAS

MIKE TRUSTY  
ENGINEERING  
PHONE: (501)224-9013  
FAX: (501)421-0151  
miketrusty@msn.com

No.	Revision/Issue	Date	BY	APPD

PROJECT TITLE REPAIR & RENOVATE MEDICAL CLINIC PH V LITTLE ROCK AIR FORCE BASE JACKSONVILLE, ARKANSAS CHANGE ORDER TO PHASE V - 100% SUBMITTAL	PARTIAL FIRST FLOOR MECHANICAL PLAN S-4 - RETURN DUCT		
	DRAWN BY GMT	LEAD DESIGNER GMT	
	TECH REVIEWER GMT	PROJECT NUMBER NKAK#06-8006-5	
	DESIGNED BY GMT	SHEET M-203	
DATE DEC. 3, 2010			
SCALE AS SHOWN			8 of 21

AS-BUILT