

LITTLE ROCK A.F.B.
ARKANSAS

FPM


804 West Curtis Drive, Suite H
Midwest City, OK 73110
phone: 405.869.9212
fax: 405.869.9222
www.fpm-group.com

RECORD
DRAWINGS
MARCH 2007


ACCESSORIES LEGEND

A1066	MIRROR
A4995	DIAPER CHANGING STATION
A5075	SOAP DISPENSER
A5080	PAPER TOWEL DISPENSER
A5108	WASTE DISPOSAL
A5109	GRAB BAR
A5145	GARMENT HOOK
A5200	TOILET TISSUE DISPENSER
P3100	LAVATORY
P8150	URINAL
P9050	TOILET


NOTE:
ALSO REFER TO SHEET A3.20 FOR INTERIOR ELEVATION

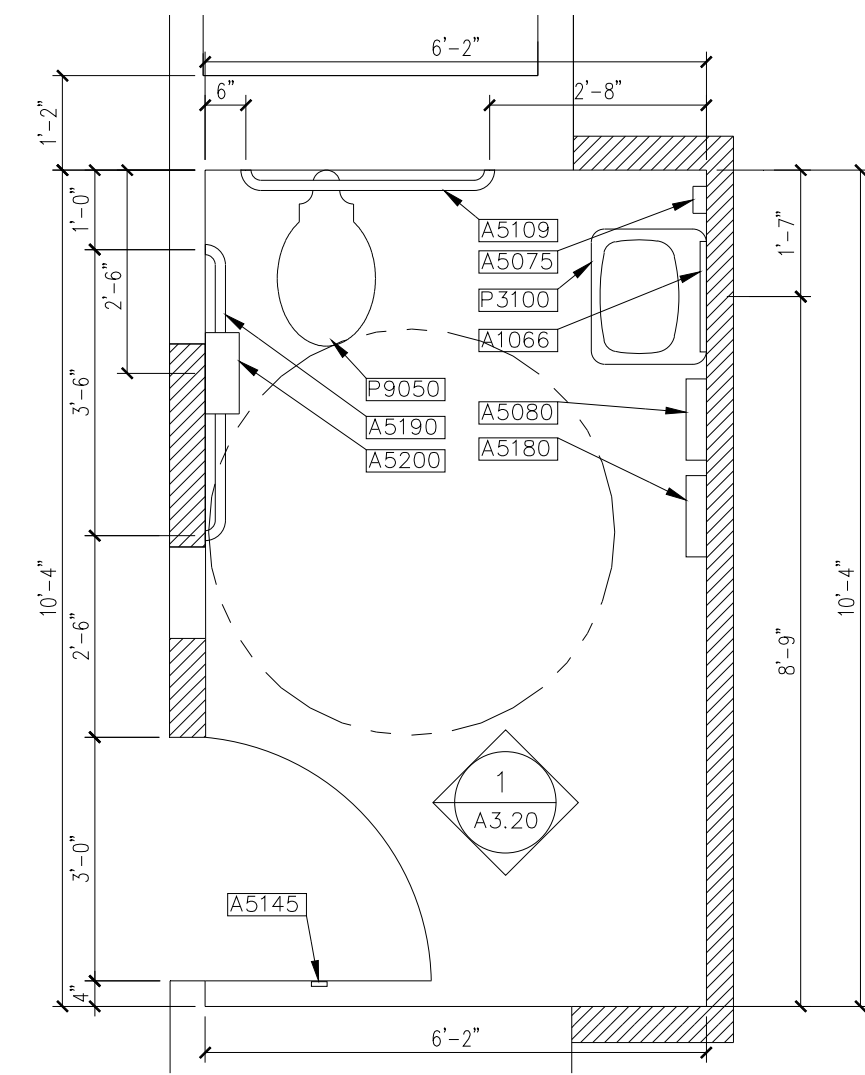


1 TOILET A181

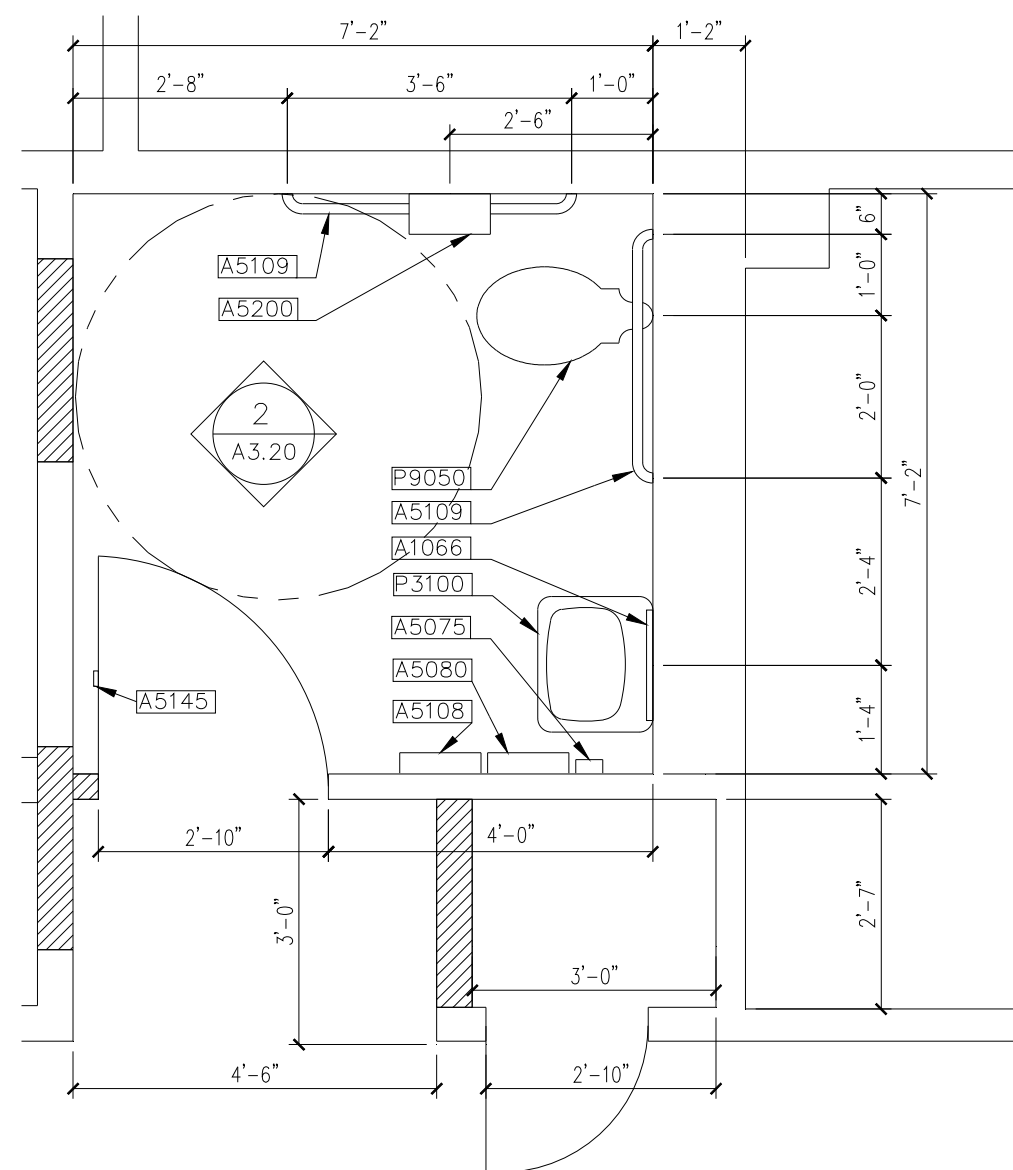


2 TOILET A188

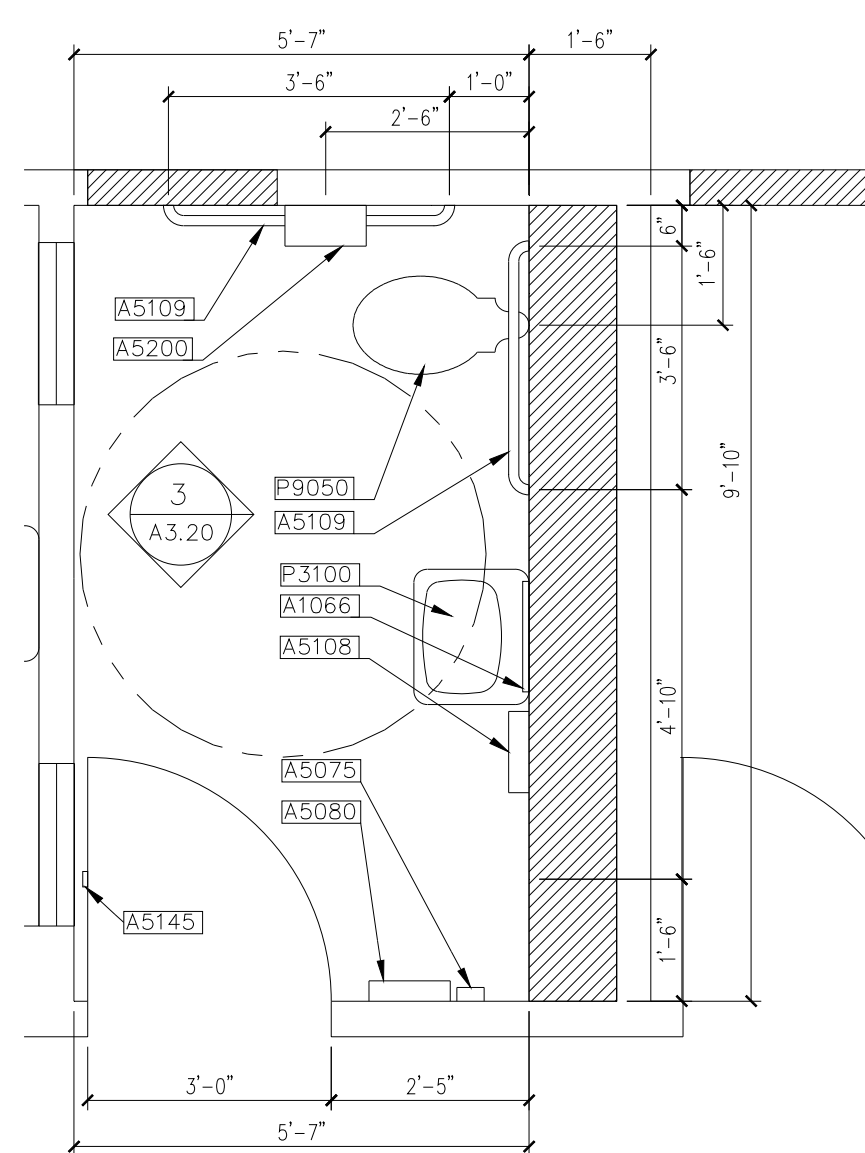


3 TOILET A218

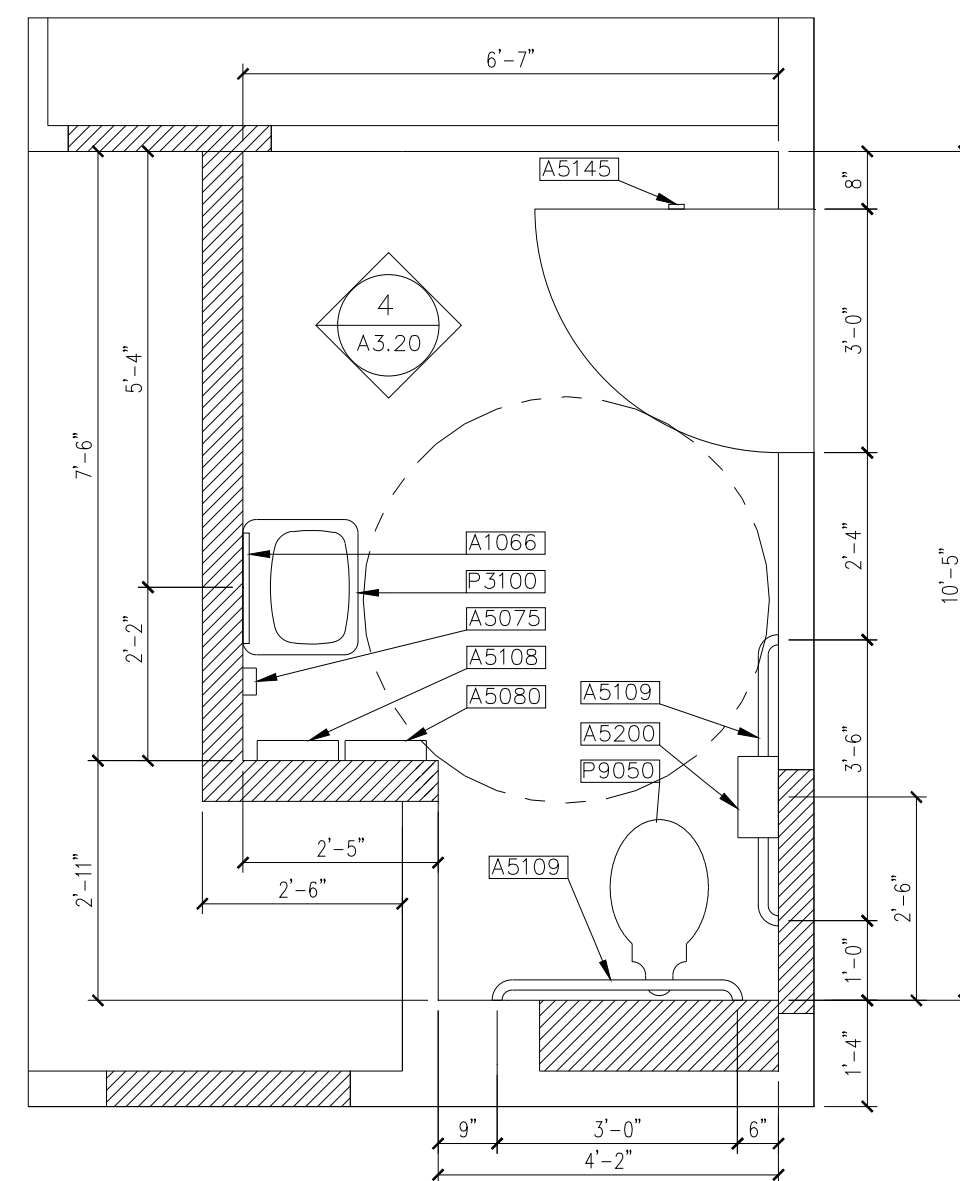

4 TOILET A245


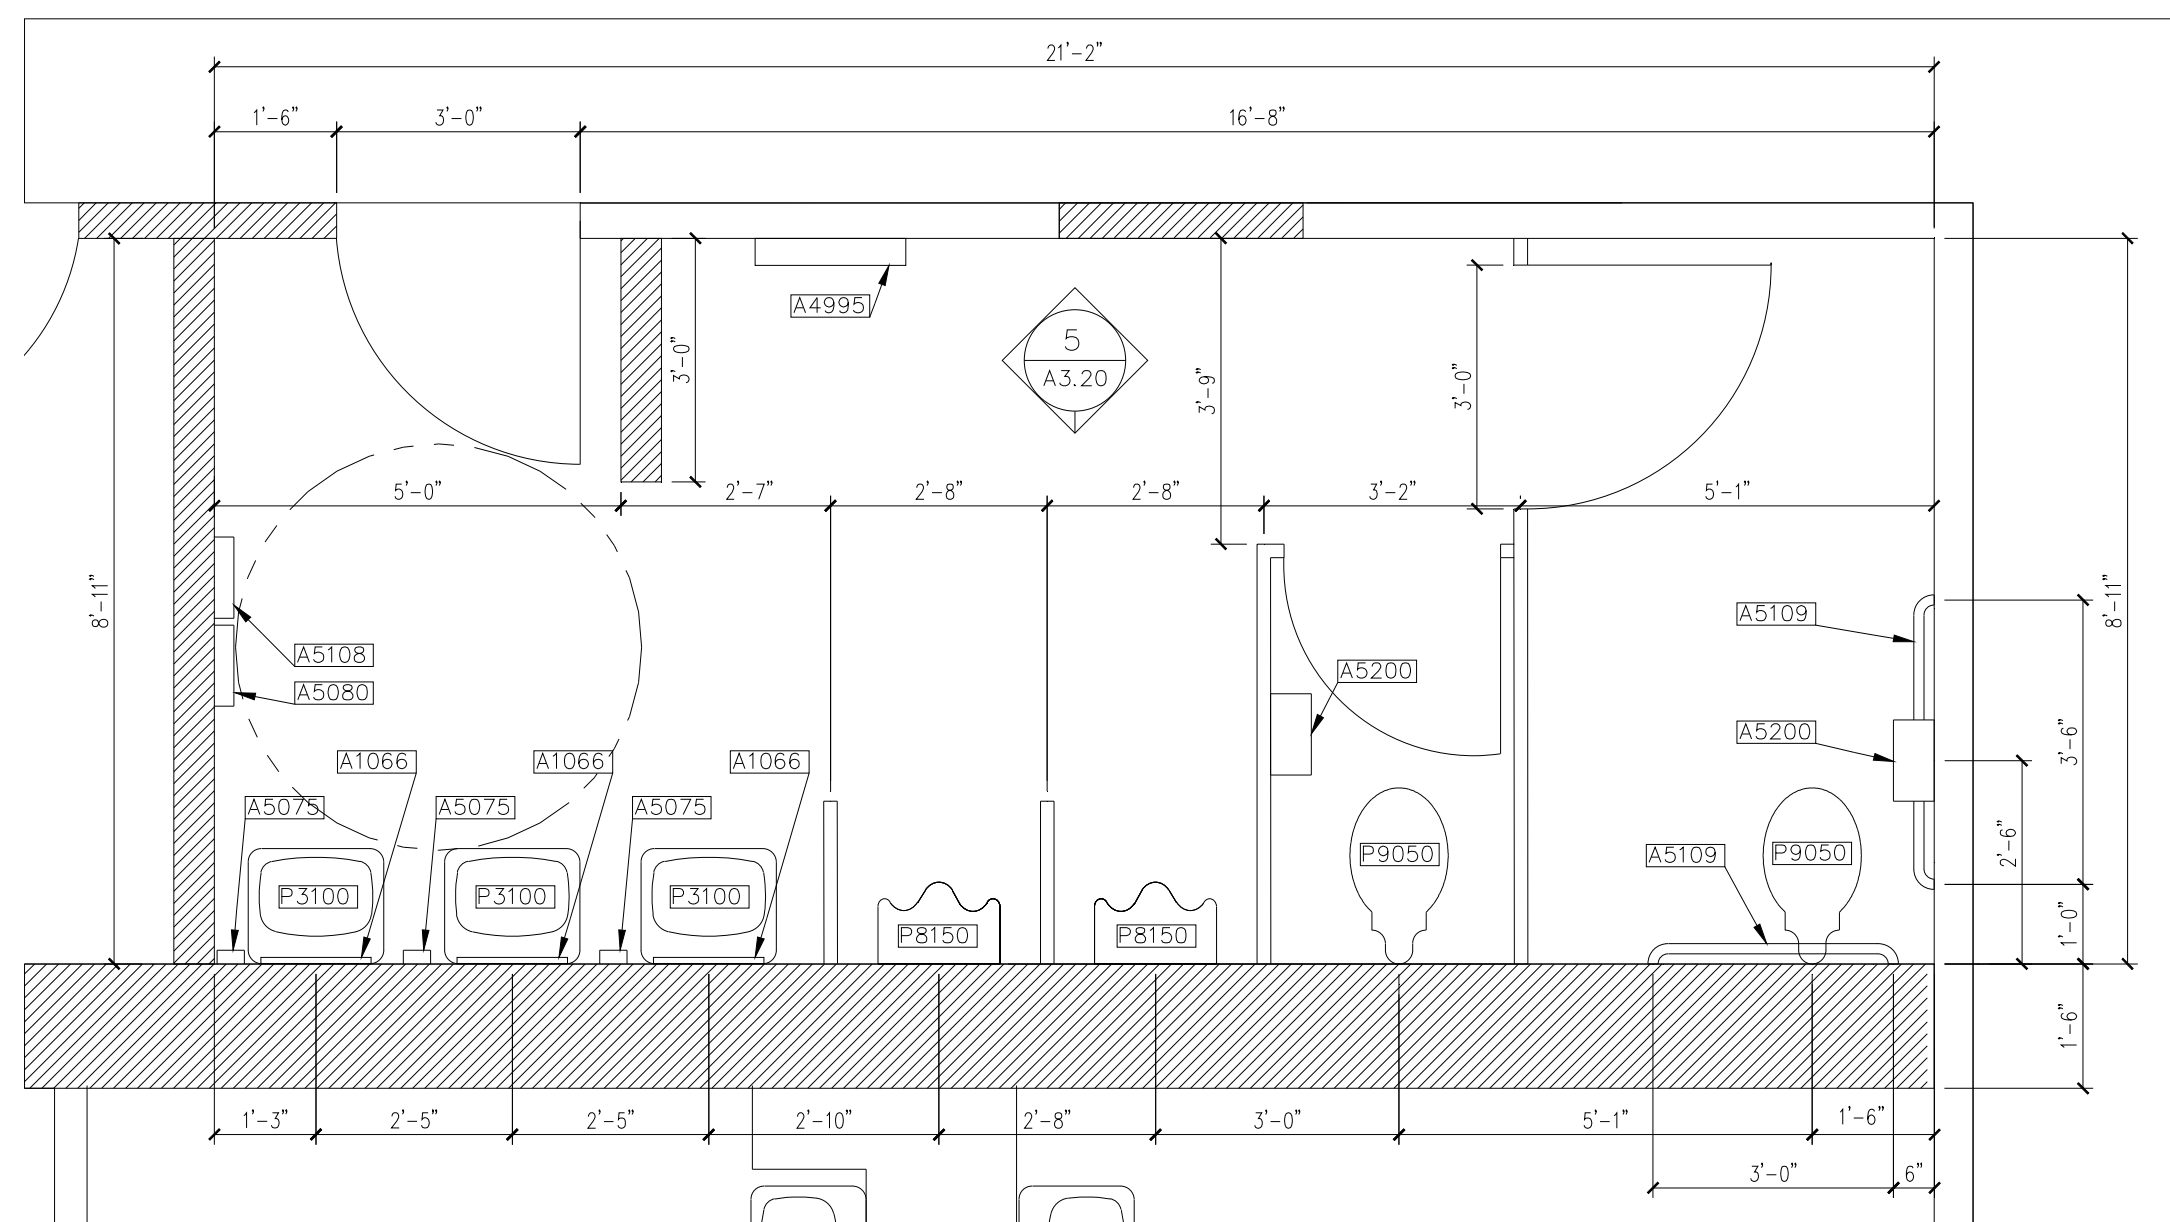


5 TOILET A238

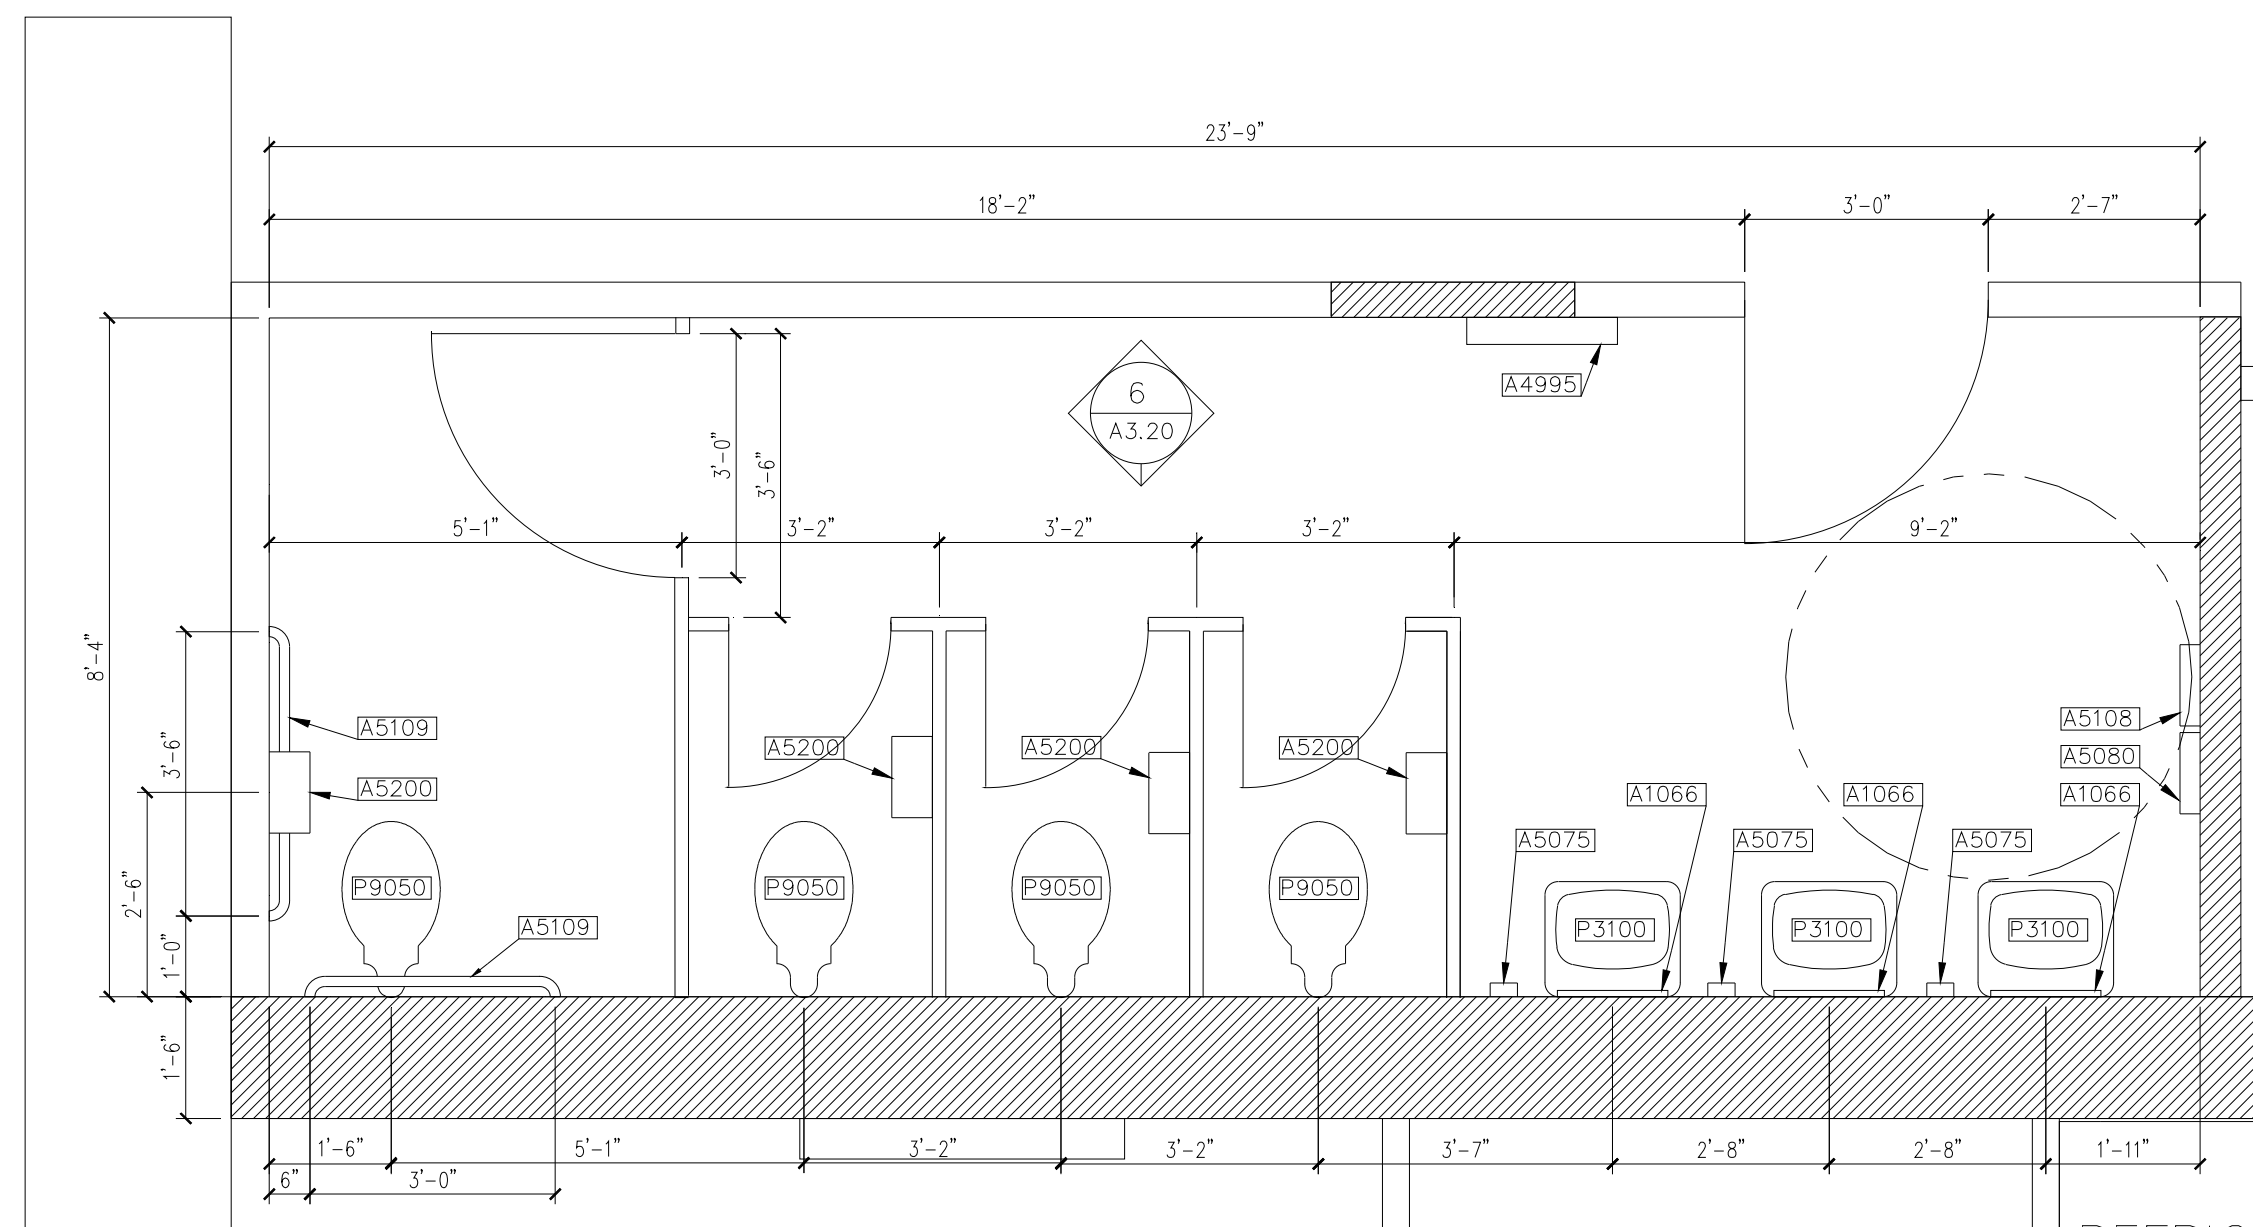

6 TOILET A121

KEYPLAN
N.T.S.

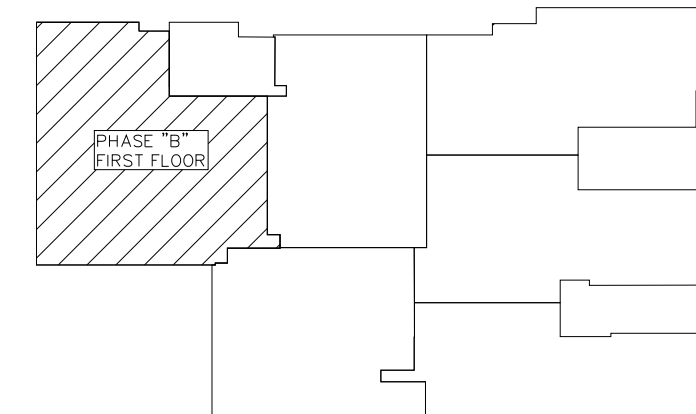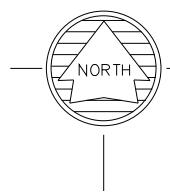

PROJECT TITLE

REPAIR MEDICAL CENTER PH B
LITTLE ROCK AFB, ARKANSAS

DRAWN BY

RJR

TECH REVIEWER

AM

DESIGNED BY

AM

DATE

1-21-08

SCALE

1/2"=1'

SHEET TITLE

ENLARGED FLOOR PLANS

LEAD DESIGNER

AM

PROJECT NUMBER

NKAK 05-8004A

SHEET

A3.10

8 OF 39