

- WALL LEGEND
- EXISTING METAL STUD & GYP BD WALL TO REMAIN. PROVIDE NEW FINISHES PER SCHEDULE. WALL EXTENDS TO APPROXIMATELY 6" ABOVE CEILING
 - NEW METAL STUD & GYP BOARD WALL WITH SOUND INSULATION FULL HEIGHT TO STRUCTURE ABOVE.
 - NEW METAL STUD & GYP BOARD WITH SOUND INSULATION, EXTENDS TO APPROXIMATELY 6" ABOVE CEILING
 - NEW METAL STUD & GYP BOARD HALF WALL.
 - SECURITY WALL PER DOD STANDARDS. NEW OR MODIFIED EXISTING WALL, PER WALL TYPES ABOVE. FULL HEIGHT TO STRUCTURE. ALL OPENINGS SHALL BE PROTECTED PER DOD STANDARDS.
 - WALL TYPE KEY. SEE A-501.

- CEILING LEGEND
- EXISTING CEILING TO REMAIN
 - 2 x 2 ACOUSTICAL TILE & METAL GRID SYSTEM
 - GYP. BD. CEILING SYSTEM
 - LIGHT FIXTURE. SEE ELECTRICAL DRAWINGS
 - MECHANICAL REGISTERS. SEE MECH DRAWINGS


- REFLECTED CEILING PLAN NOTES AND KEYS:
- SEE FINISH SCHEDULE, DRAWING A-601, FOR CEILING HEIGHTS.
 - NOT USED
 - AT EXISTING CEILING TO REMAIN. PATCH AS REQUIRED WITH LIKE MATERIALS. PAINT PER FINISH SCHEDULE.
 - THRU 10 NOT USED
 - EXTEND EXISTING GRID AND A.C.T. CEILING
 - SEE ROOM SCHEDULE A-601. AFTER SELECTIVE DEMOLITION, VERIFY WITH OWNER EXTENT OF EXISTING AND FUTURE CABLE OR LADDER TRAY SYSTEM TO PROVIDE IN LIEU OF OR IN ADDITION TO A.C.T. CEILING SYSTEM



LITTLE ROCK A.F.B.
ARKANSAS

1010 Battery St.
Little Rock, AR
72202
501-376-3633
www.GarverUSA.com

CROMWELL
ARCHITECTS ENGINEERS
101 SOUTH SPRING ST
LITTLE ROCK AR 72201
TELEPHONE 501-372-2900
FACSIMILE 501-372-0482

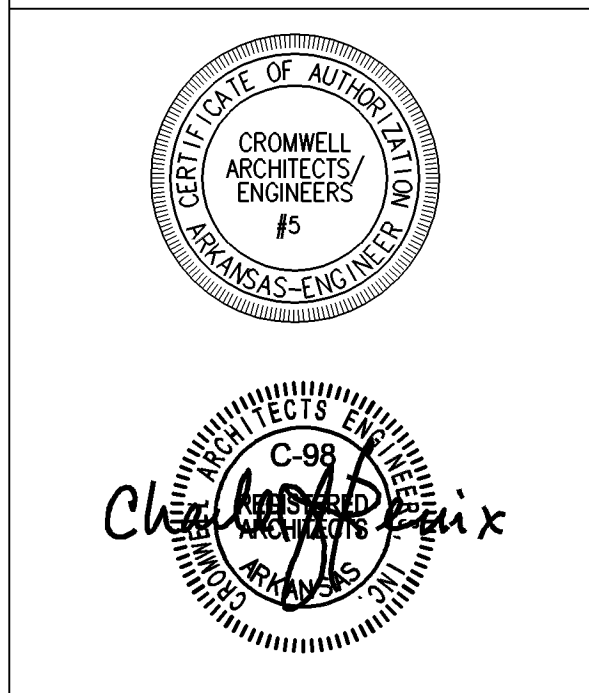

No.	Revision/Issue	Date	BY	APP'D

PROJECT TITLE REPAIR & RENOVATE MED. CLINIC PH IV A LITTLE ROCK AIR FORCE BASE JACKSONVILLE, ARKANSAS	SHEET TITLE REFLECTED CEILING PLAN - AREA "B"			
	DRAWN BY JKL	LEAD DESIGNER K. TAYLOR		
	TECH REVIEWER JKL	PROJECT NUMBER NKAK 06-8006 4A		
	DESIGNED BY JOHN K. LAI	SHEET A-102-R		
	DATE 13 MAY 2009	SCALE		

1 REFLECTED CEILING PLAN - AREA "B" - RESOURCE MGMT OFFICE, IT SYSTEMS
1/8"=1'-0"

