




LITTLE ROCK A.F.B.  
ARKANSAS


FPM

804 West Curtis Drive, Suite H  
Midwest City, OK 73110  
phone: 405.869.9212  
fax: 405.869.9222  
www.fpm-group.com


RECORD  
DRAWINGS  
MARCH 2007

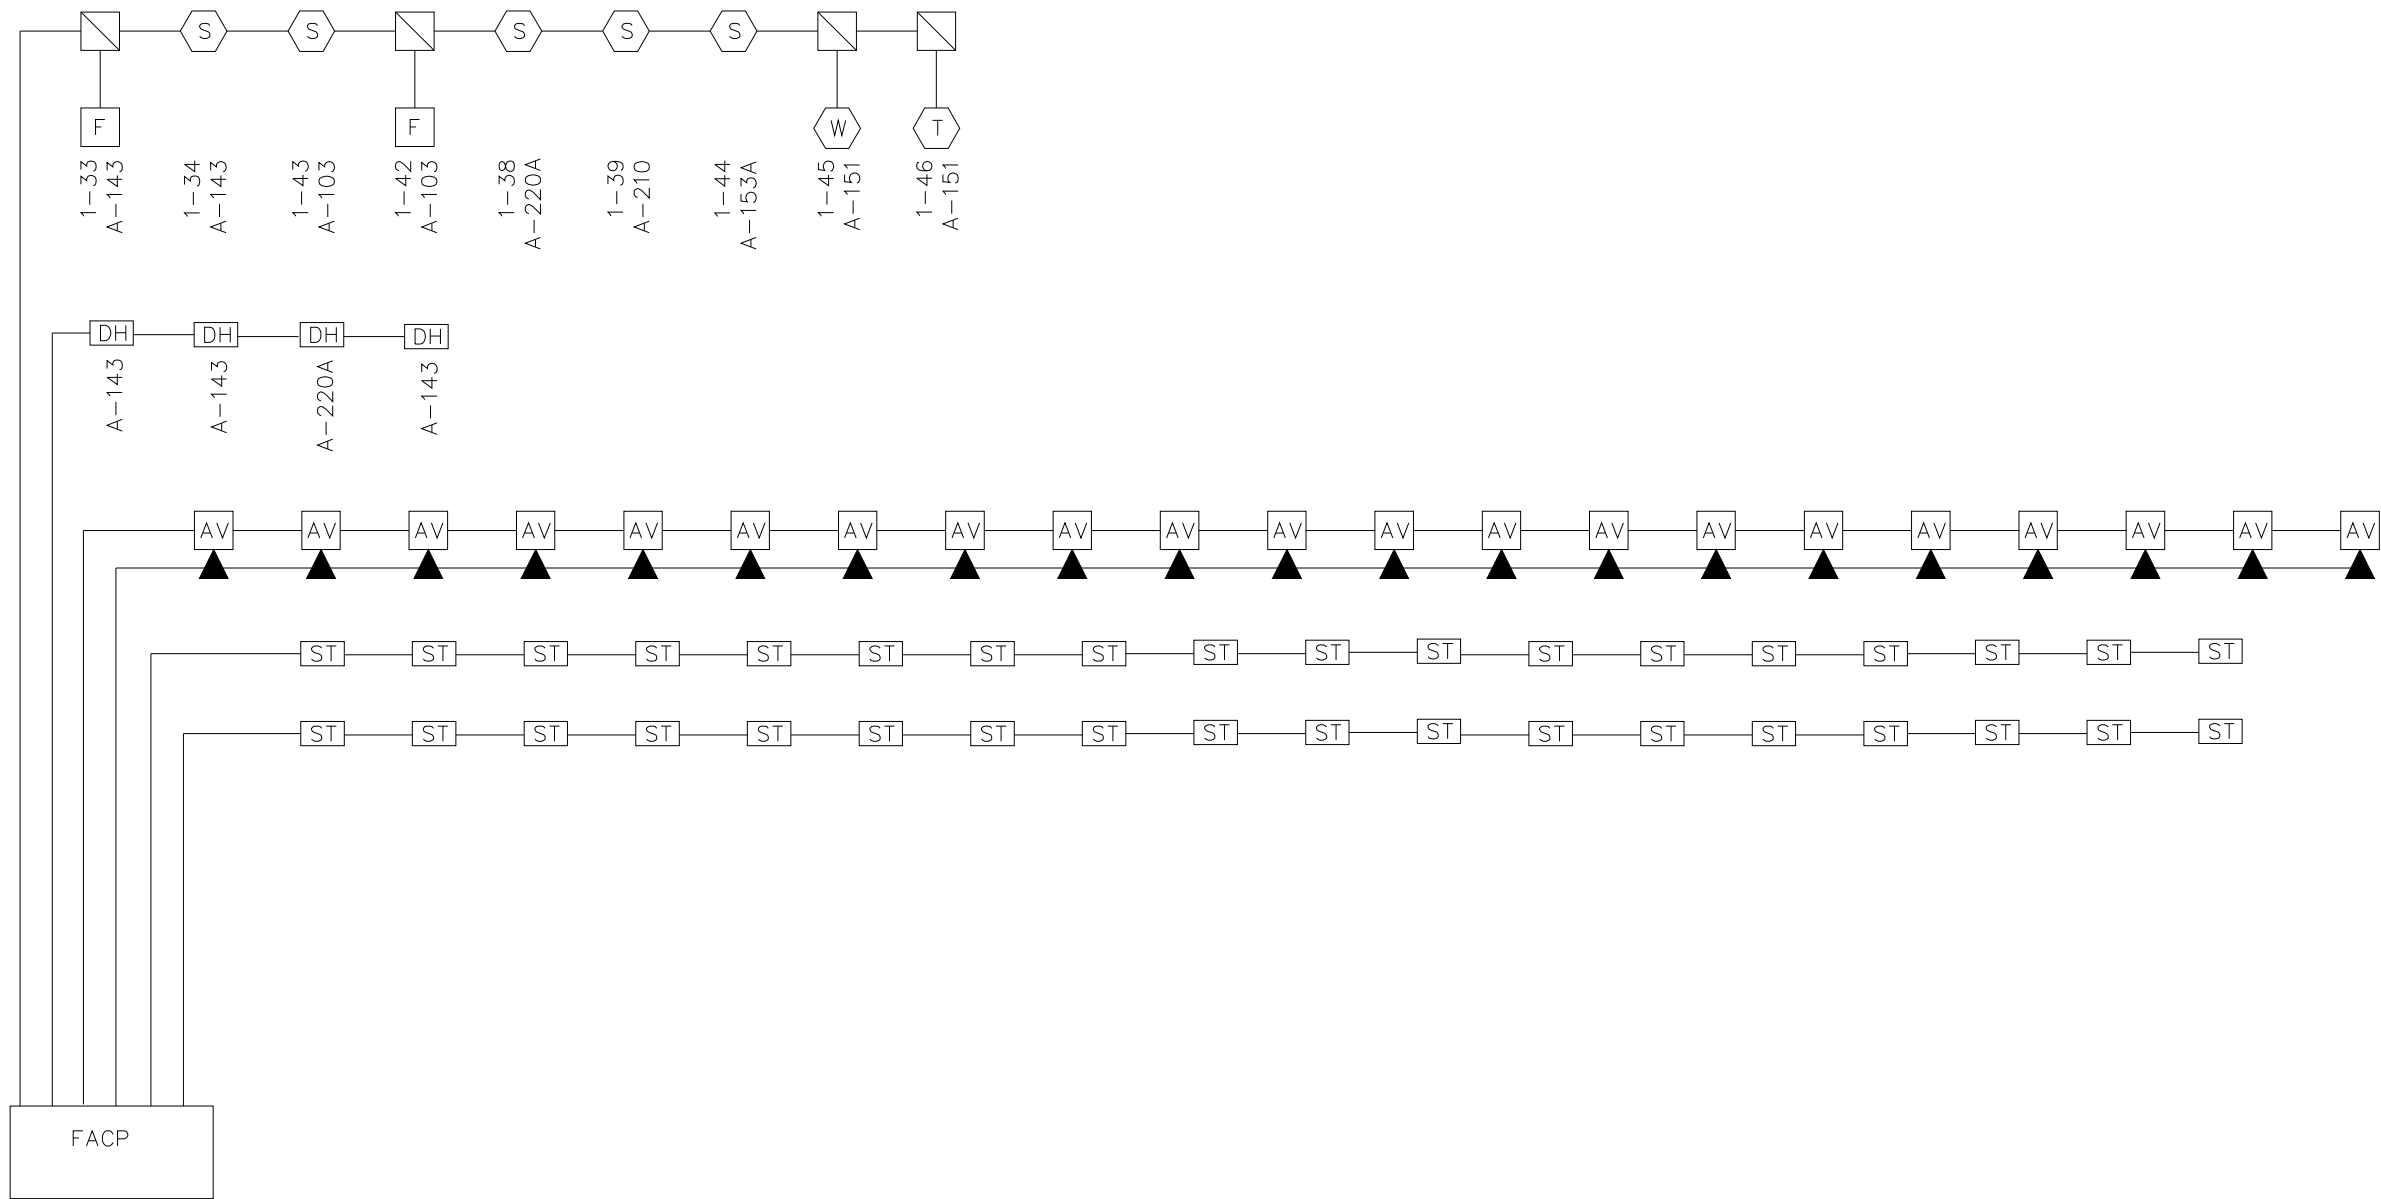

1 FIRE ALARM RISER DIAGRAM  
NO SCALE


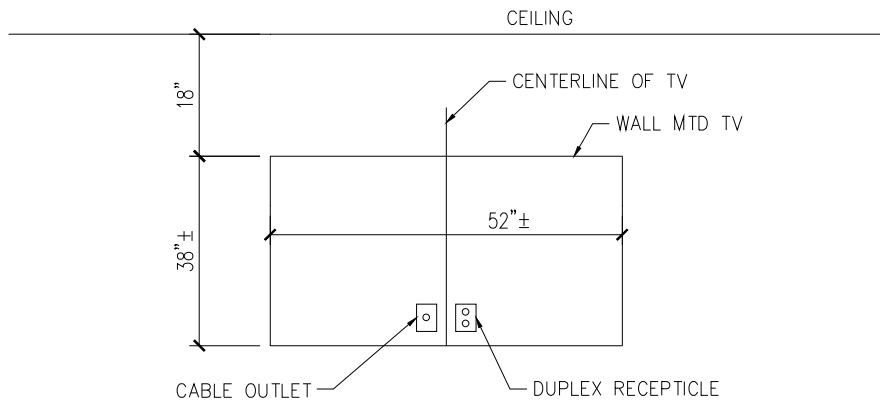


2 OUTLETS @ WALL MTD. TV'S  
SCALE 1/2" = 1'-0"

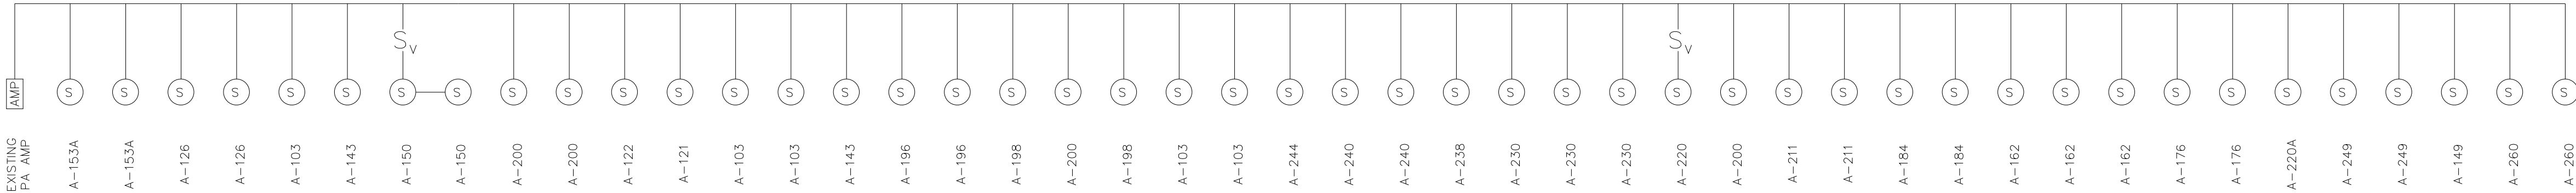

3 PA SYSTEM RISER DIAGRAM  
NO SCALE

KEYPLAN

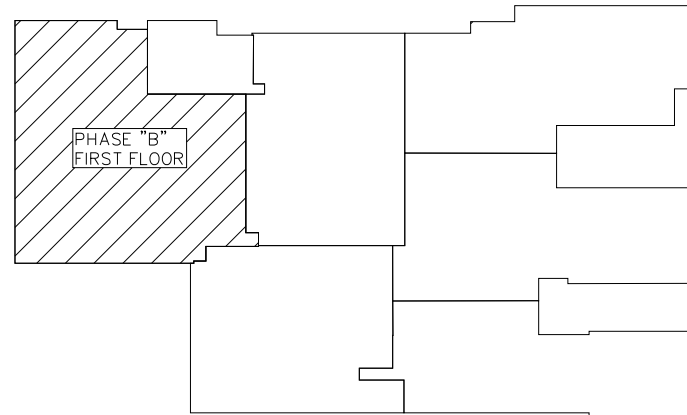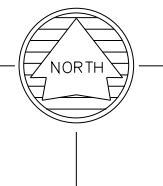

PROJECT TITLE REPAIR MEDICAL CENTER PH B LITTLE ROCK AFB, ARKANSAS		SHEET TITLE SYSTEM RISER DIAGRAM & DETAIL	
DRAWN BY RJR	LEAD DESIGNER AM	PROJECT NUMBER NKAK 05-8004A	E2.01 37 OF 39
TECH REVIEWER KF	DESIGNED BY KF	SHEET	
DATE 1-21-08	SCALE 1/8"=1"		