



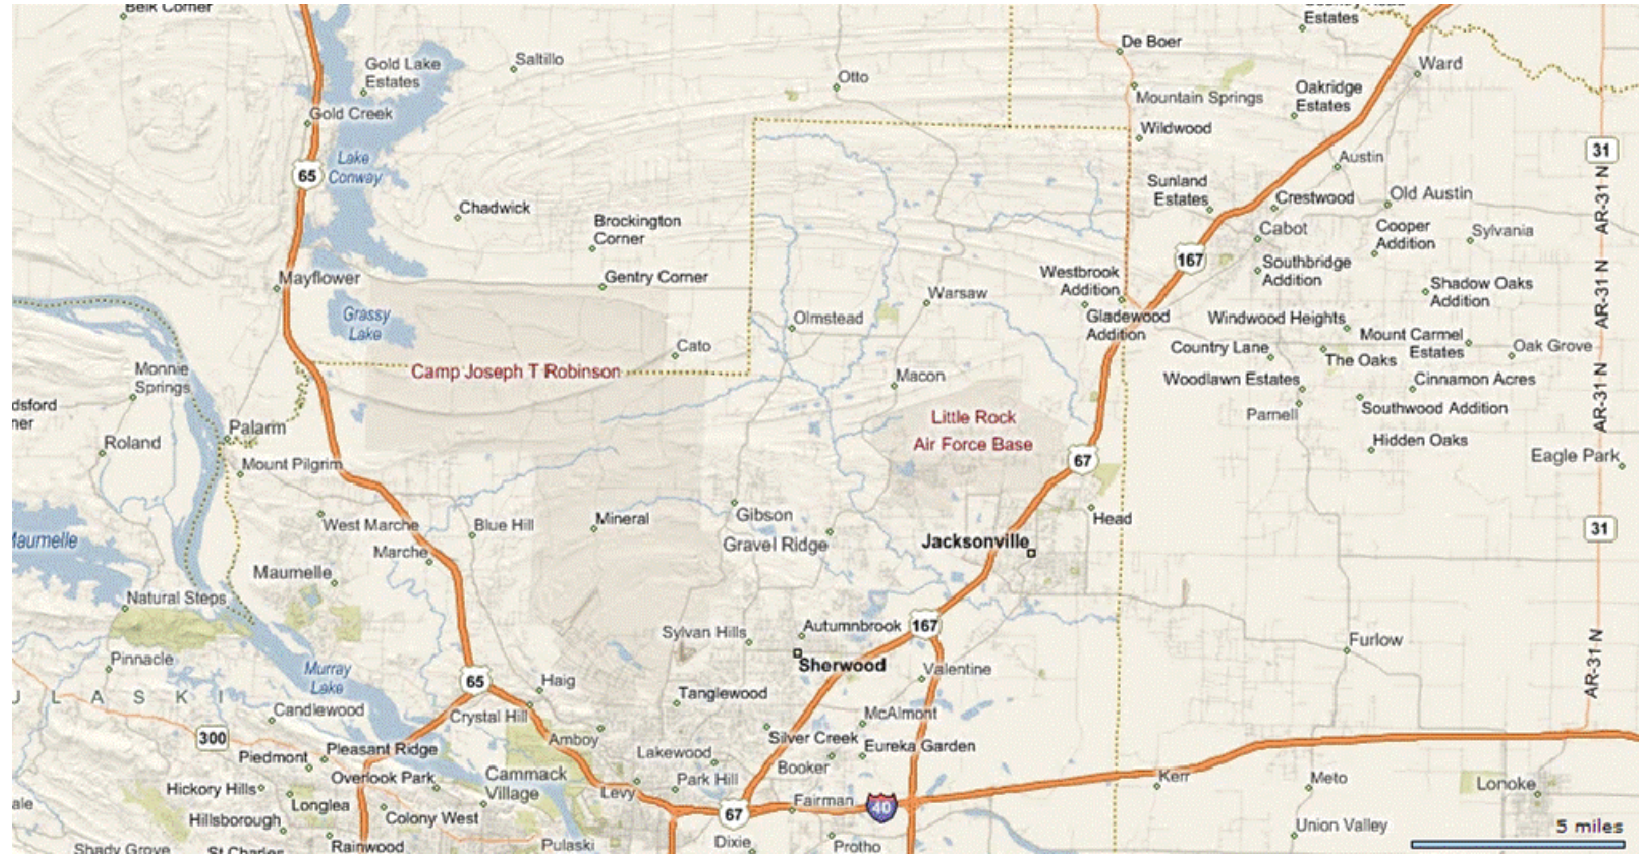
REPLACEMENT OF ELECTRICAL SERVICE & DISTRIBUTION SYSTEM

19TH MEDICAL SUPPORT GROUP



LITTLE ROCK AFB, ARKANSAS

ISSUED FOR 100% DESIGN - DATE FEBRUARY 21, 2014

LOCATION MAP	SHEET INDEX
	E-0 COVER SHEET E-1 GENERAL NOTES, ABBREVIATIONS & SYMBOL LEGEND E-2 QUALITY STANDARDS FOR AFMA INFRASTRUCTURE SYSTEMS E-3 QUALITY STANDARDS FOR AFMA INFRASTRUCTURE SYSTEMS E-4 QUALITY STANDARDS FOR AFMA INFRASTRUCTURE SYSTEMS E-5 ENLARGED MECH. RM DEMO POWER PLAN E-6 ENLARGED MECH. RM POWER PLAN E-7 ENLARGED SERVER RM POWER PLANS E-8 PARTIAL ELECTRICAL SINGLE-LINE DEMO DIAGRAM E-9 PARTIAL ELECTRICAL SINGLE-LINE DIAGRAM E-10 PANELBOARD SCHEDULES E-11 MAIN SWITCHGEAR ELEVATION
CODE INFORMATION	
1. APPLICABLE CODES AND STANDARDS <ul style="list-style-type: none">◦ ACCESSIBILITY-----AMERICANS WITH DISABILITIES ACT OF 1990◦ BUILDING-----INTERNATIONAL BUILDING CODE 2012◦ ELECTRICAL-----NFPA 70-2011, NFPA 99-2012, NFPA 110-2013, UFC 4-510-01◦ MECHANICAL-----UFC 4-510-01◦ ZONING-----NOT APPLICABLE	

SHEET PLOTTED FULL SIZE = 24"x36"		DATE REVISED
NOTICE: THIS IS THE PERSONAL PROPERTY OF KROESCHELL ENGINEERING CO. AND ALL USE IS FORBIDDEN EXCEPT UPON WRITTEN CONSENT.		
CAD Filename: K\\Air Force Bases\\Little Rock\\14554		
ADDITIONS AND REVISIONS		
ISSUED FOR 65% DESIGN		1/10/14
ISSUED FOR 65% DESIGN-REV. 1		1/13/14
ISSUED FOR 100% DESIGN		2/21/14
<div><div>KROESCHELL ENGINEERING Co.</div><div>3222 KENNICOTT AVE. ARLINGTON HEIGHTS, IL 60004 (312) 649-7980 / FAX: (312) 337-1944 KROESCHELL.COM</div></div>		<div><div>dkjv DonkeyKidd Jost Ventures</div><div>515 DOVER RD. ROCKVILLE, MD 20850 (301) 315-7456 / FAX: (240) 453-8722 DONKEYKIDJUN.COM</div></div>
19TH MEDICAL SUPPORT GROUP LITTLE ROCK AFB, ARKANSAS REPAIR OF MECHANICAL BUILDING INFRASTRUCTURE SYSTEMS		
<div>DRAWN BY CHECKED BY APPROVED BY SCALE DATE</div>	<div>RPK MM MM NONE JANUARY 2014</div>	<div>COVER SHEET</div> <div>Sheet No. E-0 JOB No. 14554</div>