

EXISTING
COOLING
TOWER


LEGEND
REMOVE TELECOM
OUTLET, DATA OUTLET,
FIRE ALARM DEVICE,
ETC., AS INDICATED.
GENERATOR
UNIT RADIATOR
GENERATOR, SWITCHGEAR
& AUTO SYNCHRONIZER
AIR INTAKE CKT.
LSE3-13,15,17
3#6, 1#10, 1"C
HEATER CKT.
LSE3-10,12
3#10, 3/4"C

GENERAL NOTES

1. THE CONTRACTOR SHALL TRACE THE CIRCUIT BACK TO THE NEXT DEVICE AND/OR POINT OF ORIGIN AND REMOVE ALL ABANDONED BRANCH CIRCUIT WIRING. MAINTAIN WIRING TO EXISTING DEVICES TO REMAIN AND CLEARLY LABEL THESE CIRCUITS IN THE NEW PANEL SCHEDULES.

COOLING
KEY NOTES

1 REMOVE CAMERA AND RETURN TO THE OWNER.

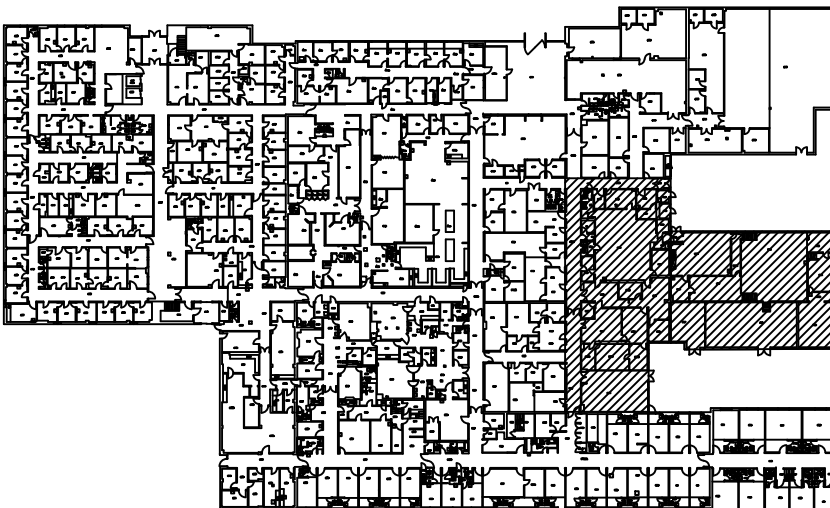

KEY PLAN



LITTLE ROCK A.F.B.
ARKANSAS

GARVER ENGINEERS

1010 BATTERY STREET
LITTLE ROCK, ARKANSAS 72202
www.garverengineers.com
(501) 376-3633

CROMWELL
ARCHITECTS ENGINEERS

101 SOUTH SPRING ST
LITTLE ROCK AR 72201
TELEPHONE 501-372-2900
FACSIMILE 501-372-0482

No.	Revision/Issue	Date	BY	APP'D

PROJECT TITLE
REPAIR & RENOVATE MEDICAL CLINIC PH IV
LITTLE ROCK AIR FORCE BASE
JACKSONVILLE, ARKANSAS
100% SUBMITTAL

ELECTRICAL FIRE ALARM/
COMM DEMO PLAN AREA "B"

DRAWN BY CAG	TECH REVIEWER CAG	DESIGNED BY CAG	DATE JULY 8, 2008	SCALE AS NOTED
PROJECT NUMBER NKAK#06-8006-4	SHEET E-106	41	OF	