



LITTLE ROCK A.F.B.
ARKANSAS


FPM
group

804 West Curtis Drive, Suite H
Midwest City, OK 73110
phone: 405.869.9212
fax: 405.869.9222
www.fpm-group.com

RECORD
DRAWINGS
MARCH 2007

LIGHT FIXTURE SCHEDULE							
TYPE	DESCRIPTION	MANUFACTURER	NO.	LAMPS		VOLTAGE	REMARKS
		CATALOG NUMBER		WATTS	TYPE		
A	2x4 RECESSED LENSED FLUORESCENT TROFFER	LSI LA125-232-SD-SSOR-LM735-UE	2	32	F32TB/ SPX41	277	
A1	2x4 RECESSED LENSED FLUORESCENT TROFFER	LSI LA125-232-SD-SSOR-LM735-UE-EM	2	32	F32TB/ SPX41	277	FIXTURE SHALL HAVE EMERGENCY POWER BATTERY PACK WITH 1200 LUMEN MINIMUM
B	2x4 RECESSED PARABOLIC FLUORESCENT TROFFER	LSI N2PG-12-332-FD-SSOR-LM735-UE	3	32	F32TB/ SPX41	277	
B1	2x4 RECESSED PARABOLIC FLUORESCENT TROFFER	LSI N2PG-12-332-FD-SSOR-LM735-UE-EM	3	32	F32TB/ SPX41	277	FIXTURE SHALL HAVE EMERGENCY POWER BATTERY PACK WITH 1200 LUMEN MINIMUM
C	RECESSED FLUORESCENT 6" CAN LIGHT	LSI 206VCFL-132T-UNIV-C27/206VCL	1	32	F32TB/ SPX41	277	
C1	RECESSED FLUORESCENT 6" CAN LIGHT	LSI 206VCFL-132T-UNIV-C27/206VCL-EM	1	32	F32TB/ SPX41	277	FIXTURE SHALL HAVE EMERGENCY POWER BATTERY PACK WITH 1200 LUMEN MINIMUM
H	WALL-MOUNTED DURESS CALL LIGHT	TEKTONE LI381	2	2	-	24VDC	
J	CEILING MOUNTED STEM DOWN LIGHT	VELA 220085MC	1	50		12VDC	
X	WALL MOUNTED LED EXIT SIGN	EXITRONIX 400U-WB-BL-G1-A1-EM	-	-	LED	277	FIXTURE SHALL HAVE EMERGENCY POWER BATTERY PACK
X1	CEILING MOUNTED LED EXIT SIGN	EXITRONIX 400U-WB-BL-G1-A1-EM	-	-	LED	277	FIXTURE SHALL HAVE EMERGENCY POWER BATTERY PACK

1 LIGHT FIXTURE SCHEDULE
E-600 SCALE: NONE

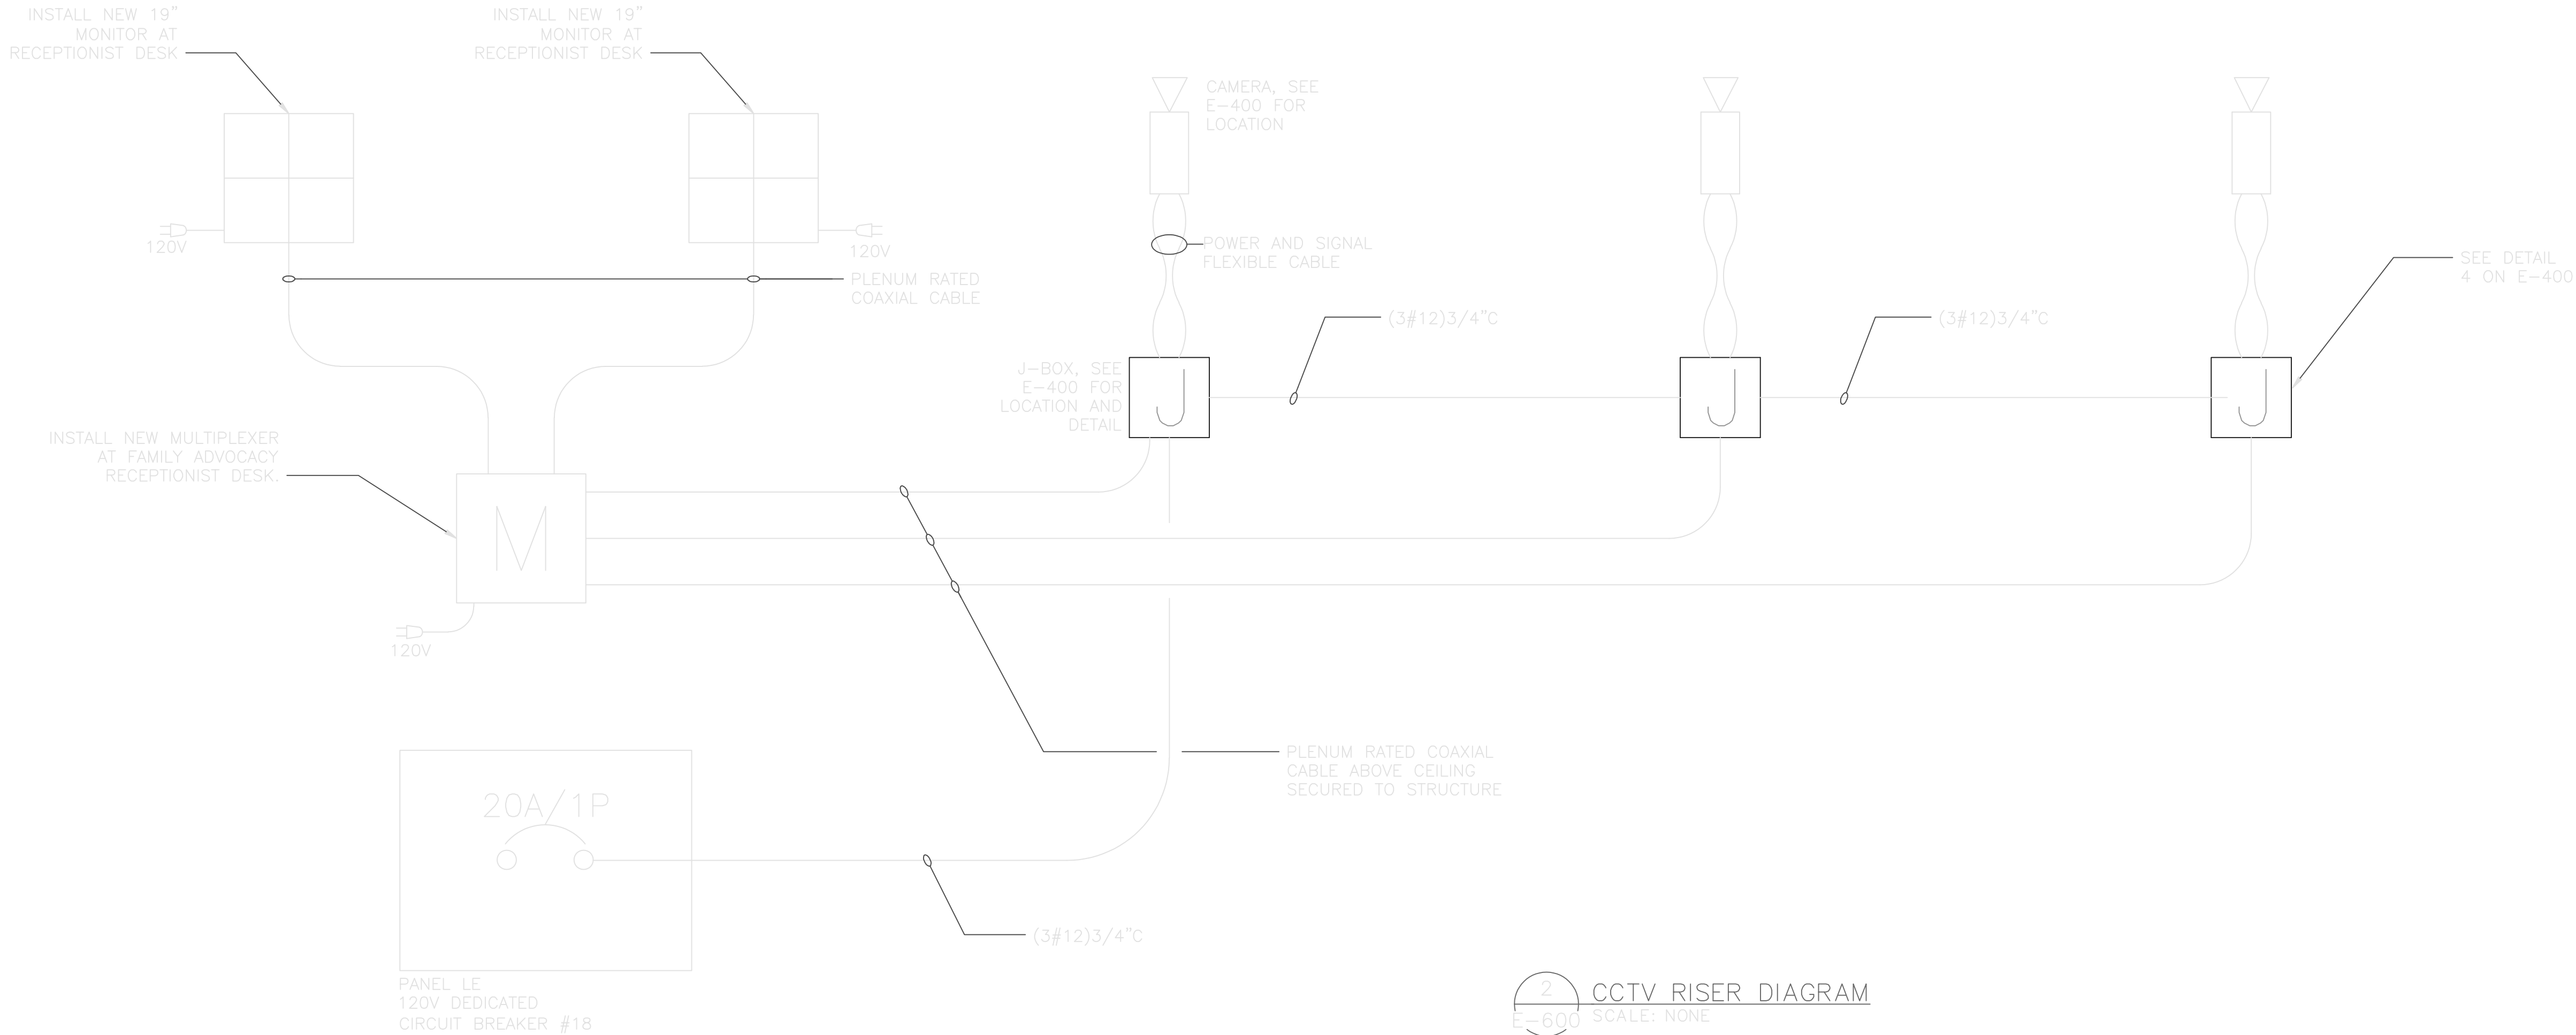

2 CCTV RISER DIAGRAM
E-600 SCALE: NONE

							APP'D
							BY
							Date
							Revision/Issue
							No.

PROJECT TITLE REPAIR MEDICAL CENTER PH B LITTLE ROCK AFB, ARKANSAS	SHEET TITLE ELECTRICAL DETAILS I	
	DRAWN BY MCL	LEAD DESIGNER ECF
	TECH REVIEWER CAG	PROJECT NUMBER NKAK 05-8004A
	DESIGNED BY ECF	SHEET
	DATE 1-21-08	E-600
SCALE AS SHOWN	20 OF 39	