

REVISIONS	DATE	DESCRIPTION	APPROVED	DATE	DESCRIPTION
1	8/07/2005	ISSUED FOR FINAL WORK PLAN			
2	10/31/2003	ISSUED FOR BID			
3	10/17/2003	AMENDMENT			

DESIGNED BY: DATE: 09/04/2003	PROJECT NO: 6503
DRAWN BY:	CHECKED BY: DRAWING CODE:
REVIEWED BY: SOLICITATION NUMBER:	

U.S. ARMY ENGINEERING AND SUPPORT CENTER  
CORPS OF ENGINEERS  
HUNTSVILLE, ALABAMA

EARTHTECH  
2000 Huntsville, AL 35894-0001

FLM  
FLM Design

RENOVATE CLINIC  
BUILDING 1090  
LITTLE ROCK AFB, ARKANSAS


**ZONE A  
HVAC POWER PLAN  
AS-BUILT**

SHEET  
REFERENCE  
NUMBER:  
**E1.24**  
SHEET X OF XX



1 PARTIAL PLAN OF AREA 'F' IN ZONE A

SCALE 1/8" = 1'-0"

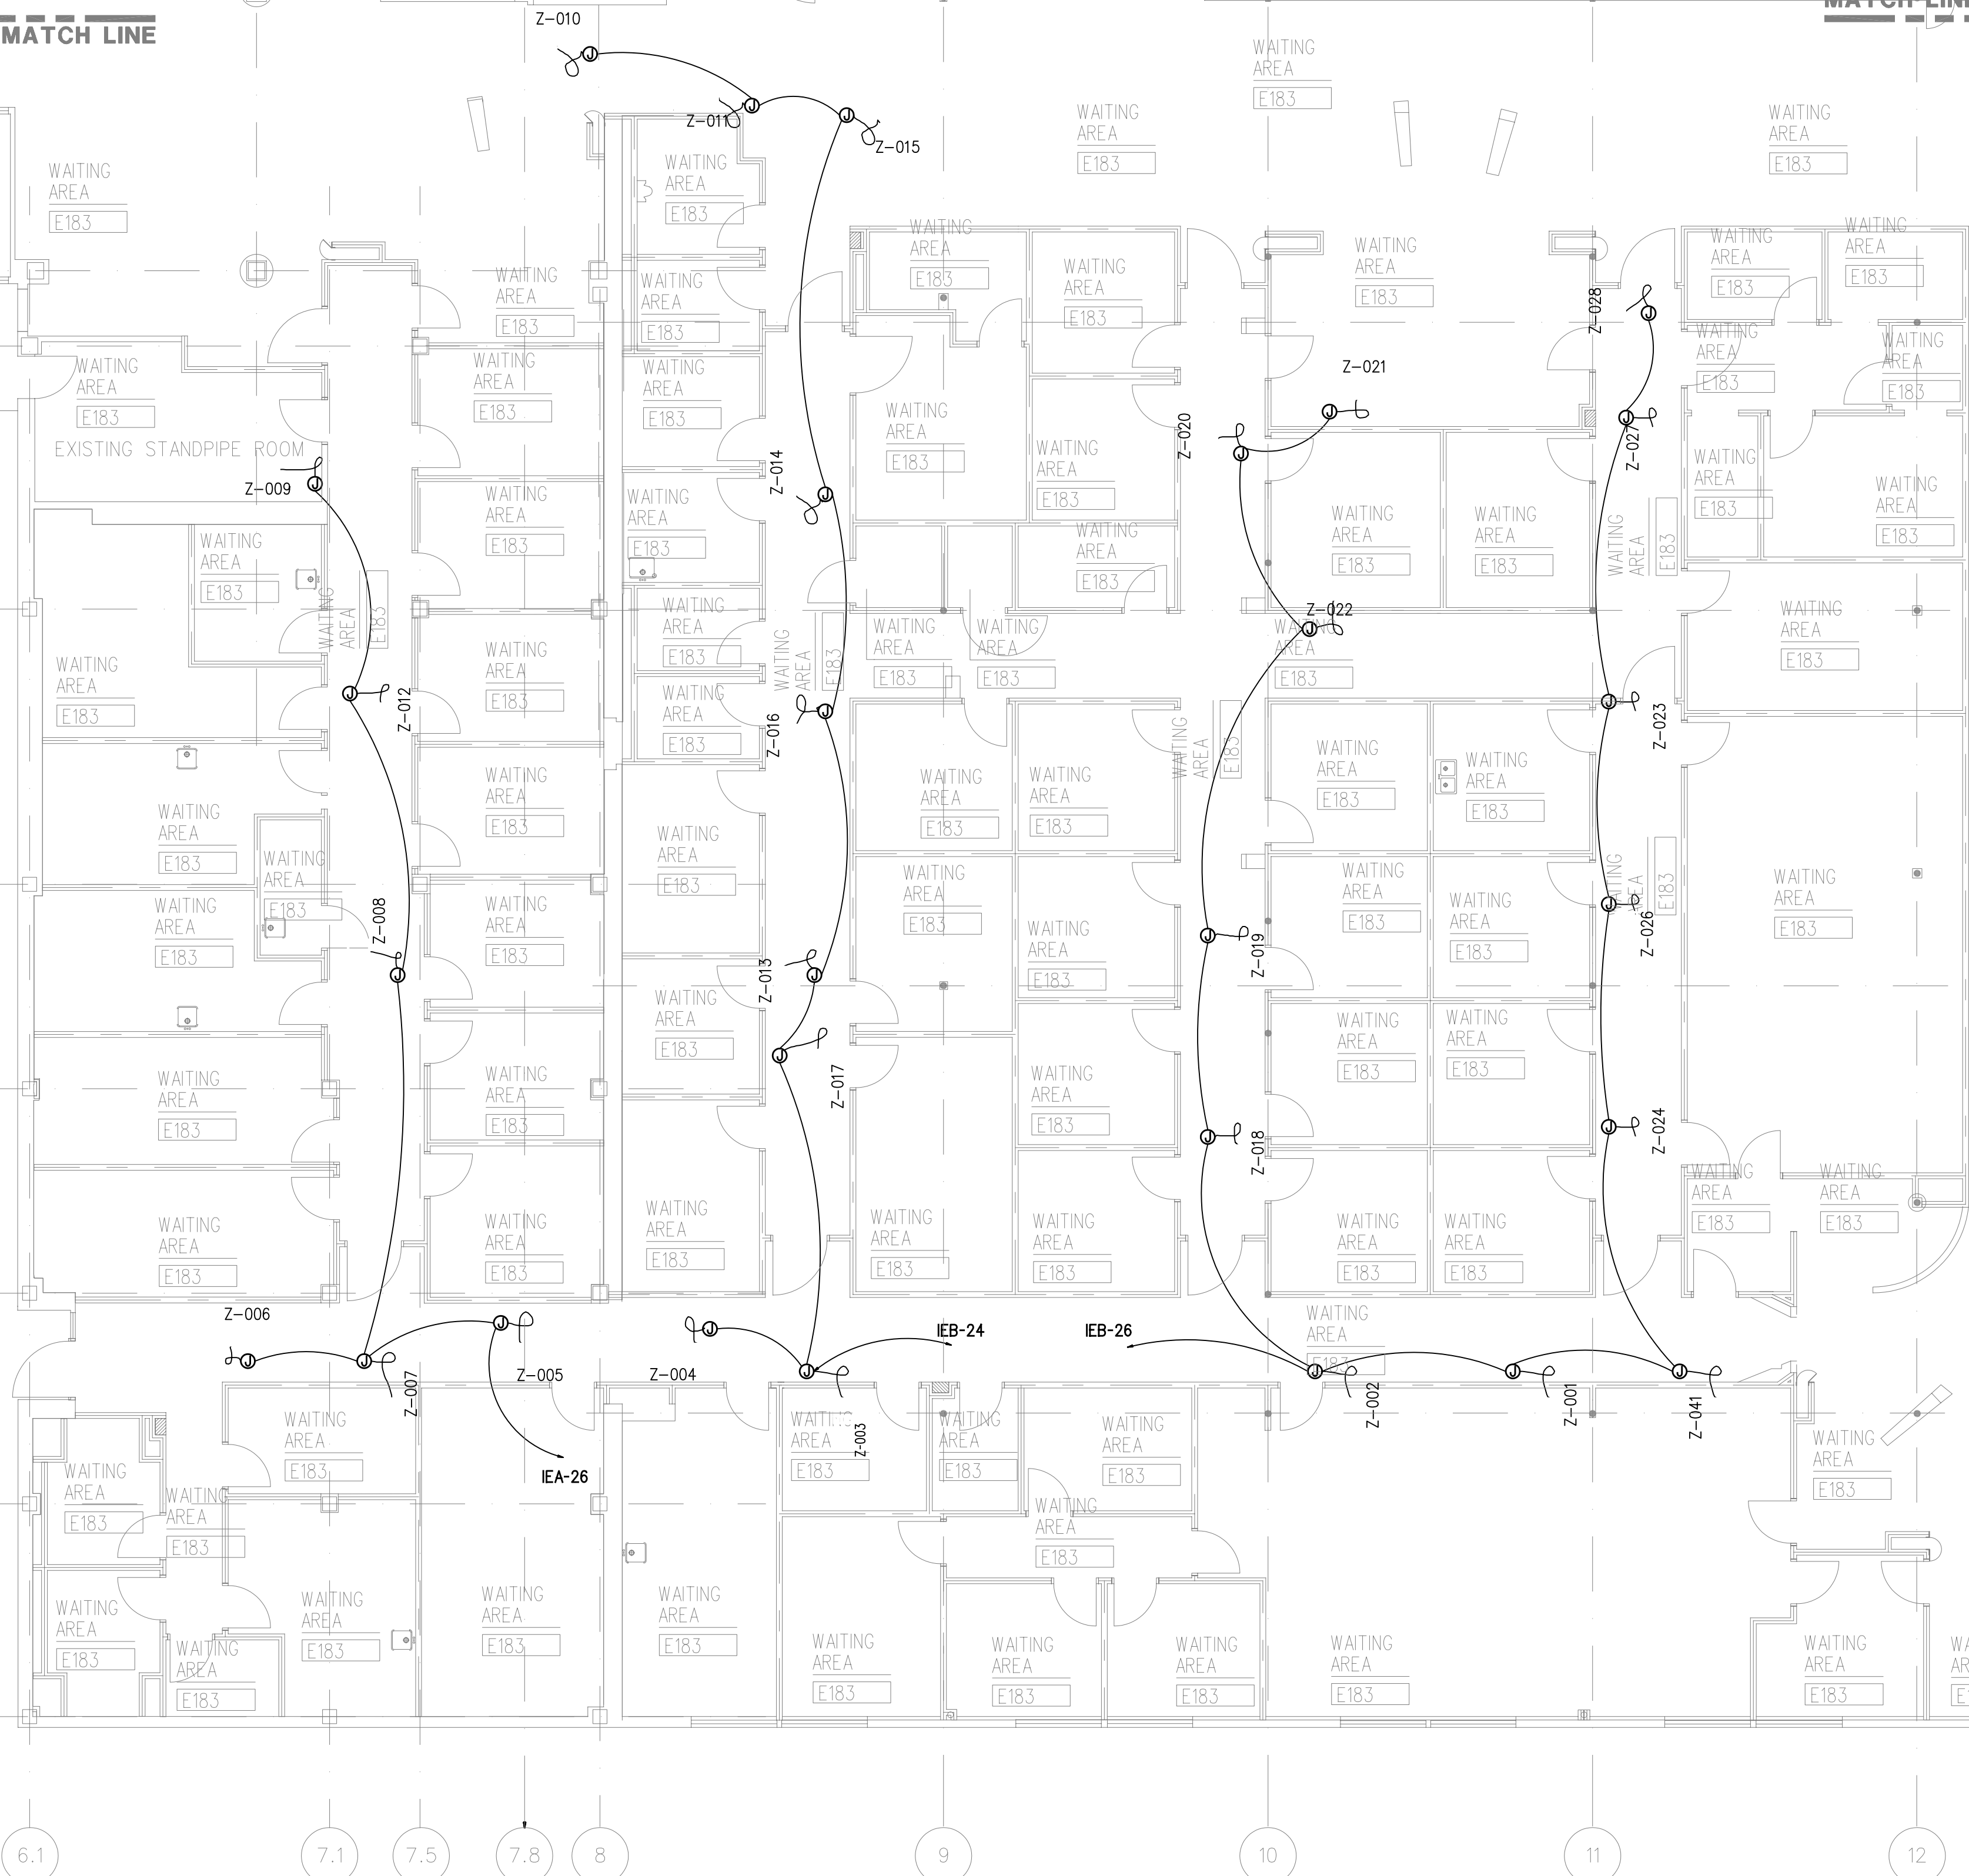


2 ZONE A PLAN

SCALE 1/8" = 1'-0"

## NOTES

1. SEE DWGS M4.11 AND M4.12 FOR TYPICAL INSTALLATION DETAILS

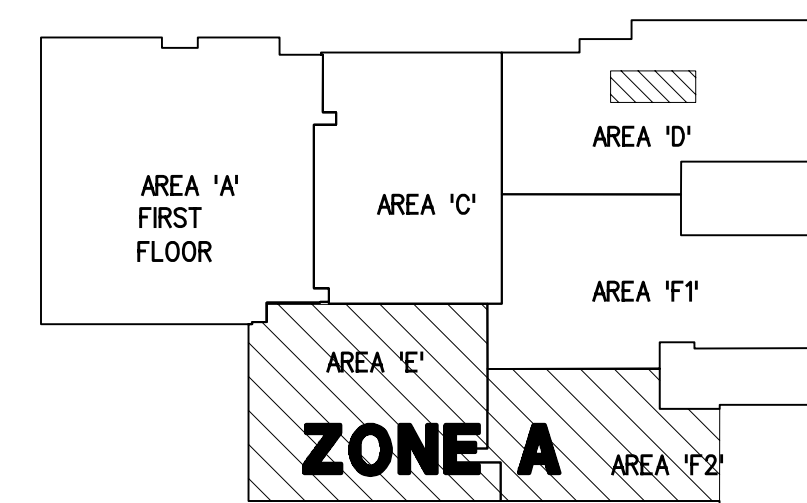

KEY PLAN

N.T.S.

SCALE

PROJECT RENOVATE CLINIC BUILDING 1090  
LITTLE ROCK AFB, ARKANSAS

DRAWING TITLE

DRAWING APPLIES TO CONTRACT DOCUMENTS, SHEETS: E1.24

PROJ. NO. 02209800 DR. BY RWH  
DATE 10/14/03 CHK. BY RWH

EARTHTECH  
FLM

SUPPLEMENTAL  
DRAWING NO.  
SD-1  
60 SHEET OF 60