






LITTLE ROCK A.F.B.
ARKANSAS

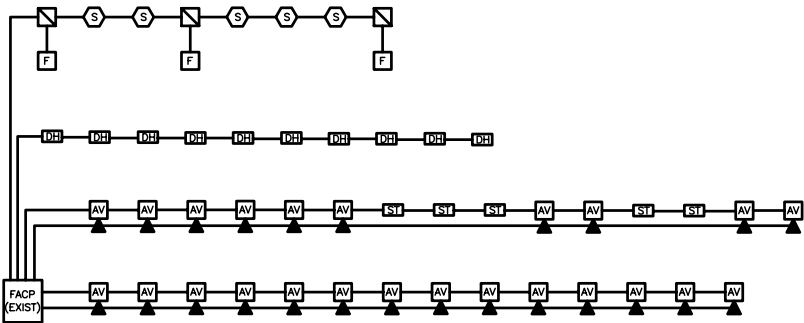


1 FIRE ALARM RISER DIAGRAM
NO SCALE

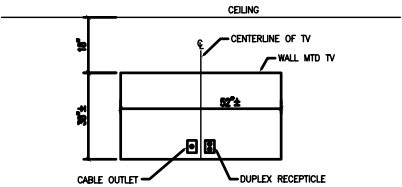


2 OUTLETS & WALL MTD. TV'S
SCALE 1/2"=1'-0"

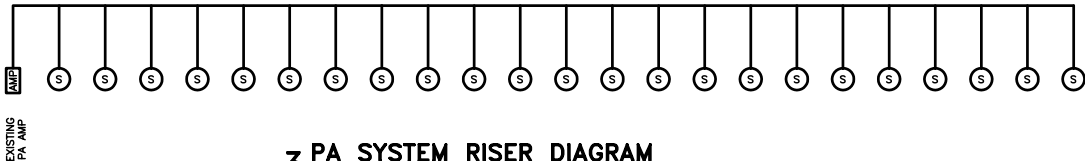


3 PA SYSTEM RISER DIAGRAM
NO SCALE

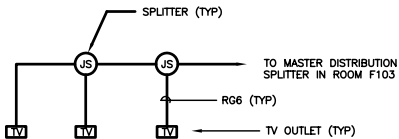

4 CATV RISER DIAGRAM
NO SCALE

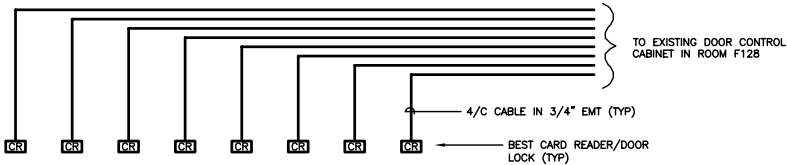

5 ELECTRIC DOOR LOCK RISER DIAGRAM
NO SCALE

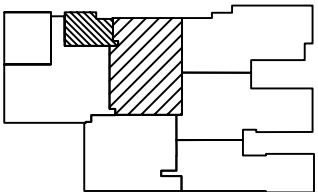

PROJECT TITLE
REPAIR MEDICAL CENTER PH 3
LITTLE ROCK AFB, ARKANSAS

SHEET TITLE
SYSTEM RISER DIAGRAM
& DETAIL

DRAWN BY RJR	LEAD DESIGNER AM
TECH REVIEWER KF	PROJECT NUMBER NKAK 06-8001
DESIGNED BY KF	SHEET E2.01
DATE 8-11-06	
SCALE 1/8"=1"	35 of 37