

REVISIONS AS-BUILT	DATE	SYMBOL	DESCRIPTION
1	8/07/2003		ISSUED FOR FINAL WORK PLAN
2	10/17/2003		ISSUED FOR BID

DESIGNED BY: DATE: 08/04/2003	PROJECT NO: 6503
DRAWN BY:	CHECKED BY: DRAWING CODE:
REVIEWED BY: SOLICITATION NUMBER:	


U.S. ARMY ENGINEERING AND SUPPORT CENTER
CORPS OF ENGINEERS
HUNTSVILLE, ALABAMA

FIRE PROTECTION PLAN

RENOVATE CLINIC
BUILDING 1090
LITTLE ROCK AFB, ARKANSAS

AS-BUILT


SHEET
REFERENCE
NUMBER:
FP1.00
SHEET X OF XX

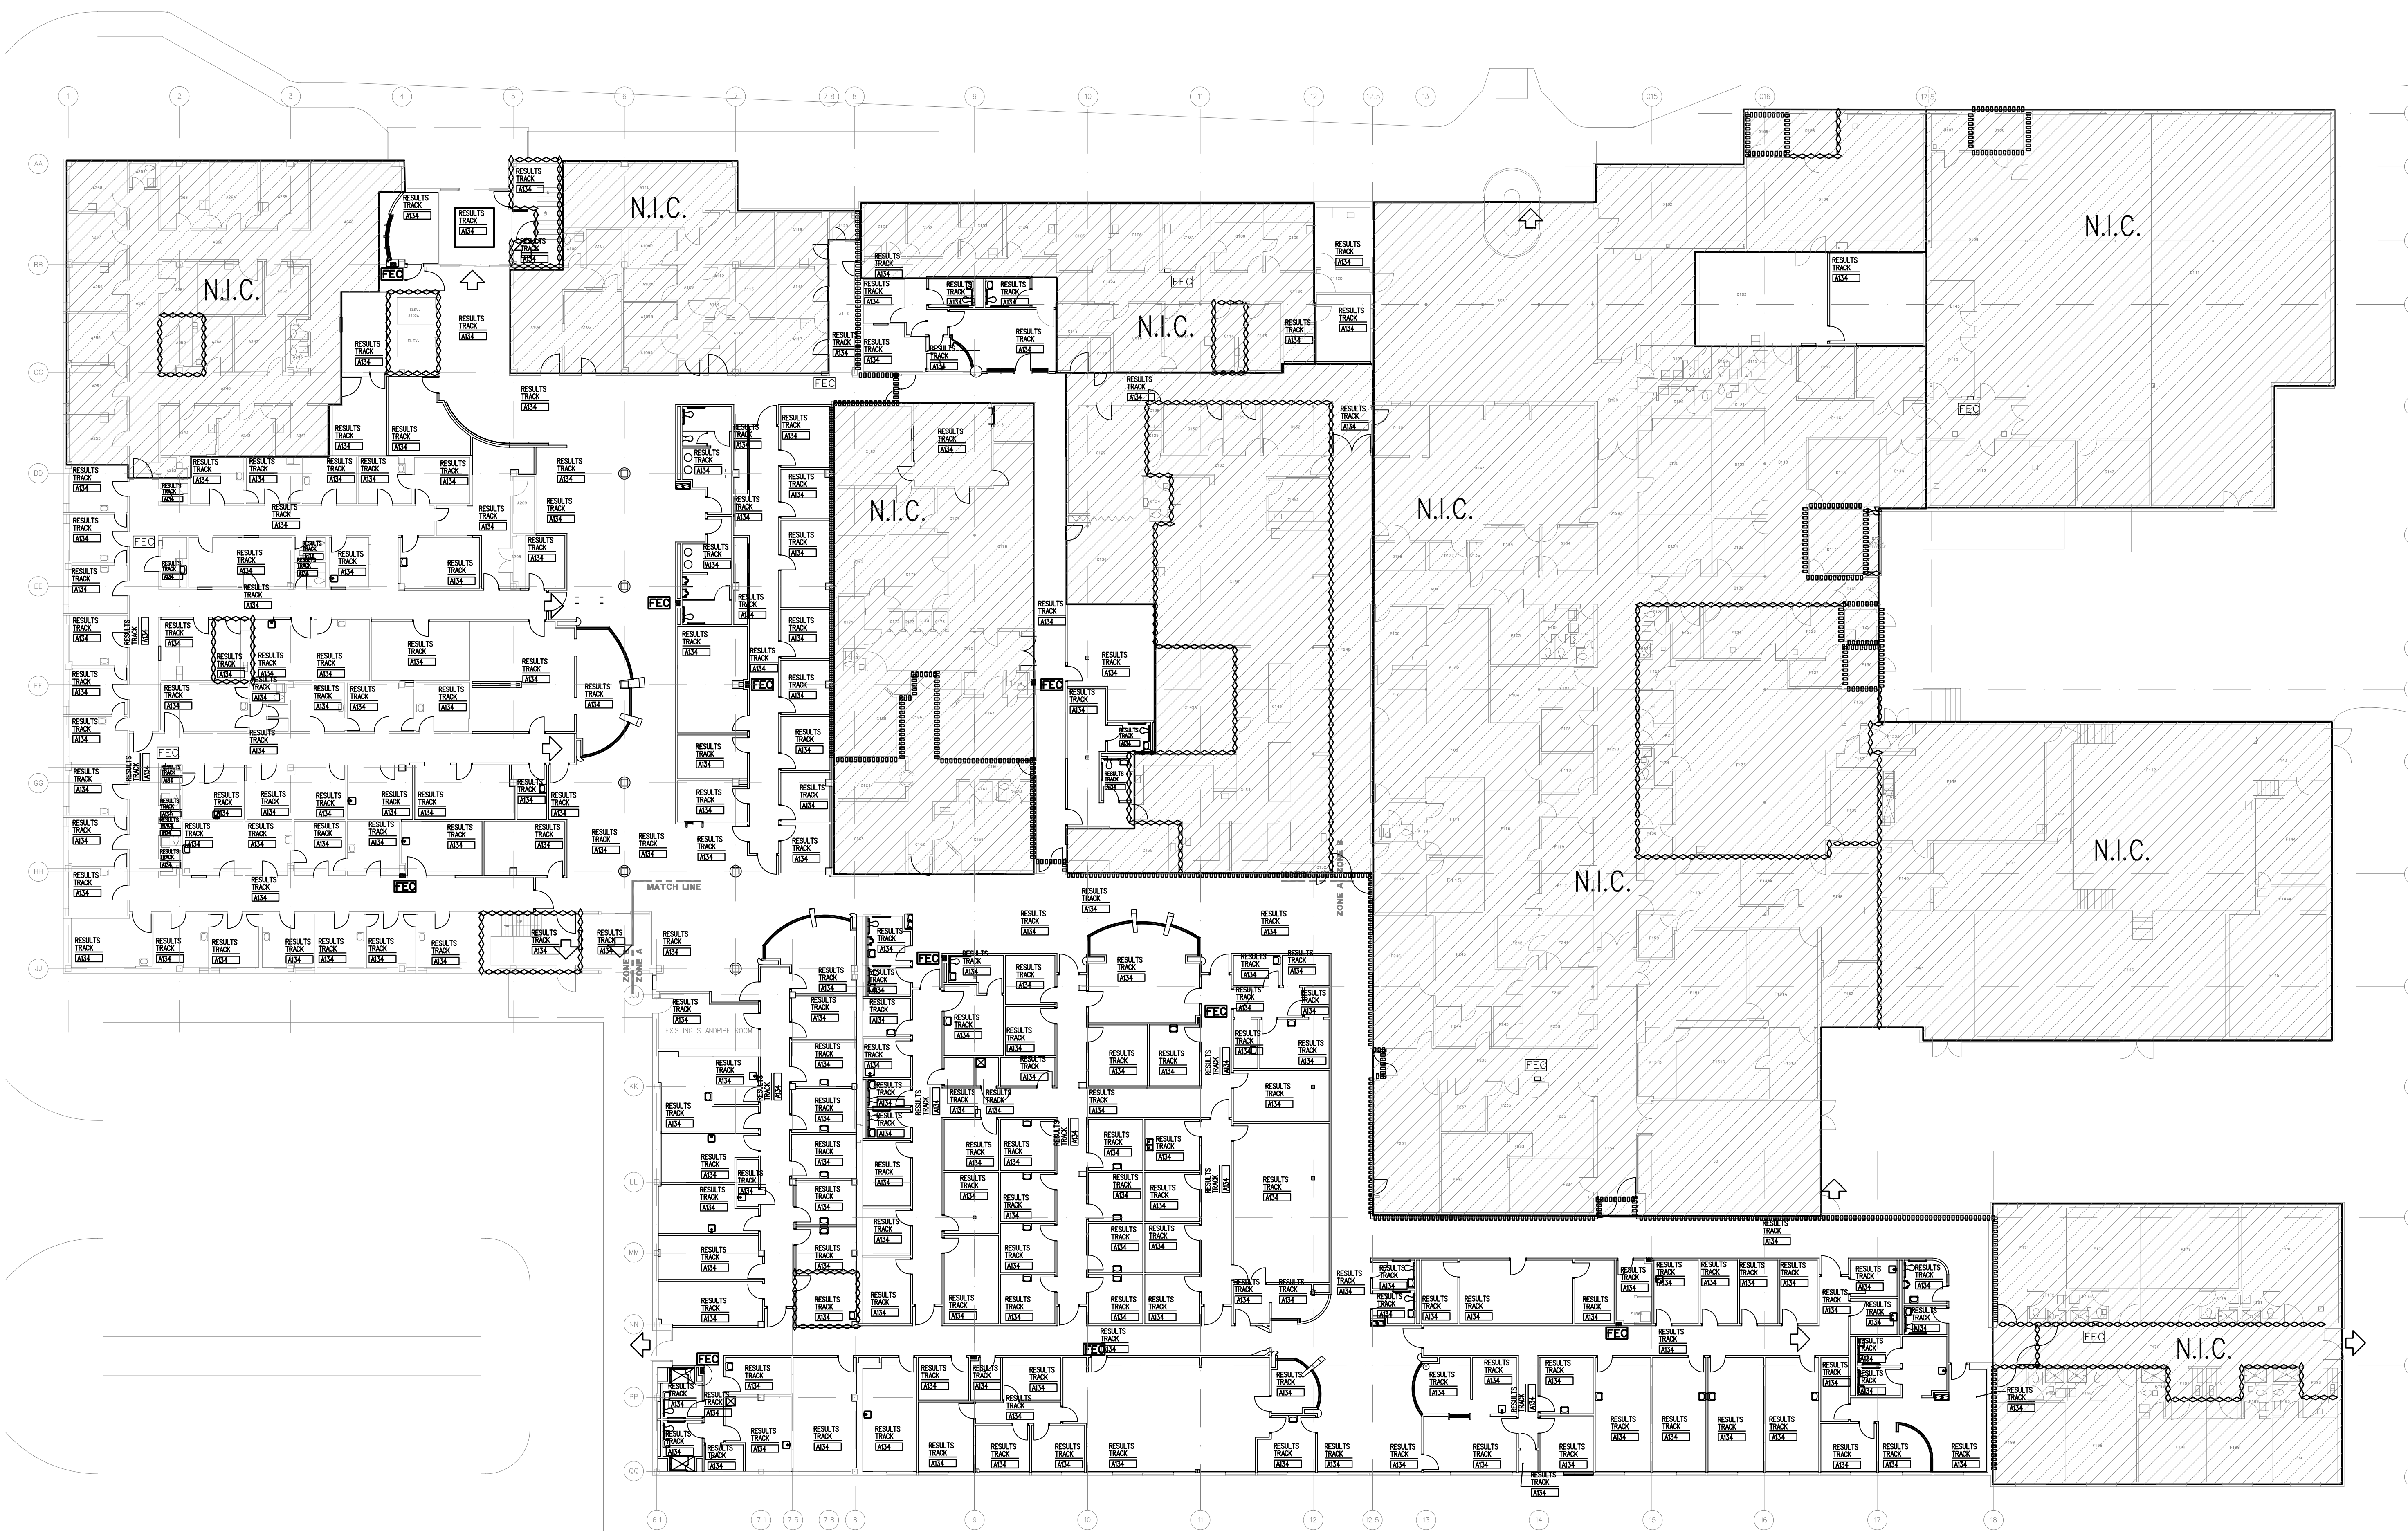

PLAN LEGEND


- NEW 1 HOUR FIRE
- EXISTING 2 HOUR FIRE
- "NOT IN CONTRACT" (OUTSIDE OF PROJECT SCOPE)
- 90 MIN. DOOR RATING (IN MINUTES)
- FIRE EXTINGUISHER CABINET
- FIRE EXTINGUISHER
- EXIT SIGN

ZONE B WORK DELETED FROM SCOPE OF PROJECT

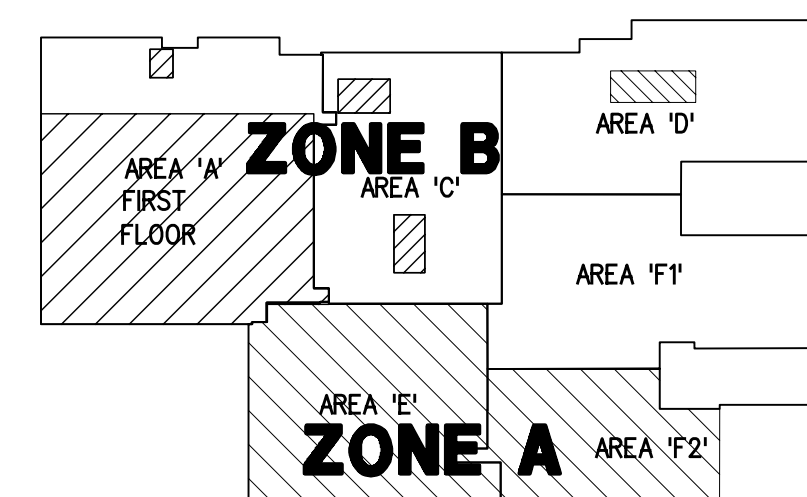

KEY PLAN

N.T.S.

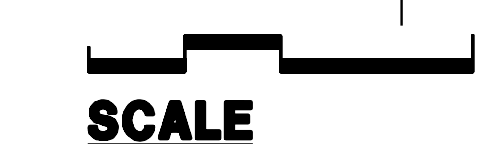

SCALE