

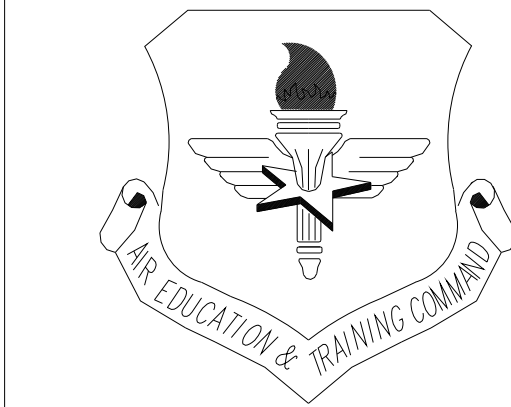


REPAIR MEDICAL CENTER B1090 PHASE B

LITTLE ROCK AFB, ARKANSAS
FA8903-04-D-8687
NKAK 05-8004A

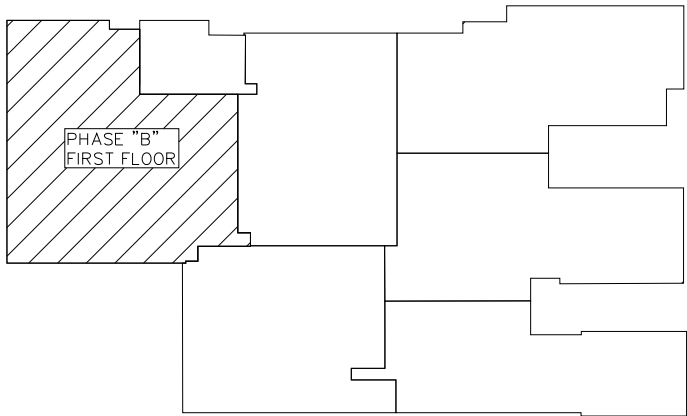

SHEET No.			DWG No.			TITLE - SHEET DESCRIPTION		
1	C0.00	COVER SHEET	21	M0.00	SYMBOLS, LEGENDS & GENERAL NOTES			
2	G0.00	PROJECT LOCATION PLAN	22	M0.01	SPACE LOADS & AIR FLOWS SCHEDULE			
3	G0.11	LIFE SAFETY PLAN	23	M0.11	HVAC DEMOLITION PLAN			
			24	M1.11	HVAC PLAN			
4	A0.00	ARCHITECTURAL SYMBOLS						
5	A0.11	DEMOLITION PLAN	25	FP0.11	FIRE PROTECTION AUTOMATIC SPRINKLER DEMOLITION PLAN			
6	A1.11	FLOOR PLAN	26	FP1.11	FIRE PROTECTION AUTOMATIC SPRINKLER INSTALLATION PLAN			
7	A2.11	REFLECTED CEILING PLAN						
8	A3.10	ENLARGED FLOOR PLANS	27	P1.11	SANITARY PLAN			
9	A3.20	INTERIOR TOILET ROOM ELEVATIONS	28	P1.12	ENLARGED PLUMBING PLAN & SANITARY RISER DIAGRAM			
10	A3.30	INTERIOR ELEVATIONS	29	P1.13	ENLARGED PLUMBING PLAN & SANITARY RISER DIAGRAM			
11	A4.10	DOOR SCHEDULE						
12	A4.11	FINISH SCHEDULE	30	E0.00	ABBREVIATIONS, SYMBOLS, & GENERAL NOTES			
13	A4.12	FINISH SCHEDULE	31	E0.11	LIGHTING DEMOLITION PLAN			
14	A4.20	FINISH PLAN	32	E0.21	POWER DEMOLITION PLAN			
15	A5.10	DOORS, FRAMES, PARTITION TYPES	33	E0.31	SYSTEMS DEMOLITION PLAN			
16	A5.11	ARCHITECTURAL DETAILS	34	E1.11	LIGHTING PLAN			
17	A5.20	CEILING DETAILS	35	E1.21	POWER PLAN			
			36	E1.31	ELECTRICAL SYSTEM PLAN			
18	Q0.00	TYPICAL MOUNTING HEIGHTS	37	E2.01	SYSTEM RISER DIAGRAM & DETAILS			
19	Q1.10	ENLARGED COUNTERTOP PLANS	38	E3.11	LIGHTING SCHEDULES & DETAILS			
			39	E4.01	PANEL SCHEDULES			
20	F1.11	FURNITURE PLAN						

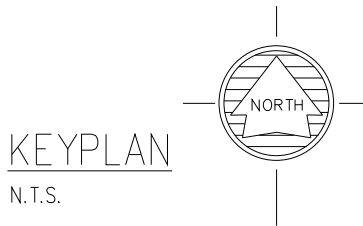

LITTLE ROCK A.F.B.
ARKANSAS

FPM
804 West Curtis Drive, Suite H
Midwest City, OK 73110
phone: 405.869.9212
fax: 405.869.9222
www.fpm-group.com

RECORD
DRAWINGS
MARCH 2007

							APP'D
							BY
							Date
							Revision/Issue
							No.

PROJECT TITLE REPAIR MEDICAL CENTER PH B LITTLE ROCK AFB, ARKANSAS		SHEET TITLE COVER SHEET	
DRAWN BY RJR	LEAD DESIGNER AM		
TECH REVIEWER AM	PROJECT NUMBER NKAK 05-8004		
DESIGNED BY AM	SHEET C0.00		
DATE 1-21-08			
SCALE 1/8"=1'-0"	1 OF 3		