


LITTLE ROCK AIR FORCE BASE, ARKANSAS

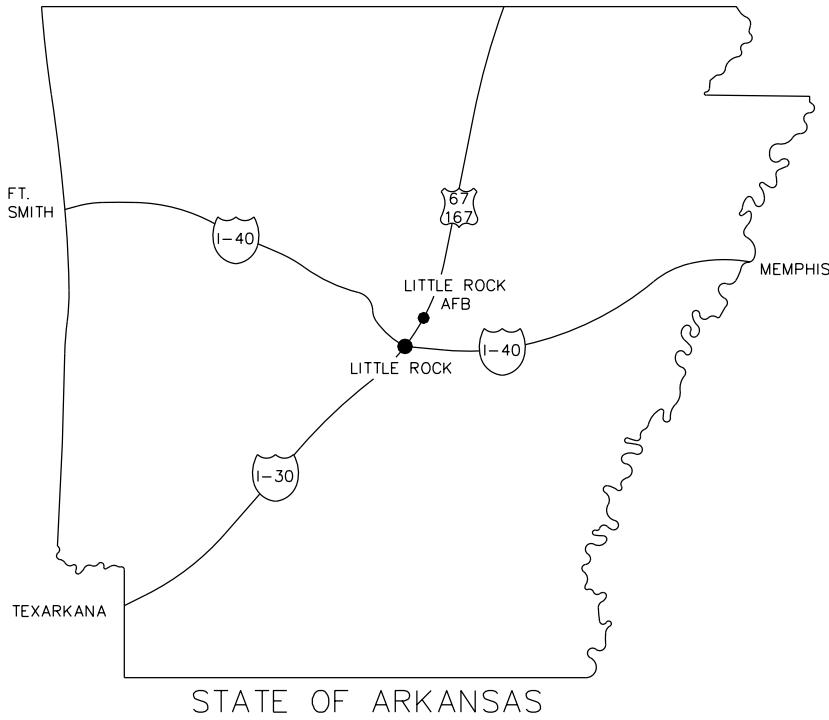

LOCATION PLAN

THE APPROVAL AND COORDINATION SIGNATURES APPEARING IN THE TITLE BLOCK ON THIS SHEET CONSTITUTE APPROVAL OF ALL DRAWINGS LISTED IN THE INDEX.



GOVERNING CODES
2003 INTERNATIONAL BUILDING CODE
2002 ARKANSAS FIRE PROTECTION CODE
NFPA 101
UNIFIED FEDERAL CRITERIA #4-510-01
MILITARY HANDBOOK #1191

GENERAL	
G-001	COVER SHEET
G-002	KEY PLAN, CODE STUDY & SYMBOLS LEGEND
ARCHITECTURAL	
A-101-A	FLOOR PLAN
A-101-D	DEMOLITION PLAN
A-101-R	REFLECTED CEILING PLAN & DETAILS
A-102	ENLARGED FLOOR PLAN & INTERIOR ELEVATIONS
A-501	WALL TYPES & INTERIOR DETAILS
A-502	MILLWORK SECTIONS & INTERIOR DETAILS
A-601	FINISH SCHEDULE
A-602	DOOR SCHEDULE, DOOR & WINDOW TYPES, DETAILS
ELECTRICAL	
E-001	ELECTRICAL LEGEND
E-101	ELECTRICAL LIGHTING DEMOLITION PLAN
E-102	ELECTRICAL POWER DEMOLITION PLAN
E-103	ELECTRICAL FIRE ALARM COMMUNICATION DEMOLITION PLAN
E-200	ELECTRICAL LIGHTING INSTALLATION PLAN
E-300	ELECTRICAL POWER INSTALLATION PLAN
E-400	ELECTRICAL FIRE ALARM/COMMUNICATION INSTALLATION PLAN
E-500	ELECTRICAL ONELINE
E-600	ELECTRICAL DETAILS I
E-601	ELECTRICAL DETAILS II
FIRE PROTECTION	
F-101	FIRE PROTECTION INSTALLATION PLAN
INTERIORS	
I-101	FLOOR PATTERN PLAN & WALL PROTECTION PLAN
MECHANICAL	
M-001	MECHANICAL LEGEND AND ABBREVIATIONS
M-101	MECHANICAL ROOF MECHANICAL PLAN
M-102	MECHANICAL OVERALL FLOOR PLAN
M-103	AHU-II , AHU-III , S-4 AND AHU-V ENERGY ANALYSIS
M-201	PARTIAL FIRST FLOOR MECHANICAL PLAN S-4 - SUPPLY COOLING DUCT
M-202	PARTIAL FIRST FLOOR MECHANICAL PLAN S-4 - HEAT SUPPLY DUCT
M-203	PARTIAL FIRST FLOOR MECHANICAL PLAN S-4 - RETURN DUCT
M-204	PARTIAL FIRST FLOOR MECHANICAL PLAN S-4 - EXHAUST DUCT
M-205	PARTIAL FIRST FLOOR AREA SERVED BY S-4 AHU AIR BALANCE DATA
M-301	SECOND FLOOR MECHANICAL PLAN SUPPLY DUCT
M-302	SECOND FLOOR MECHANICAL PLAN RETURN DUCT
M-303	SECOND FLOOR MECHANICAL PLAN EXHAUST DUCT
M-304	SECOND FLOOR AREAS SERVICED BY AHU-V AIR BALANCE DATA
M-305	SECOND FLOOR AREAS SERVICED BY AHU-V AIR BALANCE DATA
M-401	MECHANICAL S-4 DETAILS
M-402	MECHANICAL S-4 SCHEDULE & DETAILS
M-403	MECHANICAL AHU-V SCHEDULE & DETAILS
M-404	MACHANICAL SCHEDULES
MS-101	SPECIFICATIONS
MS-201	SPECIFICATIONS
PLUMBING	
P-101	PLUMBING DEMOLITION PLAN
P-201	PLUMBING INSTALLATION PLAN



LITTLE ROCK A.F.B.
ARKANSAS

MTE MIKE TRUSTY
ENGINEERING
PHONE: (501)224-9013
FAX: (501)421-0151
miketrusty@msn.com

PROJECT TITLE
REPAIR & RENOVATE MEDICAL CLINIC PH V
LITTLE ROCK AIR FORCE BASE
JACKSONVILLE, ARKANSAS
CHANGE ORDER TO PHASE V - 100% SUBMITTAL

SHEET TITLE
COVER SHEET

DRAWN BY GMT	LEAD DESIGNER GMT
TECH REVIEWER	PROJECT NUMBER NKAK#06-8006-5
DESIGNED BY GMT	SHEET
DATE DEC. 3, 2010	G-001
SCALE AS SHOWN	01 of 21

AS-BUILT