



# LITTLE ROCK AIR FORCE BASE, ARKANSAS

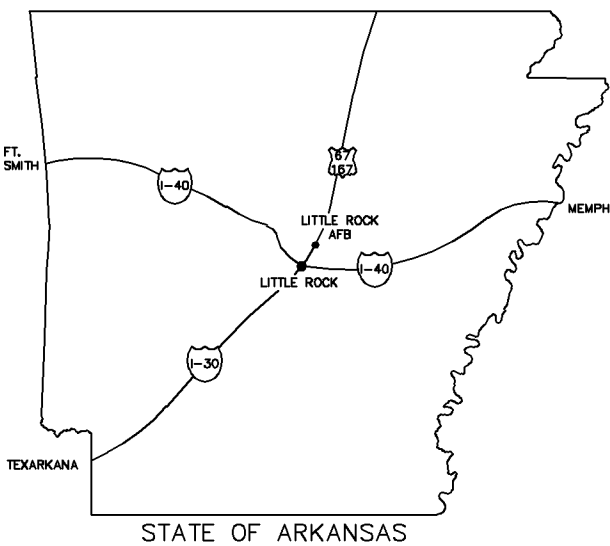

GOVERNING CODES  
UNIFIED FEDERAL CRITERIA DESIGN GUIDELINES  
UFC 1-200-01 (GENERAL REQUIREMENTS)  
UFC 4-010-01 (DoD MIN ANTI-TERRORISM STANDARDS FOR BUILDINGS)  
UFC 4-510-01  
UFC 3-600-01 (MIL HNBK 1013-1A FOR PHARMACY)  
2006 INTERNATIONAL BUILDING CODE  
2007 ARKANSAS FIRE PROTECTION CODE

## INDEX

| SHEET NO. | TITLE  |
|-----------|--|
| G-001     | COVER SHEET  |
| G-002     | KEY PLAN, CODE STUDY & SYMBOLS & ABBREVIATIONS     |
| G-003     | PHASING AREA "A"                                   |
| G-004     | PHASING AREA "C"                                   |
| A-101-D   | DEMOLITION PLAN-AREA "A"                           |
| A-101-A   | FLOOR PLAN-AREA "A"                                |
| A-101-R   | REFLECTED CEILING PLAN-AREA "A"                    |
| A-102-D   | DEMOLITION PLAN-AREA "B"                           |
| A-102-A   | FLOOR PLAN-AREA "B"                                |
| A-102-R   | REFLECTED CEILING PLAN-AREA "B"                    |
| A-103     | ENLARGED FLOOR PLAN AND ELEVATIONS @ COUNTER       |
| A-104     | ENLARGED EQUIPMENT PLAN, ELEVATIONS AND SECTIONS   |
| A-201     | ELEVATIONS AND SECTIONS AT VESTIBULE & LOBBY       |
| A-202     | INTERIOR ELEVATIONS AND MISC MILLWORK ELEVATIONS   |
| A-501     | WALL TYPES & DETAILS                               |
| A-502     | DISPENSING COUNTER MILLWORK SECTIONS               |
| A-503     | MILLWORK SECTIONS                                  |
| A-601     | FINISH SCHEDULE                                    |
| A-602     | DOOR SCHEDULE, DOOR TYPES & DETAILS                |
| I-101     | FLOORING PATTERN AND WALL PROTECTION PLAN-AREA "A" |
| I-102     | FLOORING PATTERN AND WALL PROTECTION PLAN-AREA "B" |
| S-001     | STRUCTURAL GENERAL NOTES                           |
| S-101     | STRUCTURAL FOUNDATION & FRAMING PLANS              |
| S-401     | STRUCTURAL FOUNDATION SECTIONS                     |
| S-402     | MISCELLANEOUS CONCRETE DETAILS                     |
| S-501     | STRUCTURAL FRAMING SECTIONS                        |
| S-601     | MISCELLANEOUS MASONRY DETAILS                      |
| M-001     | MECHANICAL LEGEND & ABBREVIATIONS                  |
| M-101     | MECHANICAL DEMOLITION PLAN                         |
| M-201     | MECHANICAL INSTALLATION PLAN                       |
| M-202     | MECHANICAL ROOF INSTALLATION PLAN                  |
| M-301     | MECHANICAL SCHEDULES AND DETAILS I                 |
| M-302     | MECHANICAL SCHEDULES AND DETAILS II                |
| P-101     | PLUMBING DEMOLITION PLAN                           |
| P-201     | PLUMBING INSTALLATION PLAN                         |
| P-301     | PLUMBING SCHEDULES & DETAILS                       |
| F-101     | FIRE PROTECTION DEMOLITION PLAN                    |
| F-201     | FIRE PROTECTION INSTALLATION PLAN                  |
| E-001     | ELECTRICAL LEGEND AND ABBREVIATIONS                |
| E-002     | ELECTRICAL SITE PLAN                               |
| E-101     | ELECTRICAL POWER DEMOLITION PLAN                   |
| E-102     | ELECTRICAL LIGHTING DEMOLITION PLAN                |
| E-103     | TELECOMMUNICATIONS DEMOLITION PLAN                 |
| E-201     | ELECTRICAL POWER INSTALLATION PLAN                 |
| E-202     | ELECTRICAL LIGHTING INSTALLATION PLAN              |
| E-203     | TELECOMMUNICATIONS INSTALLATION PLAN               |
| E-301     | ELECTRICAL ONE-LINE REMOVAL DIAGRAM                |
| E-302     | ELECTRICAL ONE-LINE INSTALLATION PLAN              |
| E-303     | ELECTRICAL DETAILS I                               |
| E-304     | ELECTRICAL DETAILS II                              |
| E-305     | ELECTRICAL DETAILS III                             |

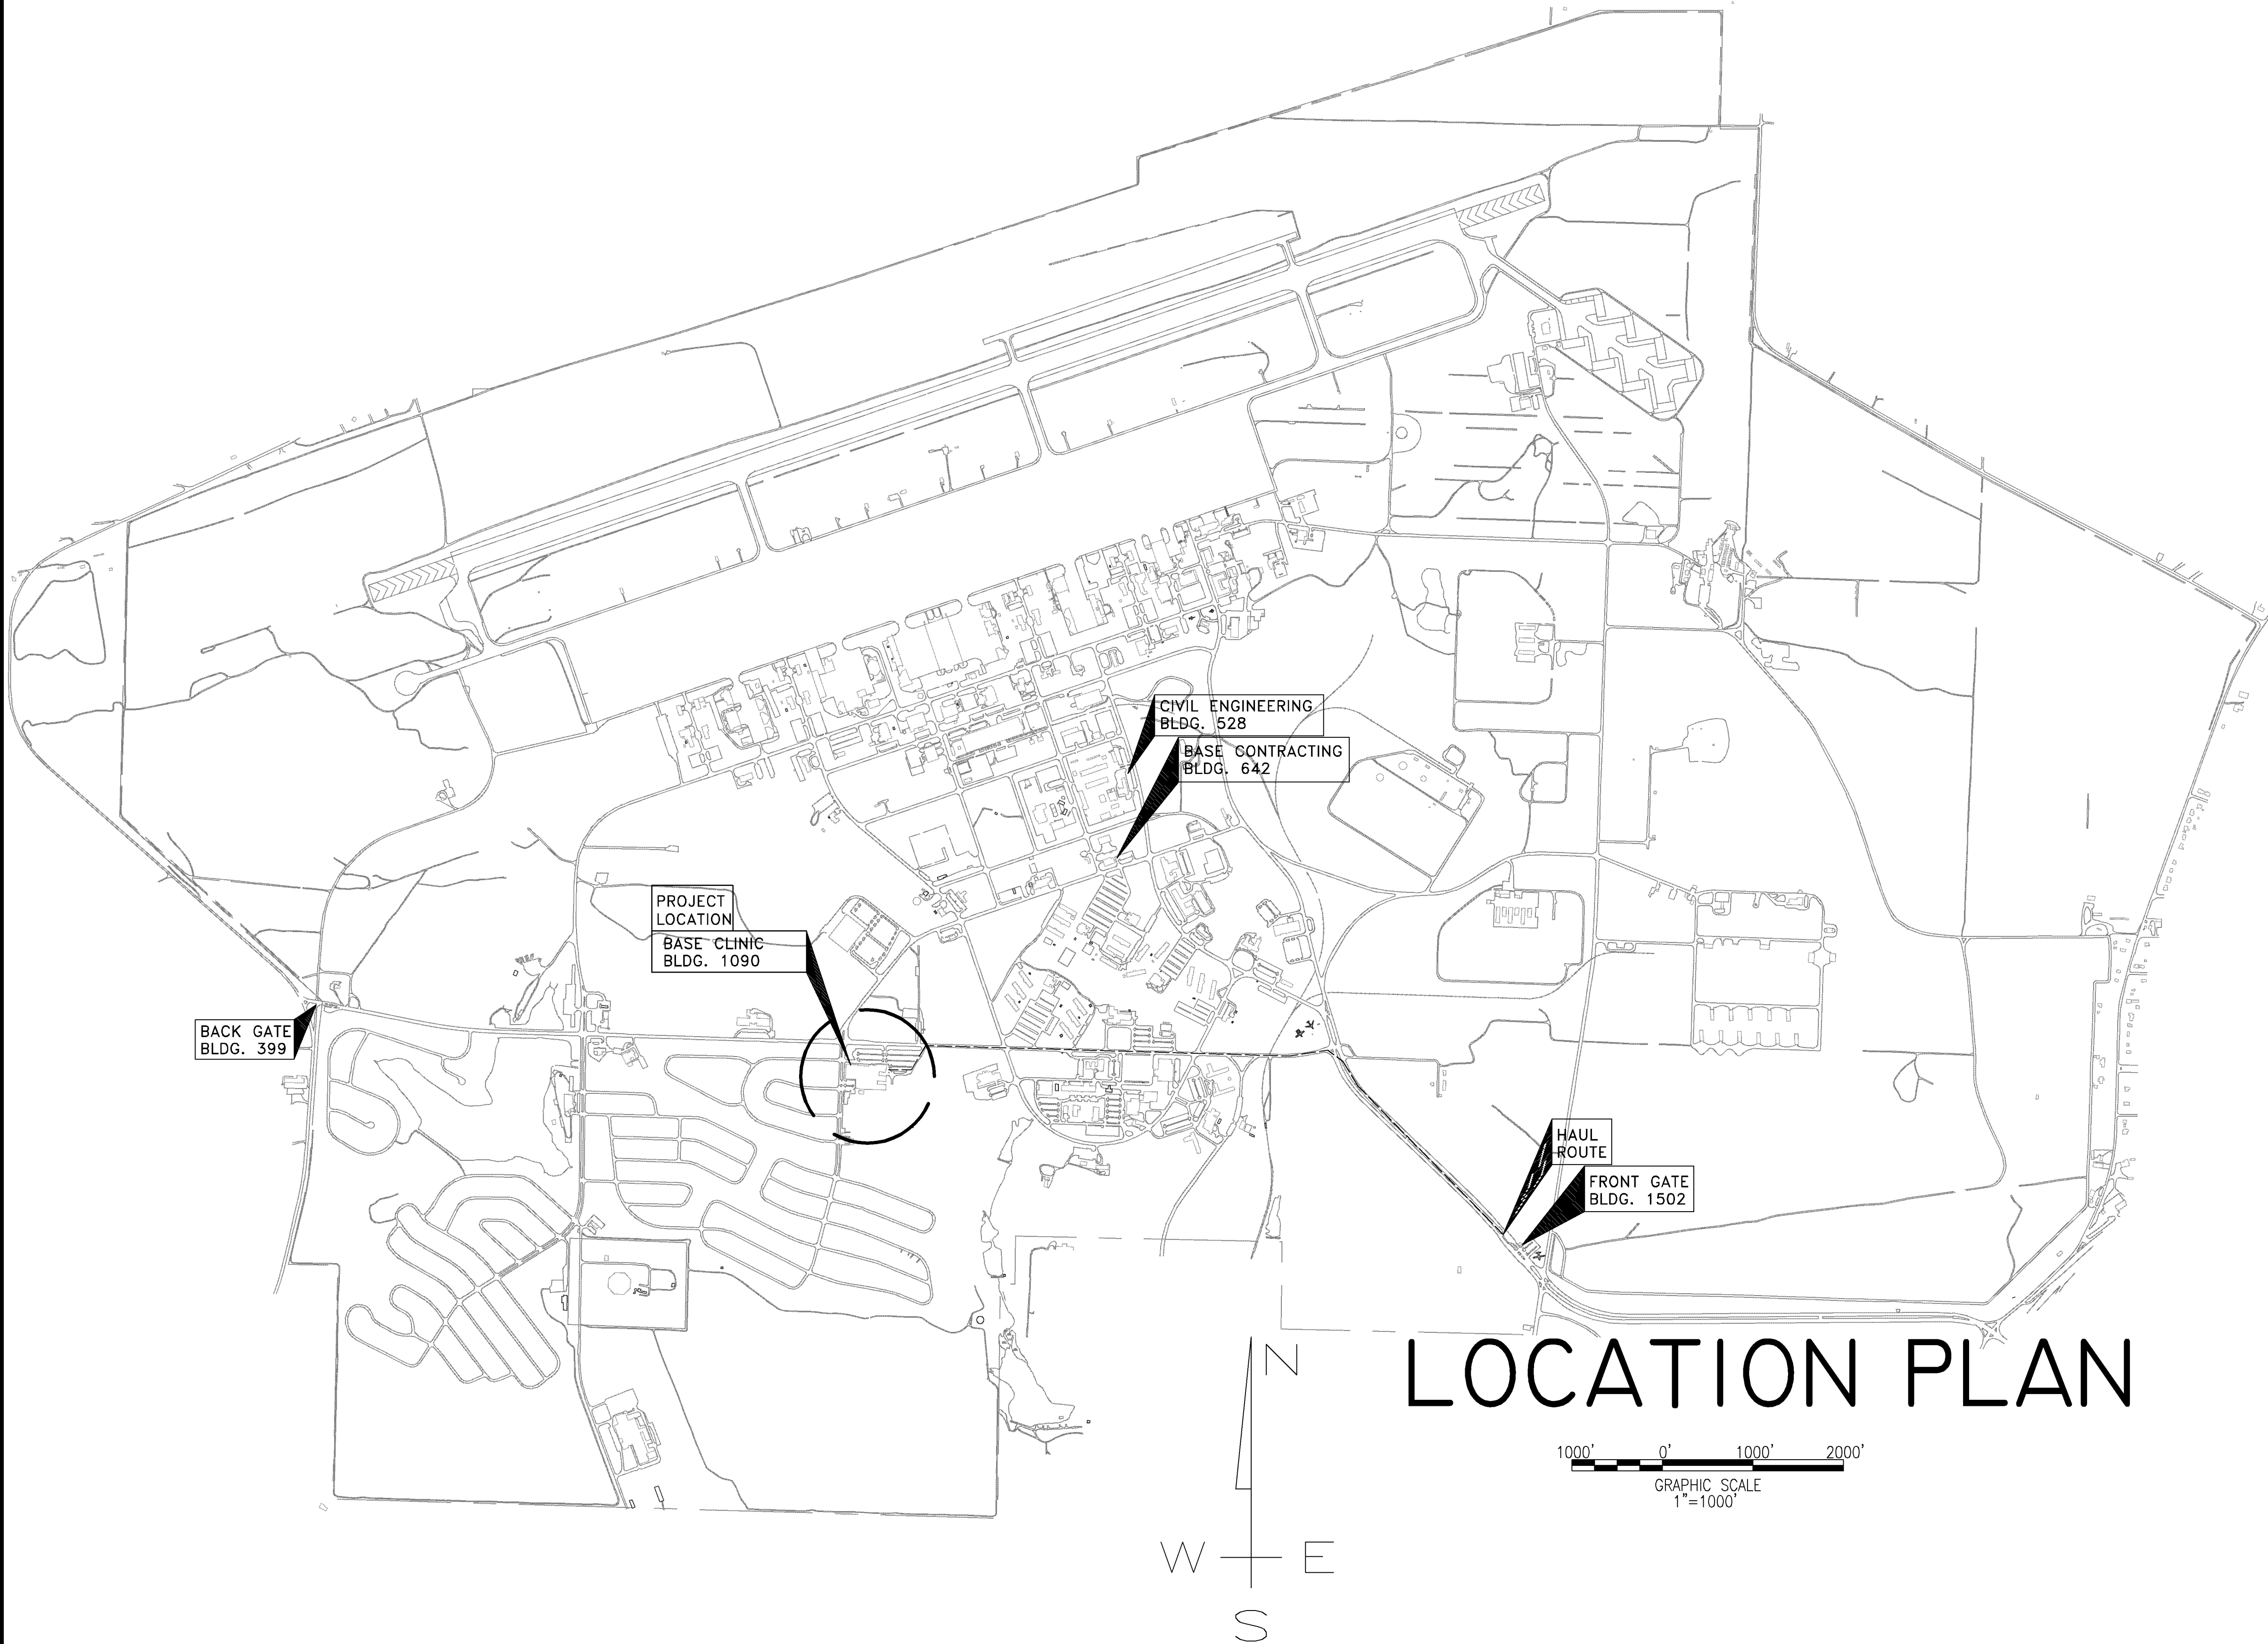

LITTLE ROCK A.F.B.  
ARKANSAS

**GARVER** 1010 Battery St.  
Little Rock, AR  
72202  
501-376-3633

www.GarverUSA.com

**CROMWELL**  
ARCHITECTS ENGINEERS

101 SOUTH SPRING ST  
LITTLE ROCK AR 72201  
TELEPHONE 501-372-2900  
FACSIMILE 501-372-0482

|  |  |  |  |  |  |                |
|--|--|--|--|--|--|----------------|
|  |  |  |  |  |  | APP'D          |
|  |  |  |  |  |  | BY             |
|  |  |  |  |  |  | Date           |
|  |  |  |  |  |  | Revision/Issue |
|  |  |  |  |  |  | No.            |

PROJECT TITLE  
REPAIR & RENOVATE MED. CLINIC PH IV A  
LITTLE ROCK AIR FORCE BASE  
JACKSONVILLE, ARKANSAS

SHEET TITLE  
COVER SHEET

|                      |                                   |
|----------------------|-----------------------------------|
| DRAWN BY<br>JKL      | LEAD DESIGNER<br>K. TAYLOR        |
| TECH REVIEWER<br>JKL | PROJECT NUMBER<br>NKAK 06-8006 4A |
| DESIGNED BY<br>JKL   | SHEET<br>G-001                    |
| DATE<br>13 MAY 2009  |                                   |
| SCALE                | 1 of 51                           |