




1 ENLARGED PLUMBING PLAN (ROOMS A103, A121, A124, A234, A235 AND A238)
SCALE: 1/4" = 1'-0"

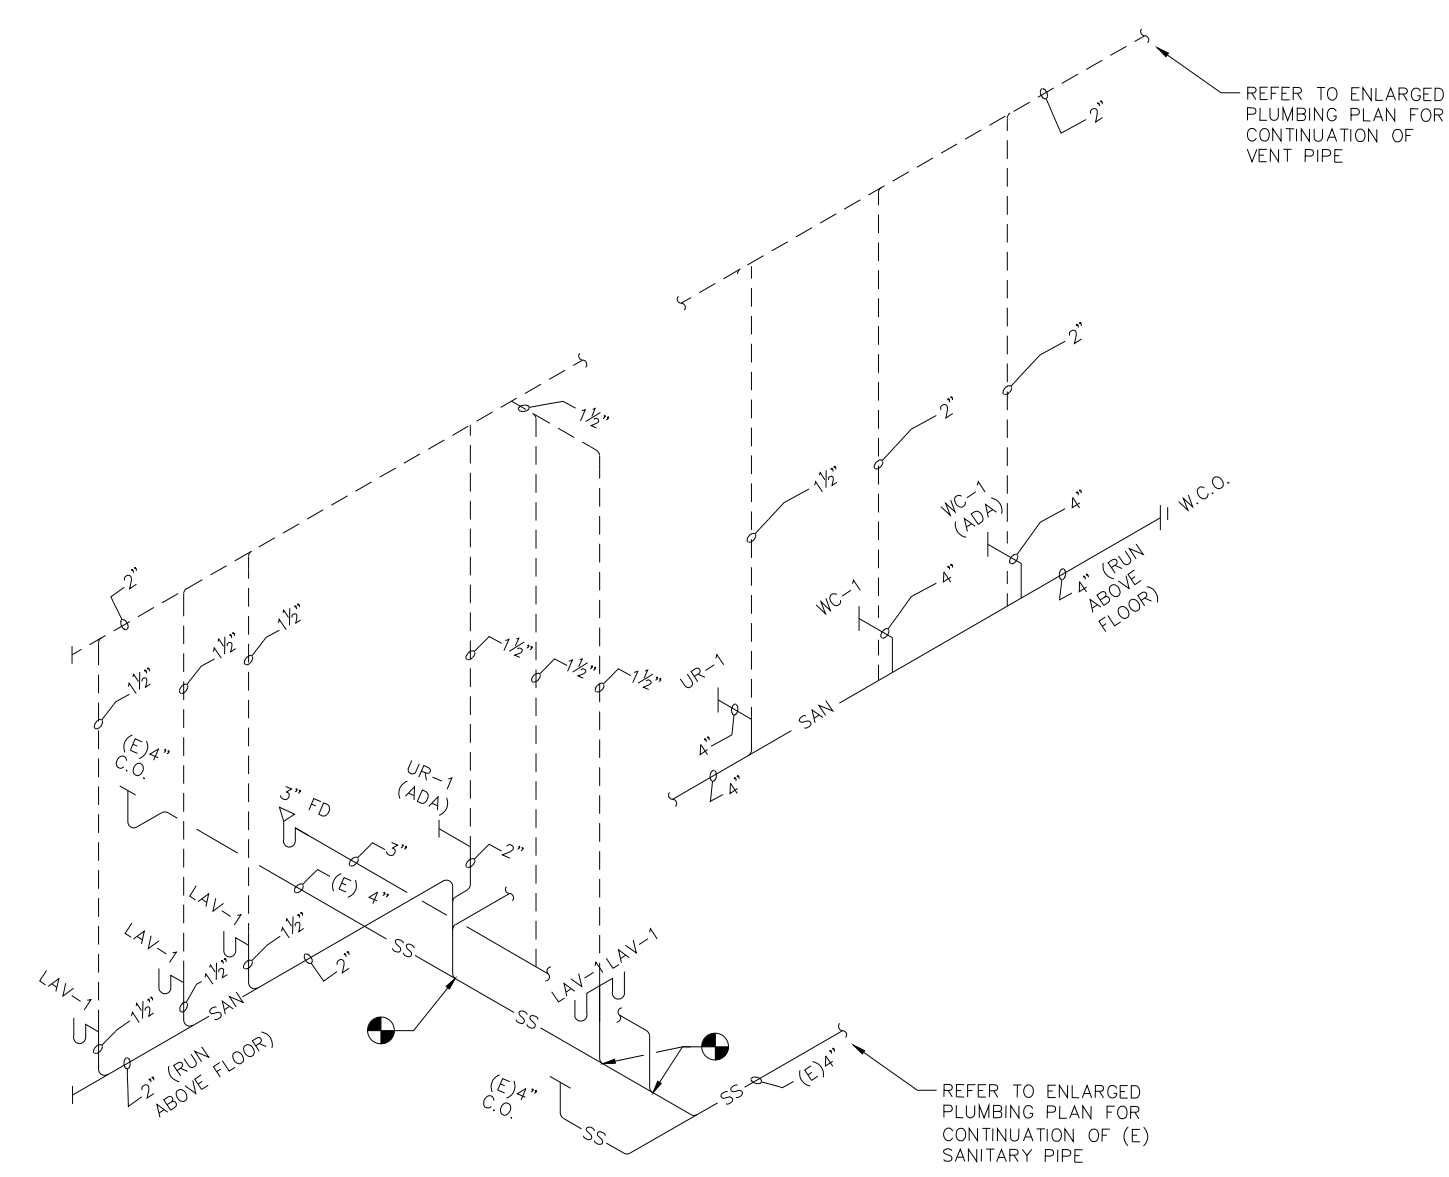


3 SANITARY RISER DIAGRAM (ROOMS A234, A235 & A238)
N.T.S.

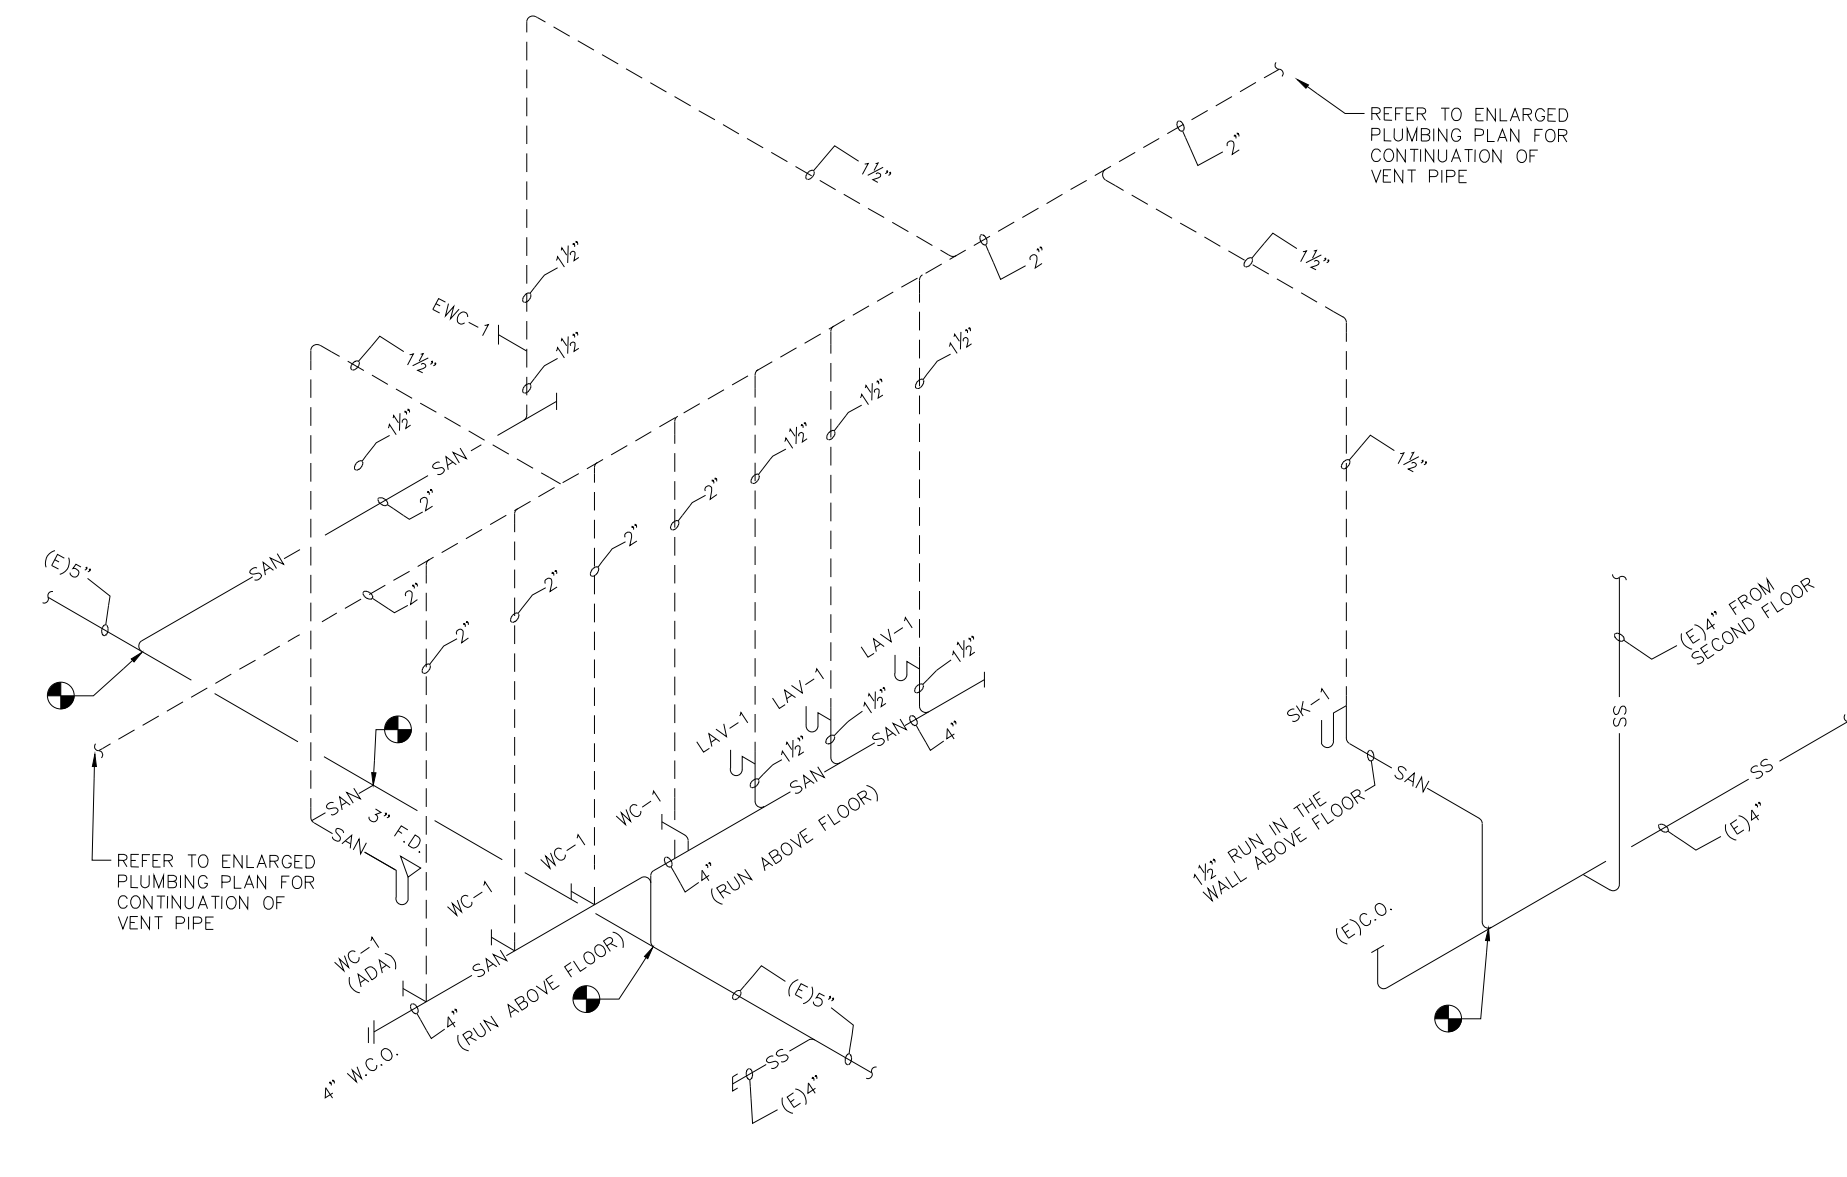


4 SANITARY RISER DIAGRAM (ROOMS A103, A121 & A124)
N.T.S.

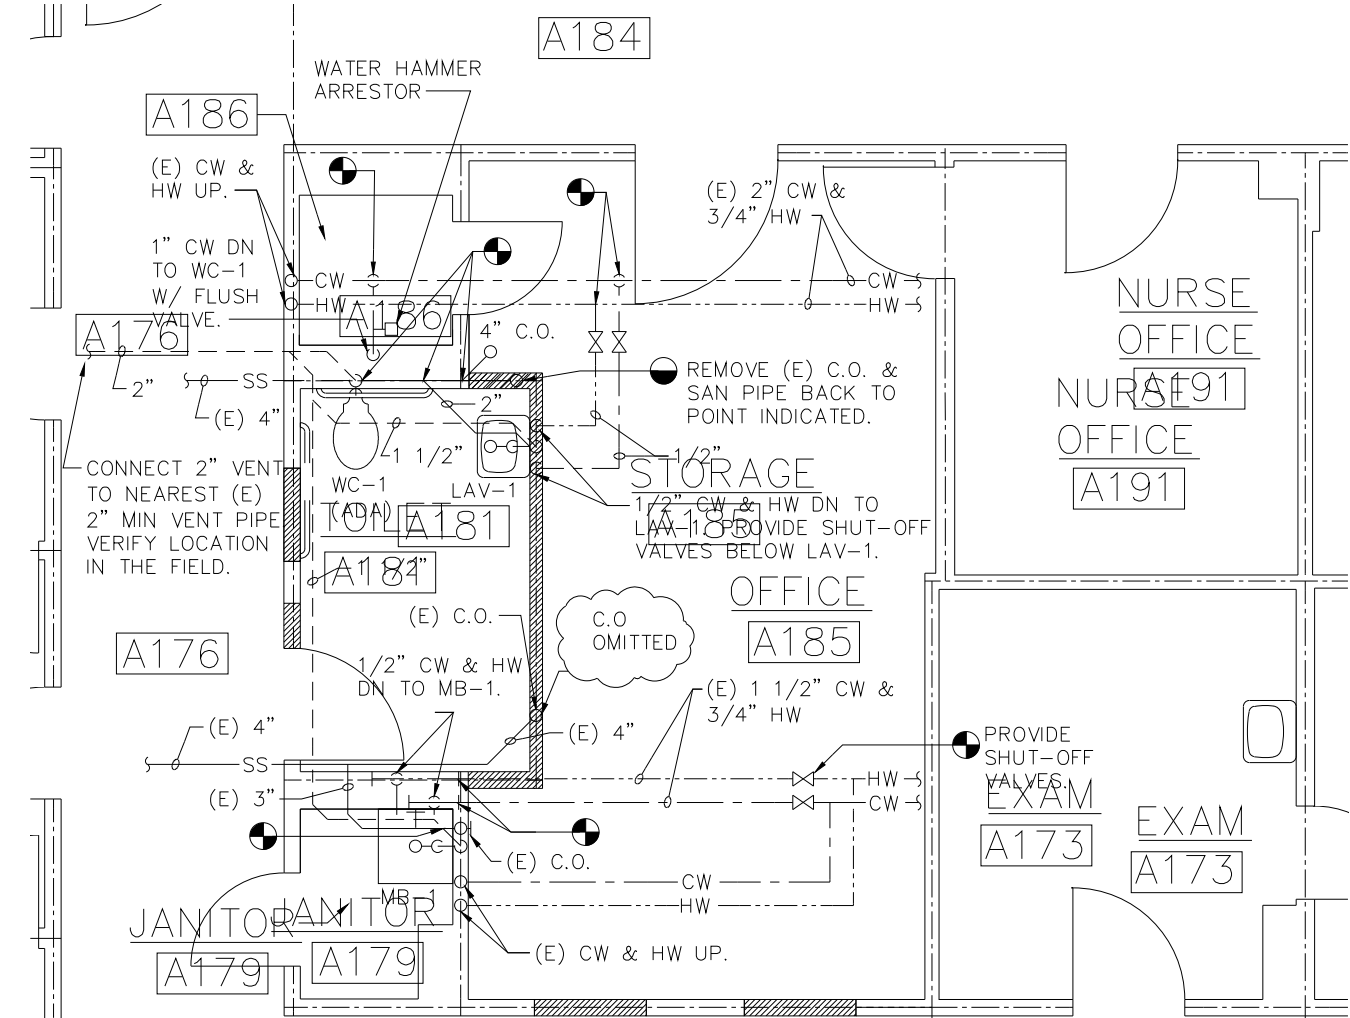


2 ENLARGED PLUMBING PLAN (ROOMS A179 & A181)
SCALE: 1/4" = 1'-0"

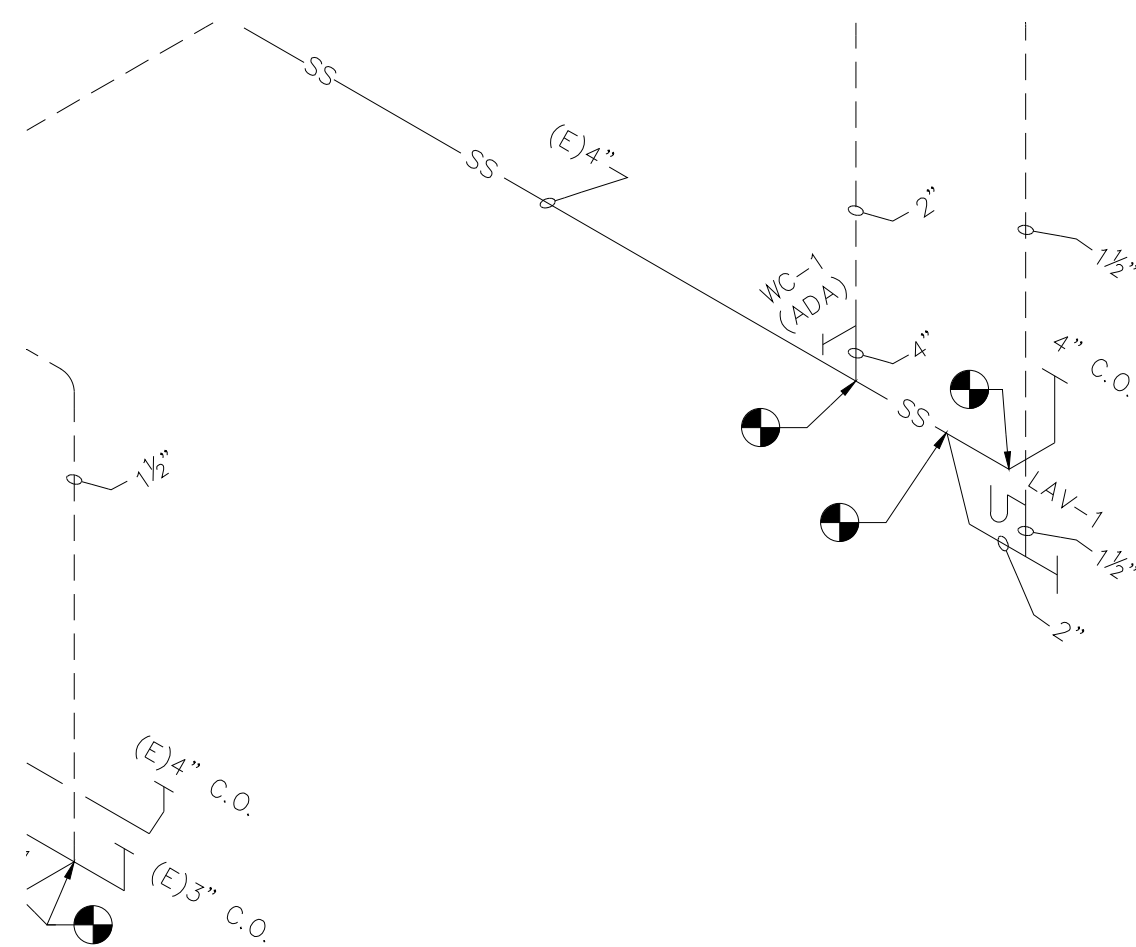

5 SANITARY RISER DIAGRAM (ROOMS A179 & A181)
N.T.S.

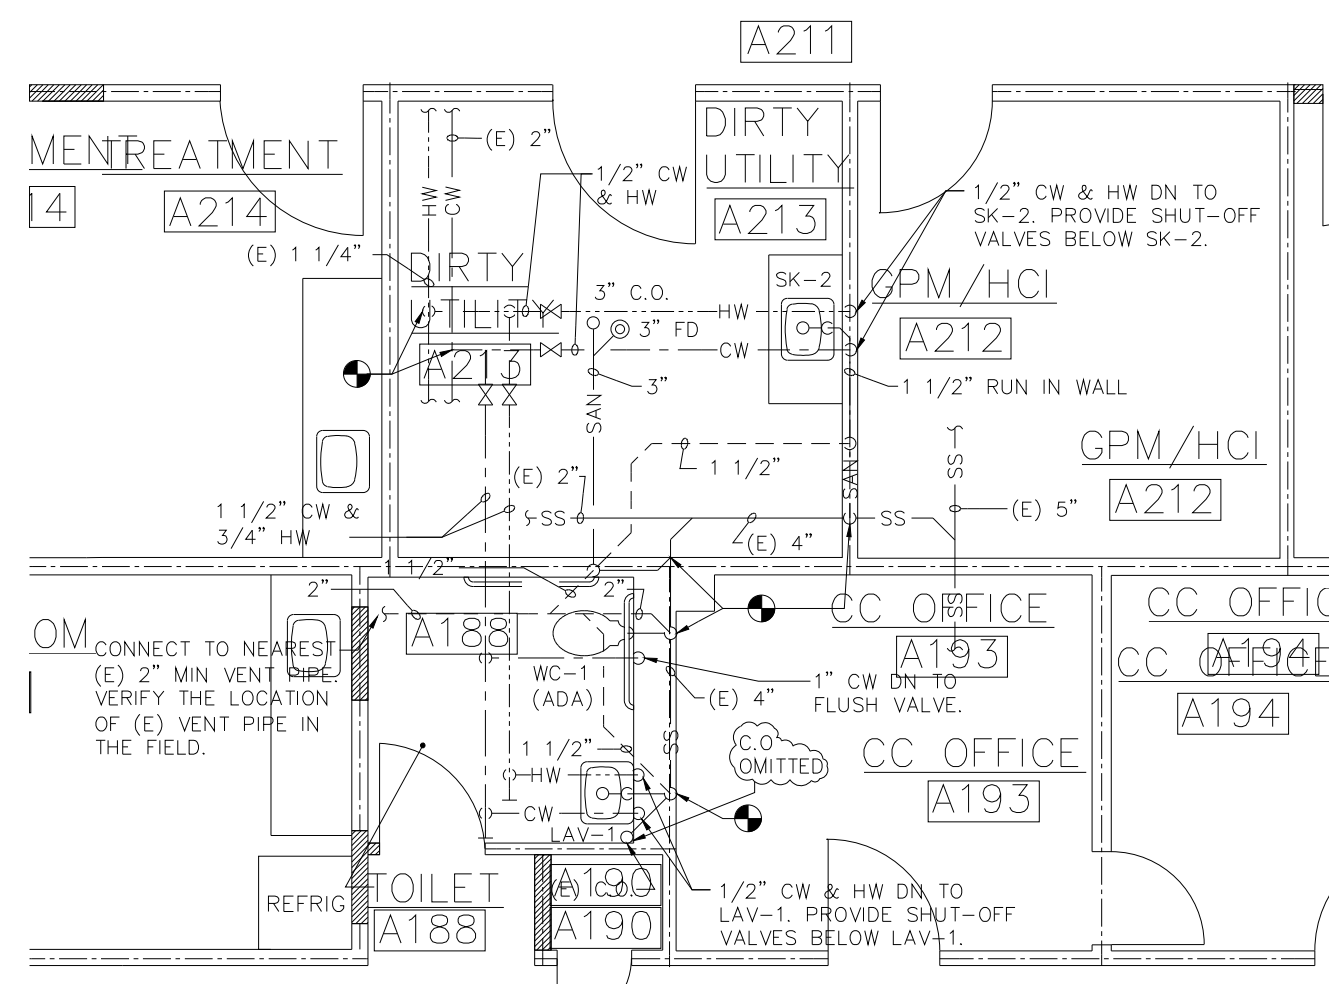


6 ENLARGED PLUMBING PLAN (TOILET A188, & DIRTY UTILITY A213)
SCALE: 1/4" = 1'-0"

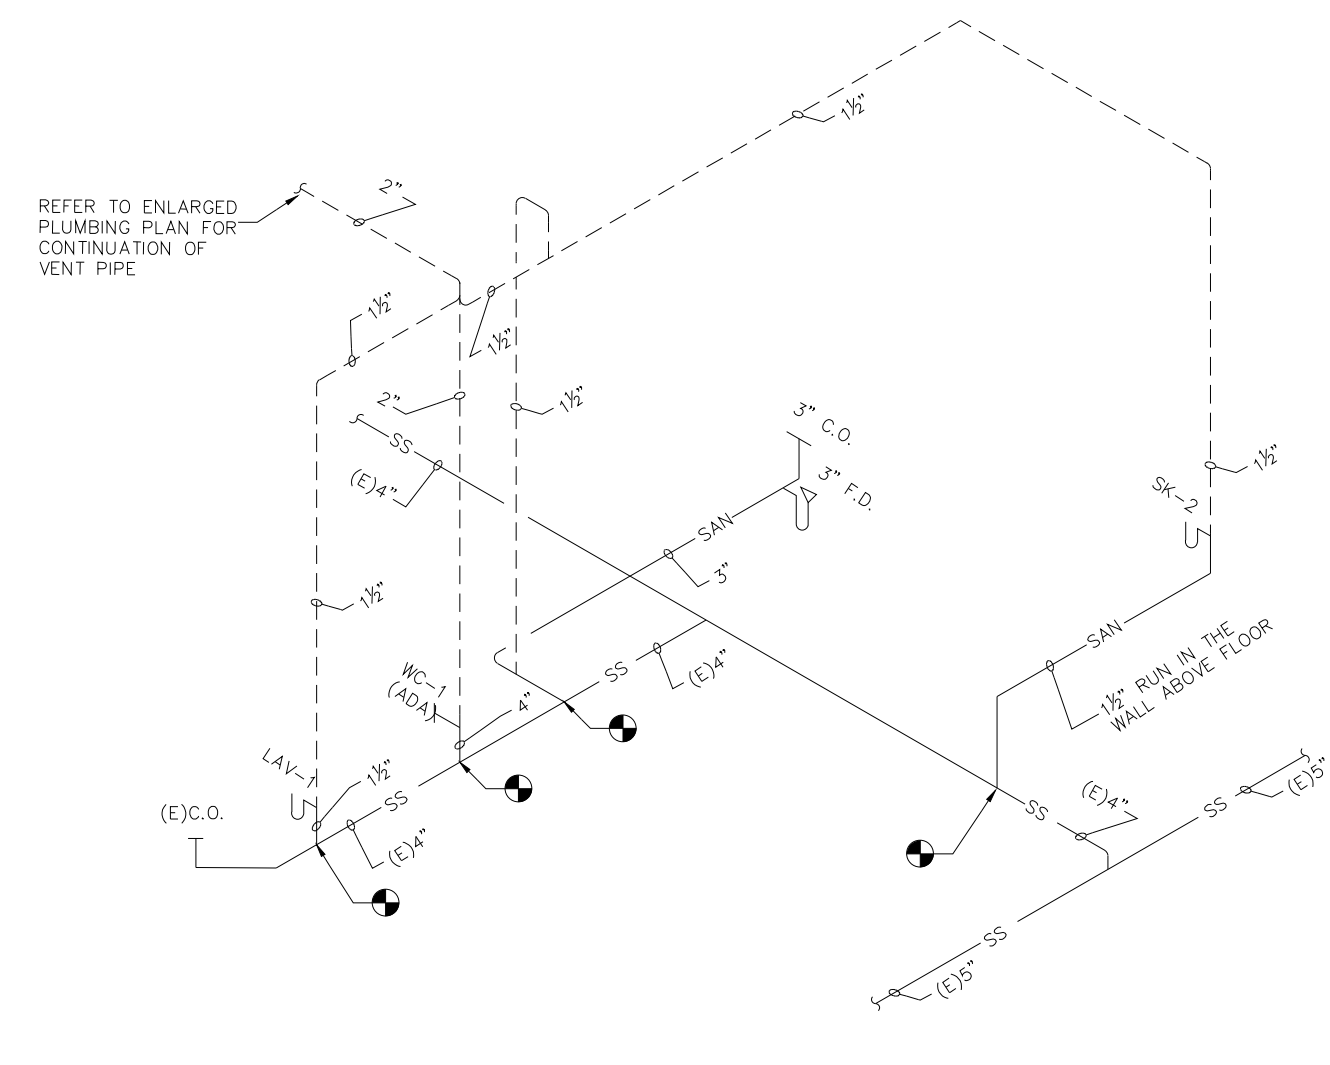

7 SANITARY RISER DIAGRAM (TOILET A188, & DIRTY UTILITY A213)
N.T.S.

KEYPLAN
N.T.S.

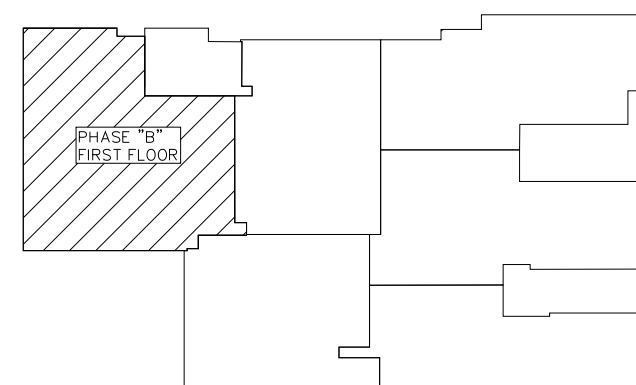

LITTLE ROCK A.F.B.
ARKANSAS

FPM

804 West Curtis Drive, Suite H
Midwest City, OK 73110
phone: 405.869.9212
fax: 405.869.9222
www.fpm-group.com

RECORD
DRAWINGS
MARCH 2007

No.	Revision/Issue	Date	BY	APP'D

PROJECT TITLE REPAIR MEDICAL CENTER PH B LITTLE ROCK AFB, ARKANSAS	SHEET TITLE ENLARGED PLUMBING PLANS AS-BUILT
DRAWN BY MJG	LEAD DESIGNER AM
TECH REVIEWER AM	PROJECT NUMBER NKAK 05-8004A
DESIGNED BY OD	SHEET P1.12
DATE 1-21-08	SCALE AS NOTED
28 OF 39	