

GENERAL DEMOLITION NOTES:


1. IF DIRECTED BY THE OWNER, LOW FLOW PLUMBING FIXTURES SHALL BE SALVAGED AND TURNED OVER TO THE OWNER (COORDINATE WITH OWNER PRIOR TO DEMOLITION).
2. ALL BRANCH PIPING ABANDONED BY THE REMOVAL OF FIXTURES SHALL BE REMOVED BACK TO THE NEAREST MAIN. DO NOT ABANDON IN PLACE.
3. CAP ALL VENTS THRU ROOF THAT ARE MADE OBSOLETE BY REMOVAL OF PLUMBING FIXTURES.
4. ALL PIPES THRU THE FLOOR SLAB THAT ARE REMOVED SHALL BE SEALED AND FIRE STOPPED.

KEYED NOTES:

- 1 REMOVE EXISTING FLOOR SINK AND ASSOCIATED PIPING. REPAIR FLOOR SLAB.
- 2 REMOVE EXISTING LAVATORY AND ALL PIPING ASSOCIATED WITH LAVATORY AND TOILET. REPAIR FLOOR SLAB.
- 3 REMOVE EXISTING WATER FOUNTAIN AND ASSOCIATED PIPING. REPAIR FLOOR SLAB.
- 4 REMOVE EXISTING SINK AND ASSOCIATED PIPING. REPAIR FLOOR SLAB.
- 5 REMOVE EXISTING LAVATORY, TOILET AND ASSOCIATED PIPING. REPAIR FLOOR SLAB.
- 6 REMOVE ABANDONED OXYGEN AND VACUUM PIPING.
- 7 REMOVE EXISTING ROOF DRAIN RISER TO ALLOW FOR RELOCATION TO NEW WALL LOCATION.

LEGEND

- EXISTING PIPING TO REMAIN
- EXISTING PIPING TO BE REMOVED

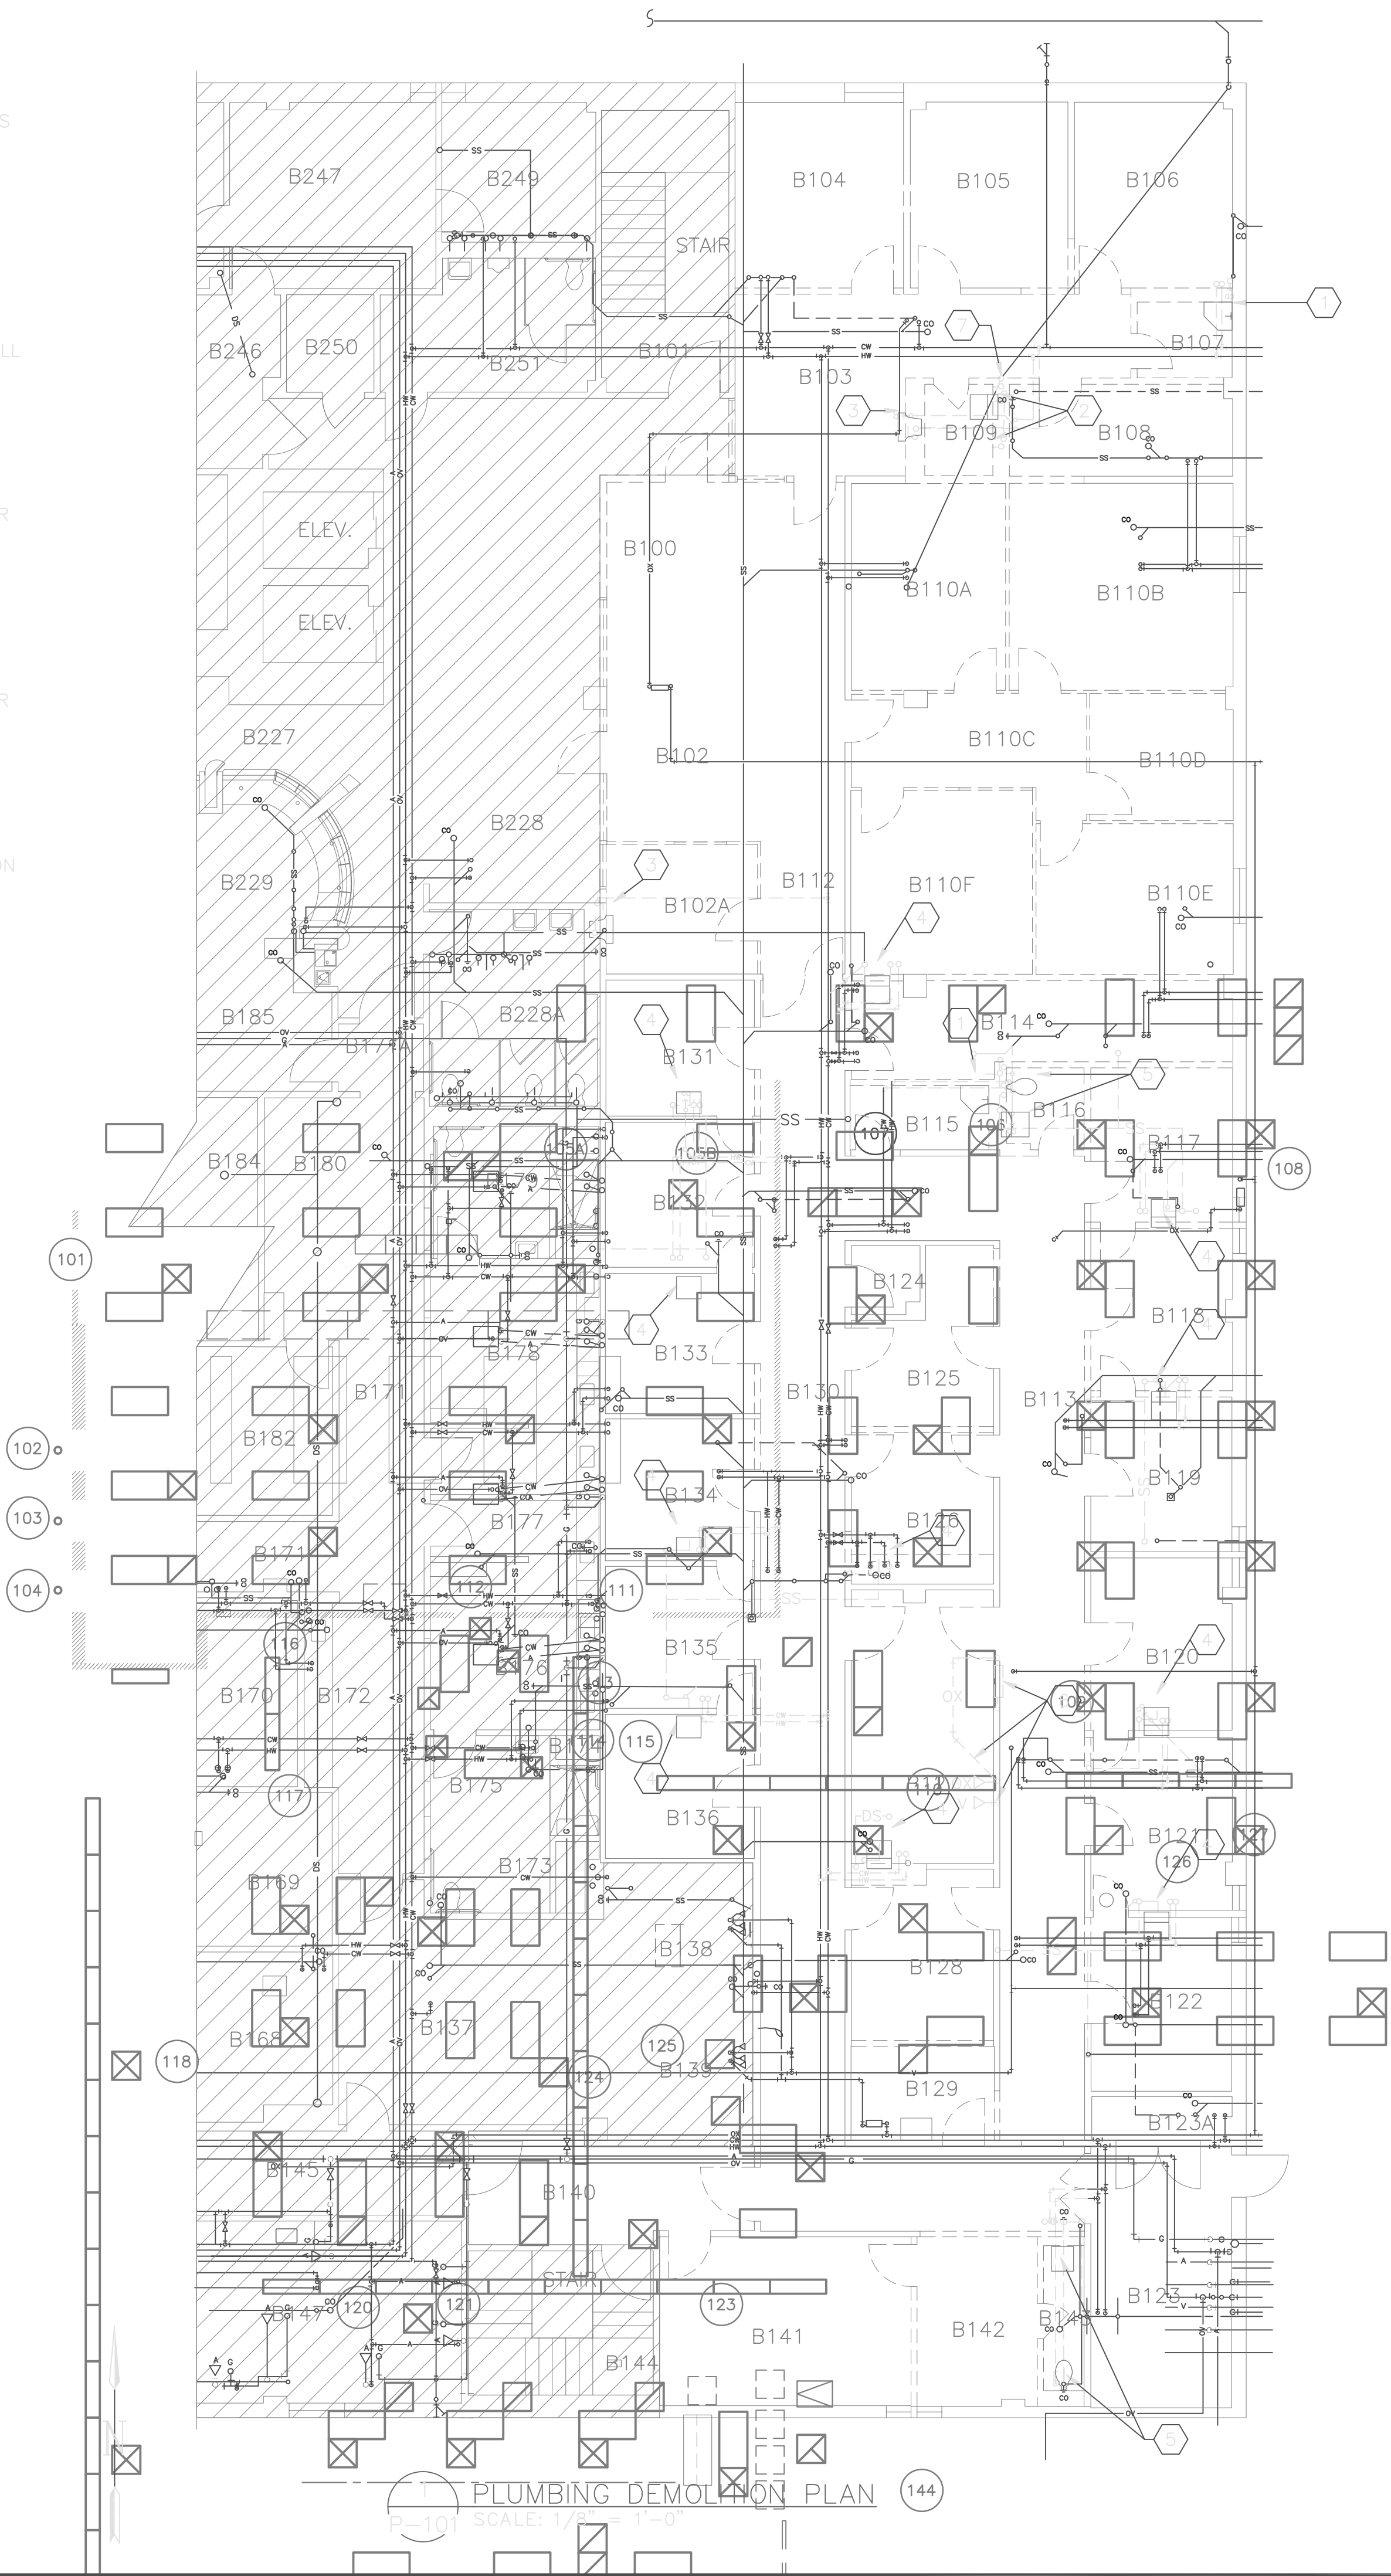

LITTLE ROCK A.F.B.
ARKANSAS

GARVER ENGINEERS

1010 BATTERY STREET
LITTLE ROCK, ARKANSAS 72202
www.garverengineers.com
(501) 376-3633

CROMWELL
ARCHITECTS ENGINEERS
101 SOUTH SPRING ST
LITTLE ROCK AR 72201
TELEPHONE 501-372-2900
FACSIMILE 501-372-0482

No.	Revision/Issue	Date	BY	APP'D

PROJECT TITLE REPAIR & RENOVATE MEDICAL CLINIC PH V LITTLE ROCK AIR FORCE BASE JACKSONVILLE, ARKANSAS 100% SUBMITTAL		SHEET TITLE PLUMBING DEMOLITION PLAN	
DRAWN BY CAG	LEAD DESIGNER JCF	PROJECT NUMBER NKAK#06-8006-5	P-101
TECH REVIEWER JCF	DESIGNED BY CAG	SHEET	
DATE 7 MAY 2008	SCALE AS SHOWN	25 OF 27	