




1 ENLARGED PLUMBING PLAN (TOILETS C168 & C169)
SCALE: 1/4" = 1'-0"

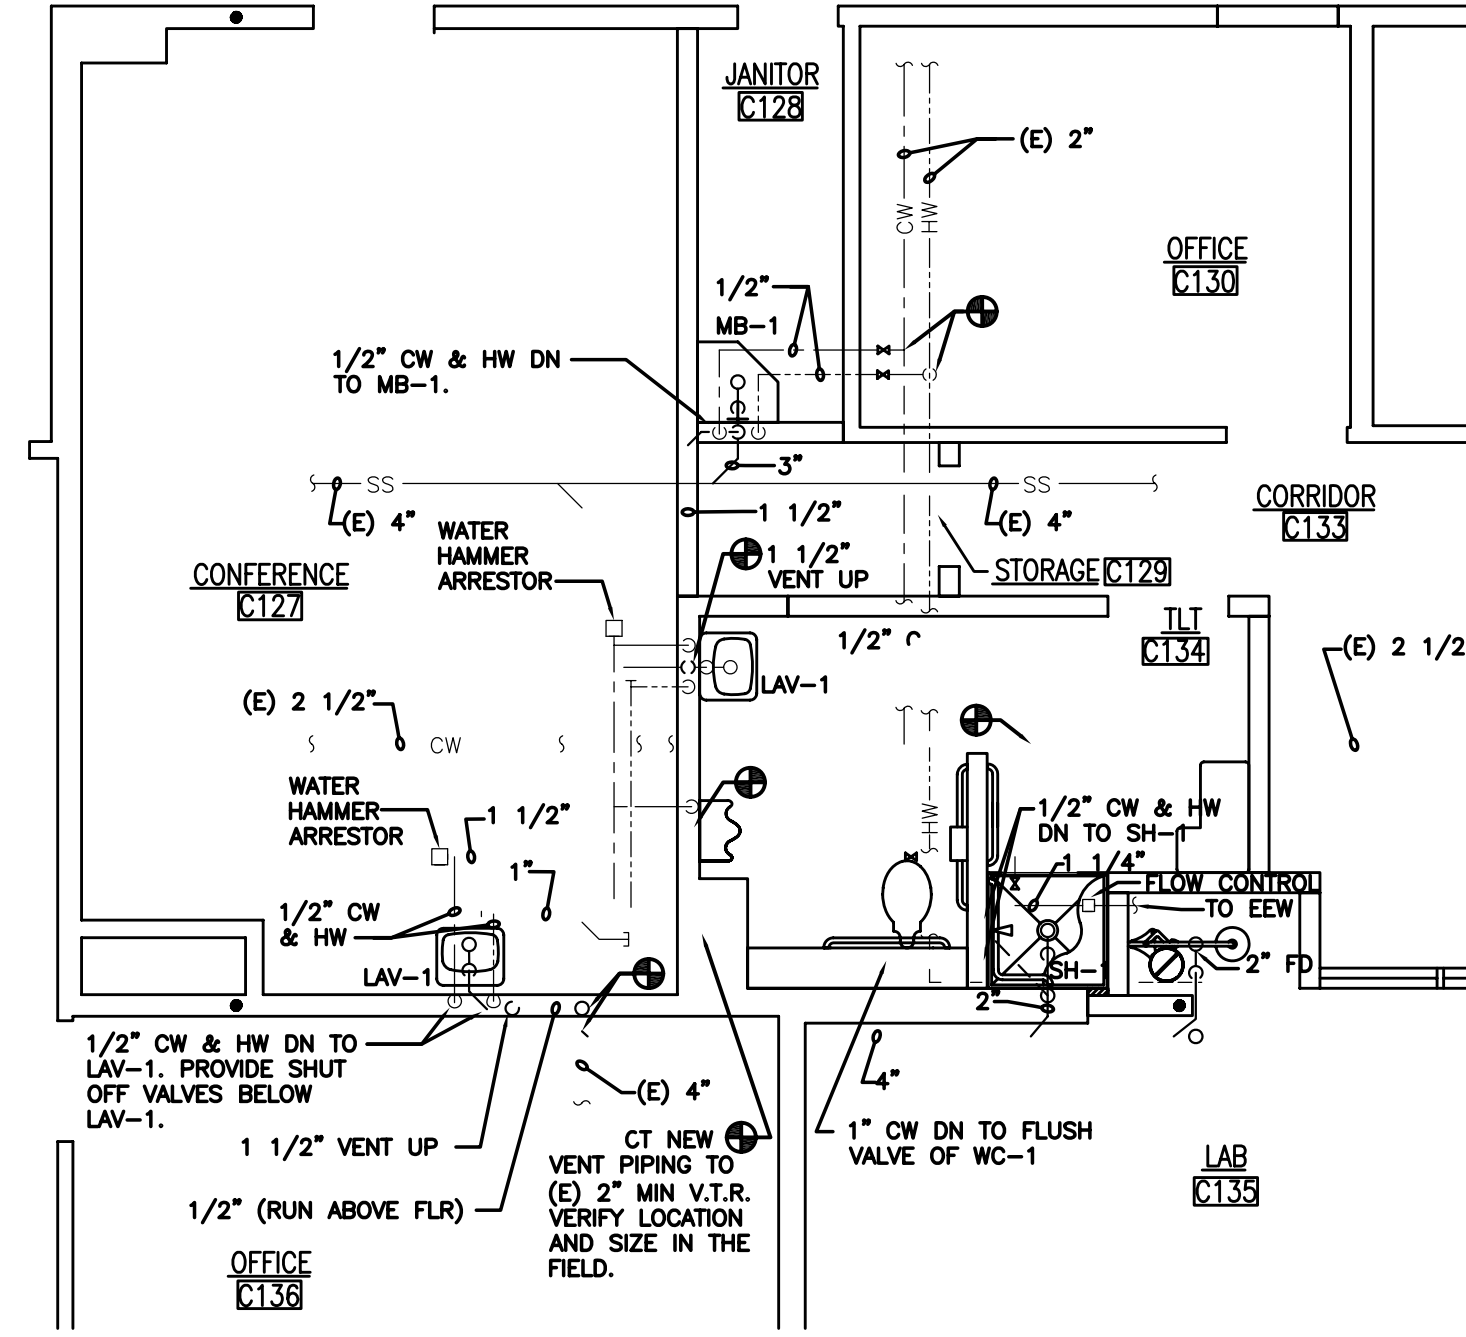


3 ENLARGED PLUMBING PLAN (TOILET C134, JANITOR CLOSET C128 AND CONFERENCE RM. C127)
SCALE: 1/4" = 1'-0"

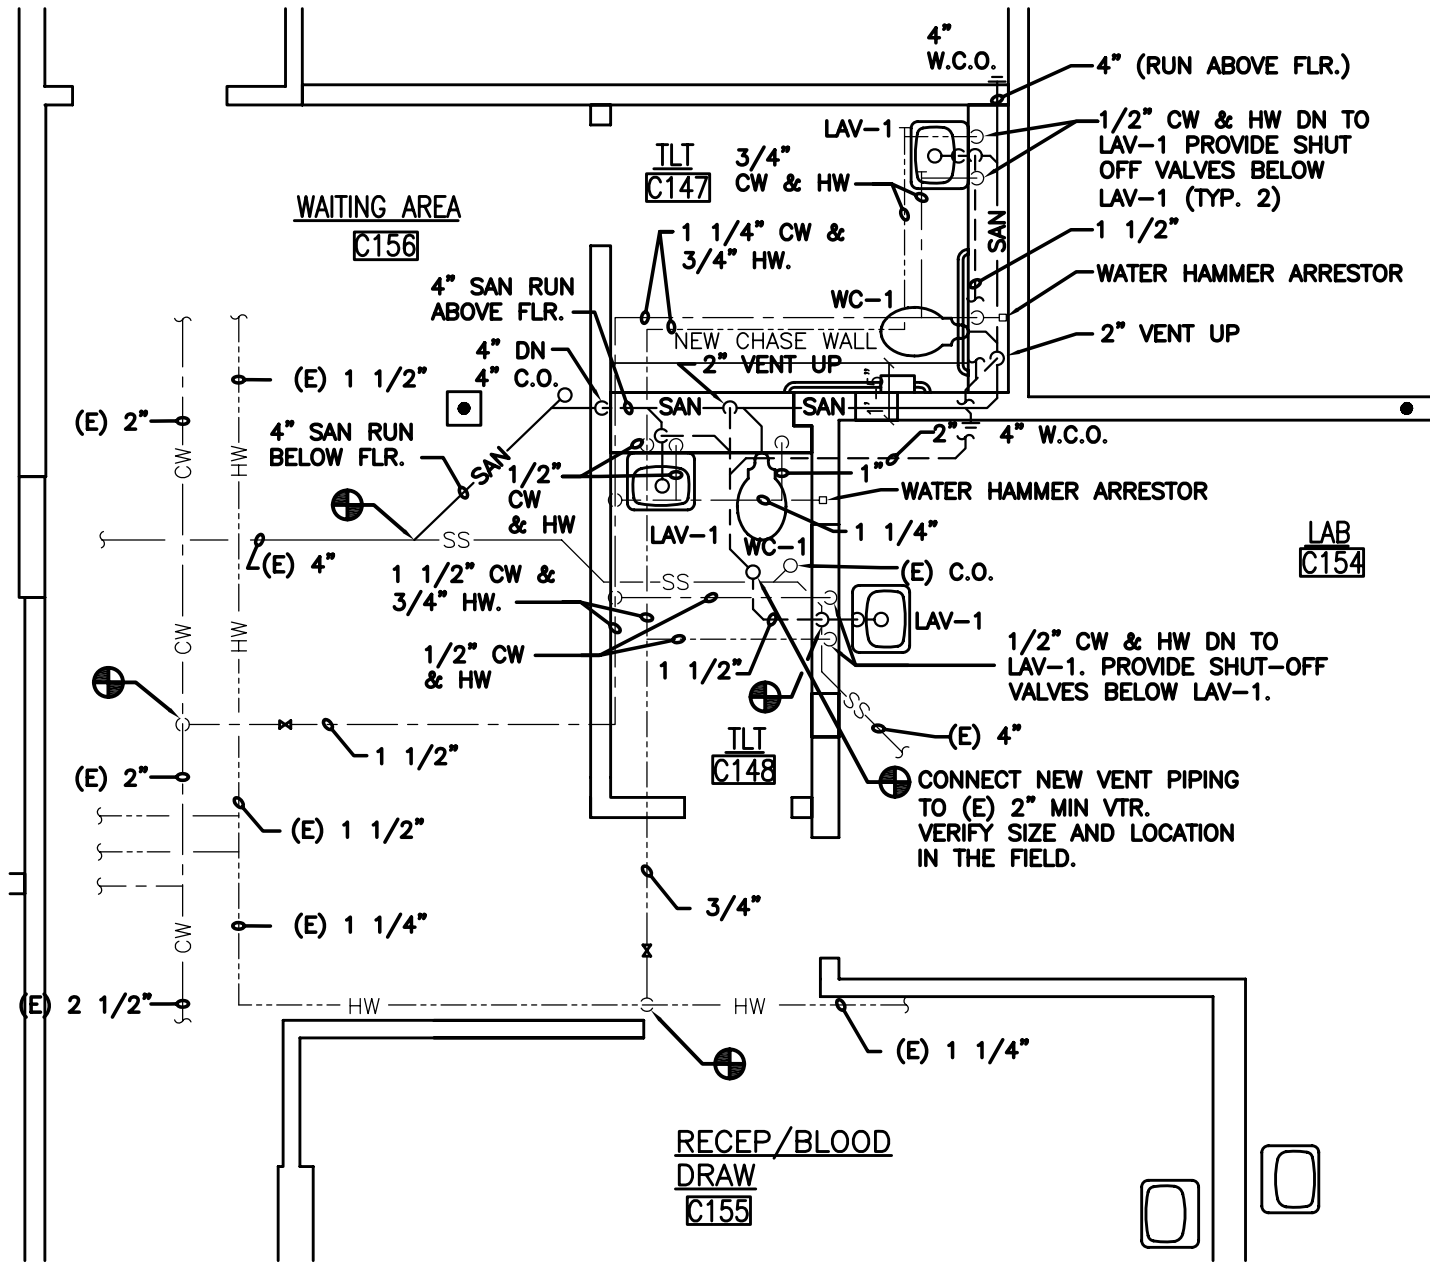


5 ENLARGED PLUMBING PLAN (TOILETS C147 & C148 & LAB C154)
SCALE: 1/4" = 1'-0"

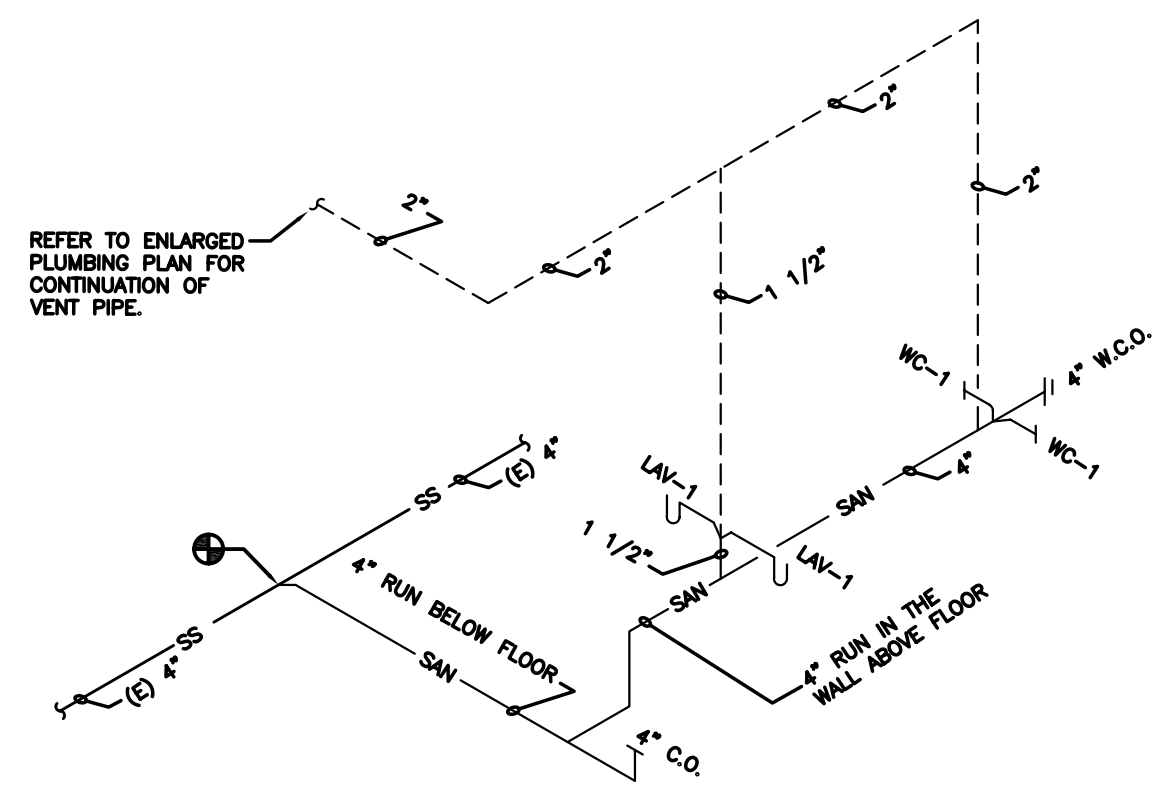



2 SANITARY RISER DIAGRAM (TOILETS C168 & C169)
SCALE: N.T.S.

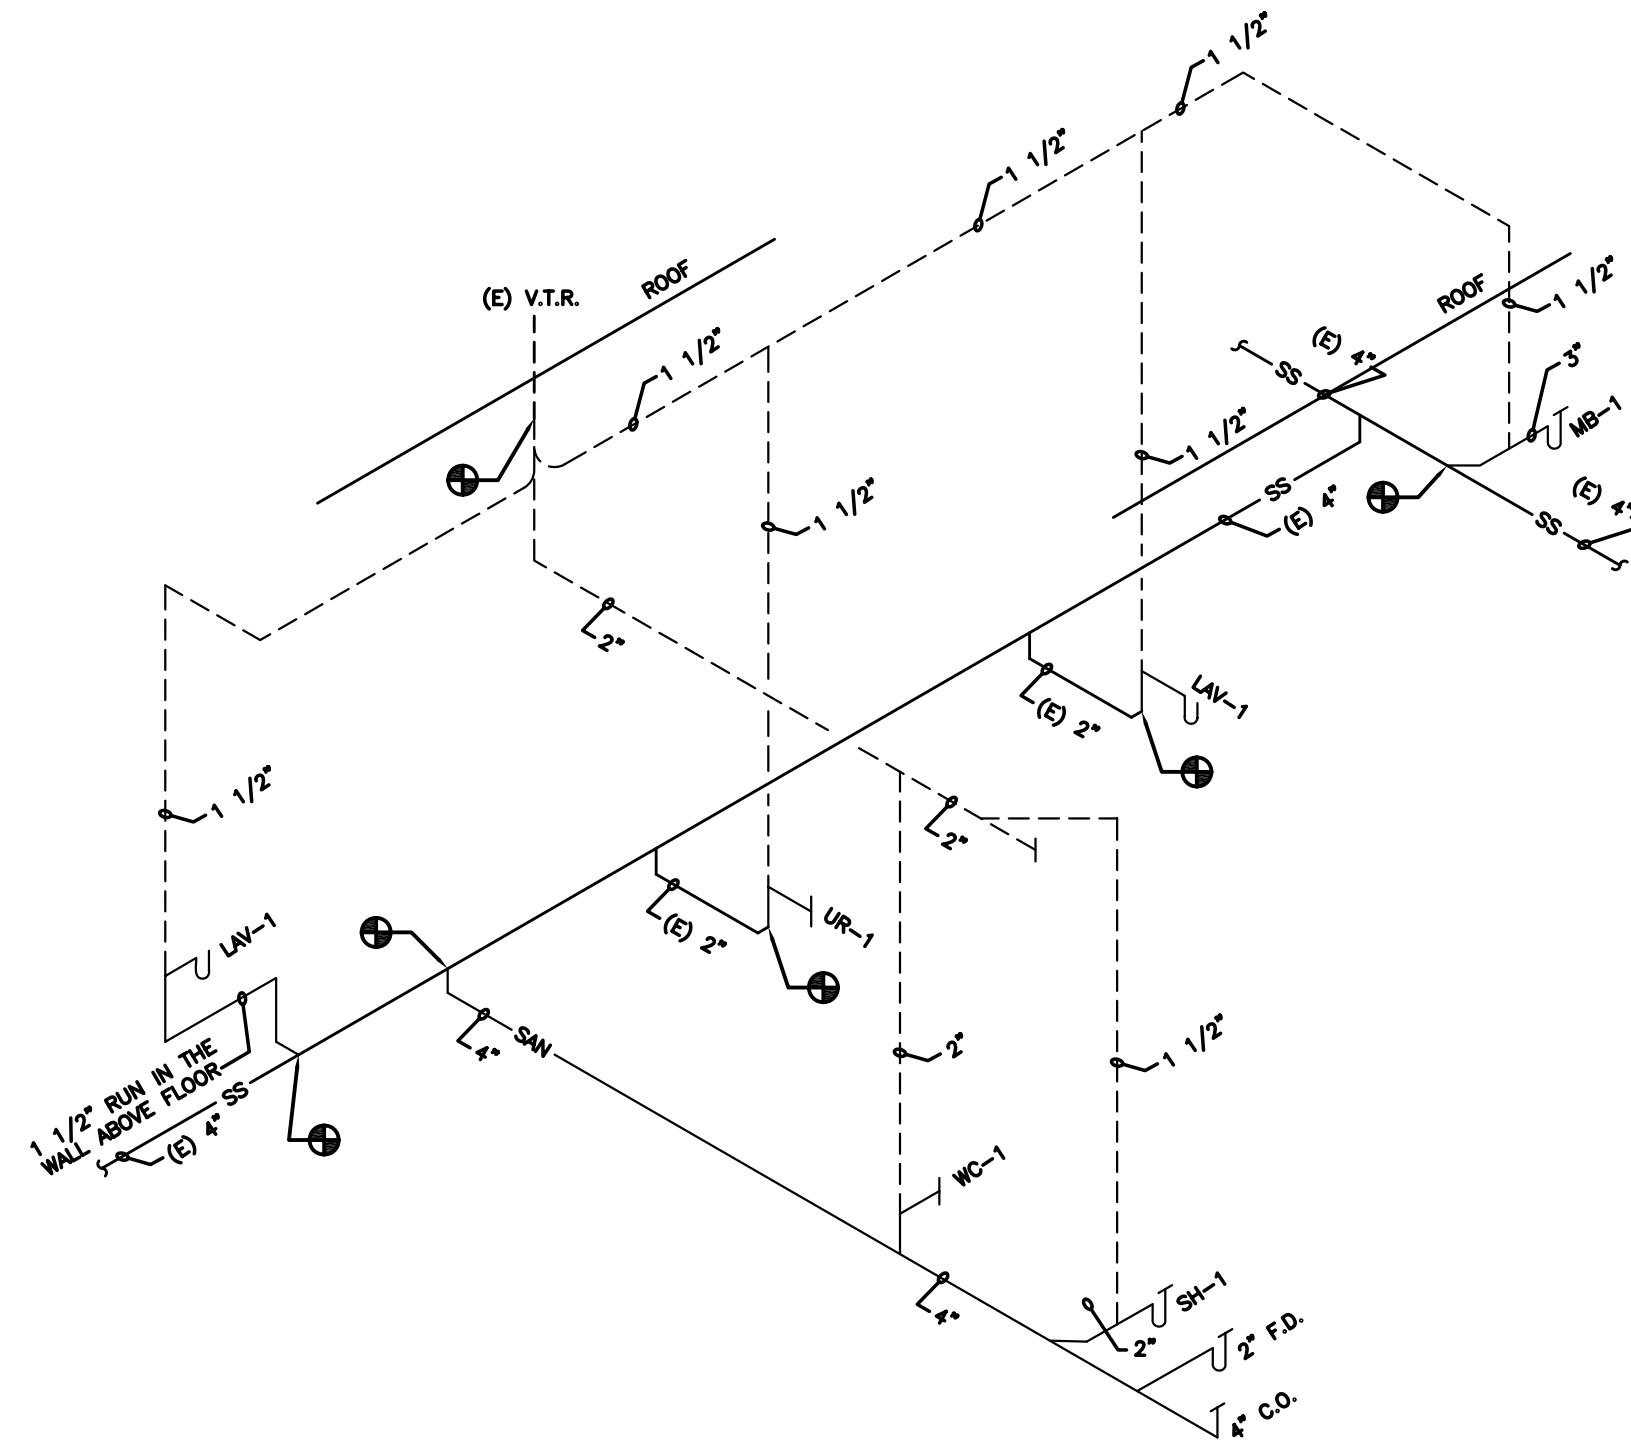

4 SANITARY RISER DIAGRAM (TOILET C134, JANITOR CLOSET C128 AND CONFERENCE RM. C127)
SCALE: N.T.S.

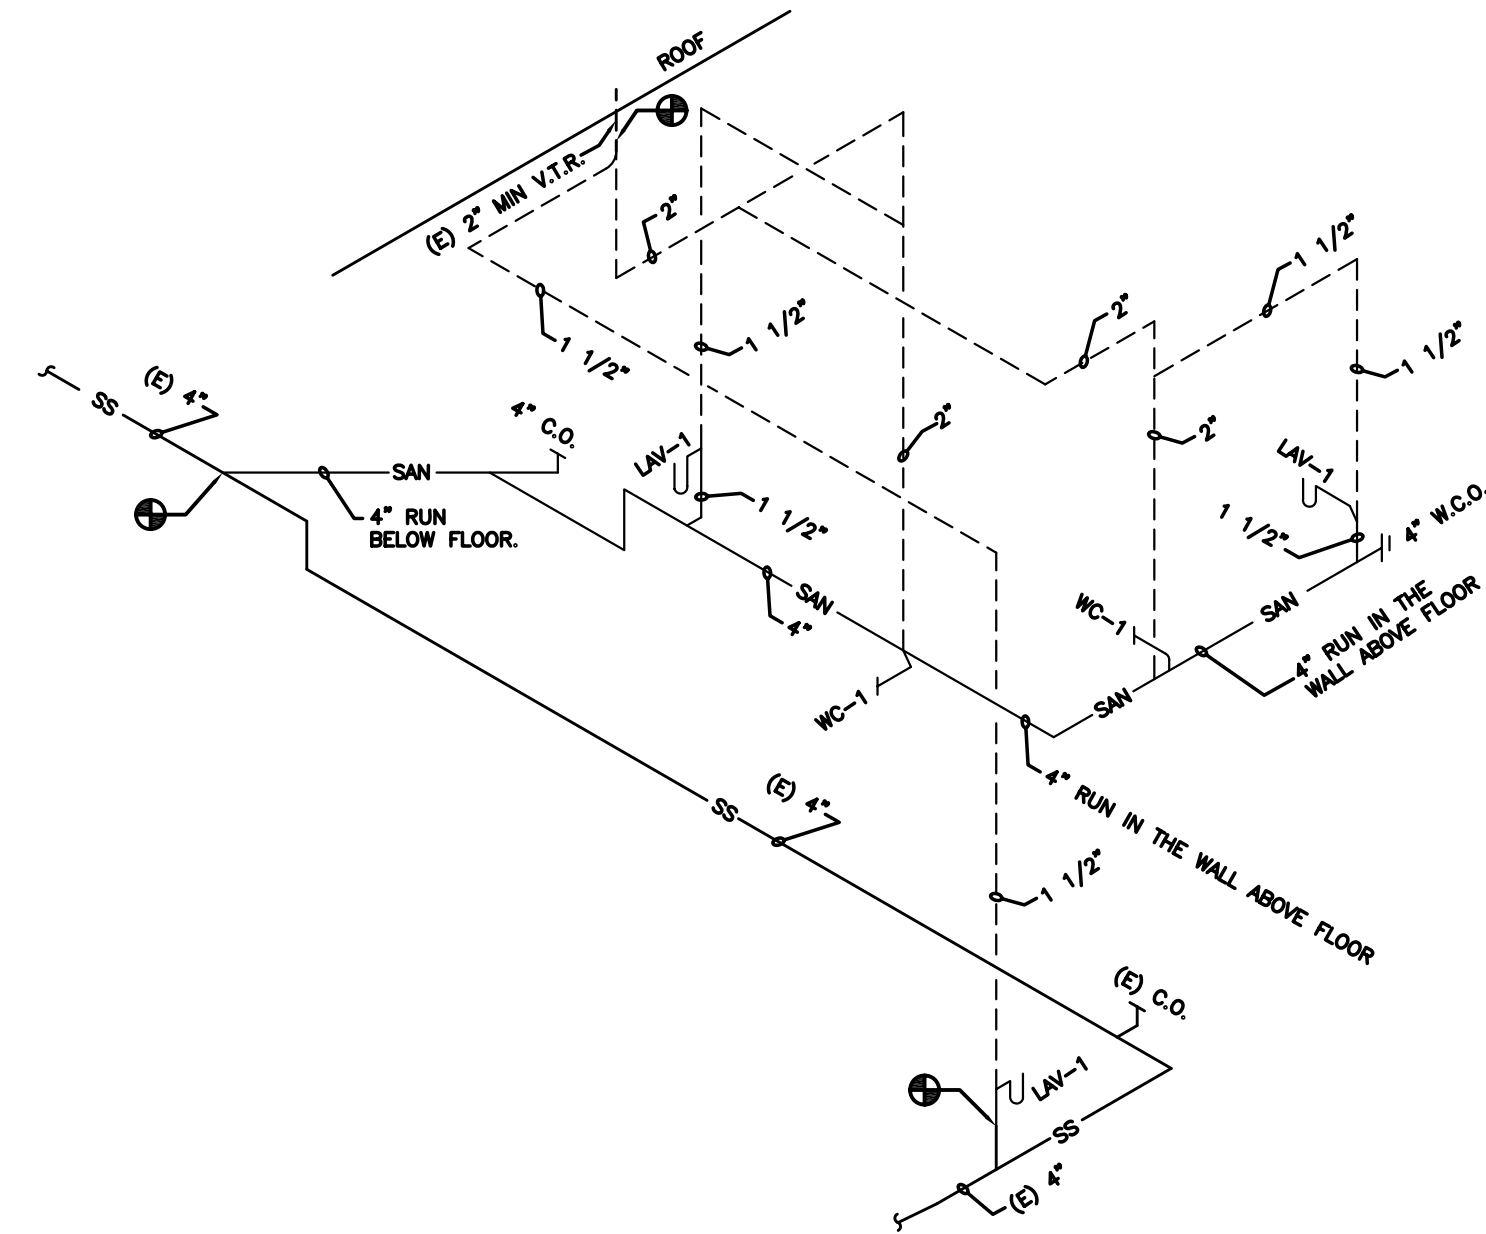

6 SANITARY RISER DIAGRAM (TOILETS C147 & C148 & LAB C154)
SCALE: N.T.S.

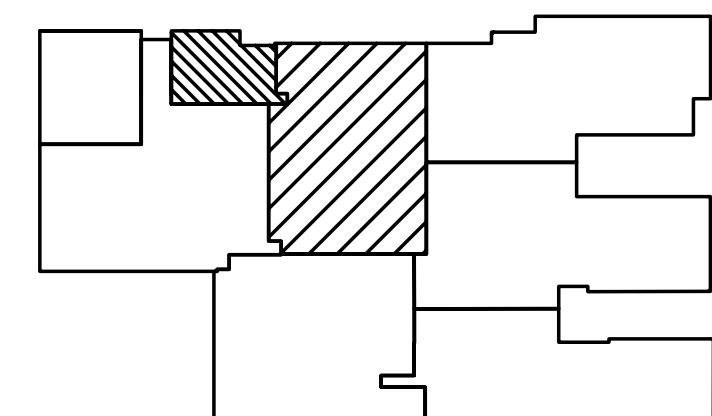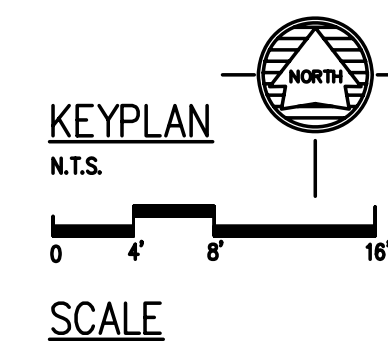

LITTLE ROCK A.F.B.
ARKANSAS

PROJECT TITLE	BY	Date	Revision/Issue	No.
REPAIR MEDICAL CENTER PH 3 LITTLE ROCK AFB, ARKANSAS				

PROJECT TITLE	LEAD DESIGNER	PROJECT NUMBER	SHEET
REPAIR MEDICAL CENTER PH 3 LITTLE ROCK AFB, ARKANSAS	AM	NKAK 06-8001	P1.13
ENLARGED PLUMBING FLOOR PLANS AND RISER DIAGRAMS			27 of 37