
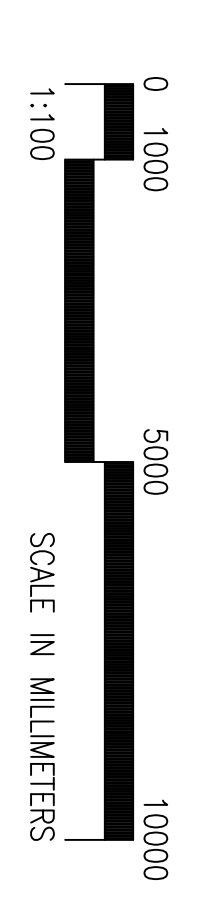


- KEYNOTES:**
- ① CONNECT (1) SWITCH LEG TO CONTROL THE CENTER LAMP AND (1) TO CONTROL OUTBOARD LAMPS.
  - ② CONNECT (1) SWITCH LEG TO CONTROL THE (2) INBOARD LAMPS AND (1) TO CONTROL THE OUTBOARD LAMPS.
  - ③ DESIGNATED FIXTURES SHALL BE EQUIPPED WITH QUARTZ RESTRIKE CAPABILITY.
  - ④ TYPE H1 FIXTURES ARE FURNISHED WITH EMERGENCY BATTERY PACKS. THESE FIXTURES SHALL BE CAPABLE OF BEING SWITCH OPERATED TO ALLOW FOR NIGHT VISION TRAINING. IN SWITCHED MODE, FIXTURES SHALL REMAIN CAPABLE OF EMERGENCY OPERATION.
  - ⑤ SEE SHEET E-504 FOR LC-1 AND LC-2 CONNECTIONS.
  - ⑥ EXISTING FIXTURES TO REMAIN IN PLACE AND STAY OPERATIONAL THROUGHOUT CONSTRUCTION.
- GENERAL NOTES:**
- 1. BRANCH CIRCUITS FROM PANELBOARDS TO DEVICES OVER 30 METERS DISTANCE SHALL BE #10AWG MINIMUM, UNLESS NOTED OTHERWISE.

1 LIGHTING PLAN  
 E102 E102 SCALE: 1:100

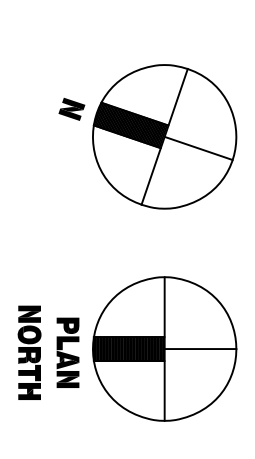

NOTE:  
 ALL DIMENSIONS AND/OR DIMENSIONS SHOWN IN CALLOUTS/NOTES ARE IN MILLIMETERS (mm) UNLESS OTHERWISE NOTED.

<p>ADAL C-130J AIRCREW FUSELAGE TRAINER          LRAFB, LITTLE ROCK AR.          Project No. NKAK 043005</p> <p style="text-align: center;">LIGHTING PLAN</p>	<p>DEPARTMENT OF THE ARMY          U.S. ARMY CORPS OF ENGINEERS          LITTLE ROCK DISTRICT          LITTLE ROCK, ARKANSAS</p> <p style="text-align: center;"><b>Atkins Benham</b>  <small>a member of the WS Atkins group of companies</small></p>	<table border="1" style="width: 100%; border-collapse: collapse;"> <tr> <td>Designed by: RH</td> <td>Drawn by: MB</td> <td>Contract Date:</td> </tr> <tr> <td>Reviewed by: PWD</td> <td>Drwg. Code:</td> <td>File Name: 151001E-102</td> </tr> <tr> <td colspan="2">Submitted by:</td> <td>Plot date: 02/04/03</td> </tr> <tr> <td colspan="2">Atkins Benham, Inc.</td> <td>Plot scale: 1:1</td> </tr> <tr> <td>Invitation No.: DAC403-03-R-0021</td> <td>Contract No.:</td> <td>DAC403-03-B-</td> </tr> </table>	Designed by: RH	Drawn by: MB	Contract Date:	Reviewed by: PWD	Drwg. Code:	File Name: 151001E-102	Submitted by:		Plot date: 02/04/03	Atkins Benham, Inc.		Plot scale: 1:1	Invitation No.: DAC403-03-R-0021	Contract No.:	DAC403-03-B-	<table border="1" style="width: 100%; border-collapse: collapse;"> <thead> <tr> <th>Mark</th> <th>Description</th> <th>Date</th> <th>Appr.</th> <th>Mark</th> <th>Description</th> <th>Date</th> <th>Appr.</th> </tr> </thead> <tbody> <tr><td> </td><td> </td><td> </td><td> </td><td> </td><td> </td><td> </td><td> </td></tr> <tr><td> </td><td> </td><td> </td><td> </td><td> </td><td> </td><td> </td><td> </td></tr> <tr><td> </td><td> </td><td> </td><td> </td><td> </td><td> </td><td> </td><td> </td></tr> <tr><td> </td><td> </td><td> </td><td> </td><td> </td><td> </td><td> </td><td> </td></tr> <tr><td> </td><td> </td><td> </td><td> </td><td> </td><td> </td><td> </td><td> </td></tr> <tr><td> </td><td> </td><td> </td><td> </td><td> </td><td> </td><td> </td><td> </td></tr> <tr><td> </td><td> </td><td> </td><td> </td><td> </td><td> </td><td> </td><td> </td></tr> <tr><td> </td><td> </td><td> </td><td> </td><td> </td><td> </td><td> </td><td> </td></tr> <tr><td> </td><td> </td><td> </td><td> </td><td> </td><td> </td><td> </td><td> </td></tr> <tr><td> </td><td> </td><td> </td><td> </td><td> </td><td> </td><td> </td><td> </td></tr> </tbody> </table>	Mark	Description	Date	Appr.	Mark	Description	Date	Appr.																																																																																
Designed by: RH	Drawn by: MB	Contract Date:																																																																																																								
Reviewed by: PWD	Drwg. Code:	File Name: 151001E-102																																																																																																								
Submitted by:		Plot date: 02/04/03																																																																																																								
Atkins Benham, Inc.		Plot scale: 1:1																																																																																																								
Invitation No.: DAC403-03-R-0021	Contract No.:	DAC403-03-B-																																																																																																								
Mark	Description	Date	Appr.	Mark	Description	Date	Appr.																																																																																																			

Sheet Reference Number:  
**E-102**  
 Sheet 78 of 91

