
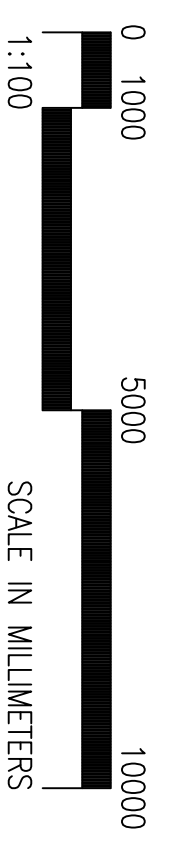


- KEYNOTES:**
- ① FURNISH AND INSTALL 103mm SQUARE J-BOX NEAR TRAINER FOR CONNECTION TO FIRE DETECTION SYSTEM WITHIN TRAINER (BY OTHERS). ROUTE WIRING BACK TO EXISTING FIRE CONTROL PANEL. TAG AND TAPE WIRES FOR CONNECTION AFTER TRAINER INSTALLATION IS COMPLETE.
 - ② REFER TO SHEET E-106 FOR LOCATION OF EXISTING MONACO M-1 PANEL. ALL DEVICES, ANNUNCIATORS, ETC., WILL BE ROUTED TO THIS PANEL.

1 FIRE ALARM PLAN
 E103 E103 SCALE: 1:100

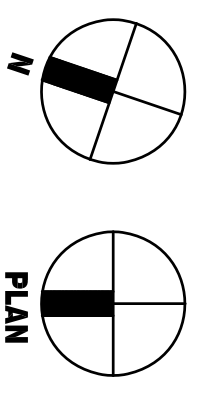

NOTE:
 ALL DIMENSIONS AND/OR DIMENSIONS SHOWN IN CALLOUTS/NOTES ARE IN MILLIMETERS (mm) UNLESS OTHERWISE NOTED.

Sheet Reference Number:
E-103
 Sheet 79 of 91

ADAL C-130J AIRCREW FUSELAGE TRAINER
 LRAFB, LITTLE ROCK AR.
 Project No. NKAK 043005
 FIRE ALARM PLAN

DESIGNED BY: RH DRAWN BY: MB CONTRACT DATE: 151001E-103		REVIEWED BY: PWD DRWG. CODE: FILE NAME: 151001E-103	
SUBMITTED BY: Atkins Benham, Inc. INVITATION NO.: DAC03-03-R-0021		PLOT DATE: 02/04/03 PLOT SCALE: 1:1 CONTRACT NO.: DAC03-03-B-	

Mark	Description	Date	Appr.	Mark	Description	Date	Appr.

