
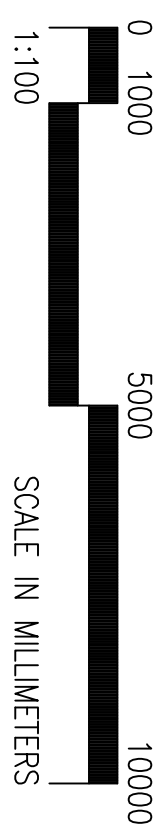


1 FIRE PROTECTION PLAN
 F101 F101 SCALE: 1:100

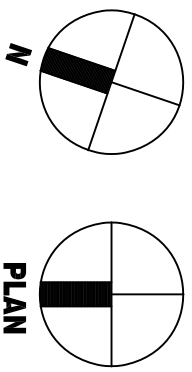

NOTE:
 ALL DIMENSIONS AND/OR DIMENSIONS SHOWN IN CALLOUTS/NOTES
 ARE IN MILLIMETERS (mm) UNLESS OTHERWISE NOTED.

Sheet Reference Number: F-101
 Sheet 73 of 91

ADAL C-130J AIRCREW FUSELAGE TRAINER
 LRAFB, LITTLE ROCK AR.
 Project No. NKAK 043005
 FIRE PROTECTION FLOOR PLAN

DEPARTMENT OF THE ARMY
 U.S. ARMY CORPS OF ENGINEERS
 LITTLE ROCK DISTRICT
 LITTLE ROCK, ARKANSAS

Atkins Benham
 a member of the WS Atkins group of companies

Designed by: GG	Drawn by: MB	Contract Date:
Reviewed by: PWD	Drwg. Code: XX	File Name: 151001F-101
Submitted by:	Plot date: 02/04/03	
Atkins Benham, Inc.	Plot scale: 1:1	
Invitation No.: DKM03-03-R-0021	Contract No.: DKM03-03-B-	

Mark	Description	Date	Appr.	Mark	Description	Date	Appr.

U.S. ARMY CORPS OF ENGINEERS
 LITTLE ROCK DISTRICT