



HAAC NOTE

1. HVAC EQUIPMENT & UTILITY CONNECTIONS TO HAAC EQUIPMENT AND ASSOCIATED EXTERIOR SUPPLY AND RETURN DUCTWORK FROM HAAC EQUIPMENT TO THE BUILDING WEST EXTERIOR WALL, ASSOCIATED WITH THE TWO (2) "TRAINING SIMULATORS" SHALL BE FURNISHED AND INSTALLED UNDER A SEPARATE CONTRACT.

NOTE

1. THIS STRUCTURE IS LOCATED IN A SEISMIC ZONE. CONTRACTOR TO BRACE THE RADIANT HEATING SYSTEM, AIR CONDITIONING SYSTEM, DUCTWORK AND ALL PIPES PER APPLICABLE CODE.

1 MECHANICAL PLAN
 SCALE: 1:100

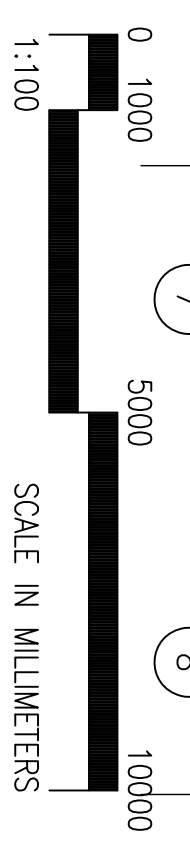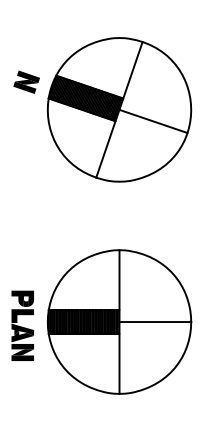

NOTE: ALL DIMENSIONS AND/OR DIMENSIONS SHOWN IN CALLOUTS/NOTES ARE IN MILLIMETERS (mm) UNLESS OTHERWISE NOTED.

Sheet Reference Number: M-101
 Sheet 58 of 91

ADAL C-130J AIRCREW FUSELAGE TRAINER
 LRAFB, LITTLE ROCK AR.
 Project No. NKAK 043005

HVAC FLOOR PLAN

DEPARTMENT OF THE ARMY
 U.S. ARMY CORPS OF ENGINEERS
 LITTLE ROCK DISTRICT
 LITTLE ROCK, ARKANSAS

Atkins Benham
 (918) 492-1600 www.atkinsbenham.com
 a member of the WS Atkins group of companies

Designed by: GG	Drawn by: MB	Contract Date:
Reviewed by: PFD	Drwg. Code:	File Name: 151001M-101
Submitted by:	Plot date: 02/04/03	Plot scale: 1:1
Atkins Benham, Inc.	Contract No.:	DW03-03-B-
Invitation No.:		
DW03-03-R-0021		

Mark	Description	Date	Appr.	Mark	Description	Date	Appr.

U.S. ARMY CORPS OF ENGINEERS
 LITTLE ROCK DISTRICT