


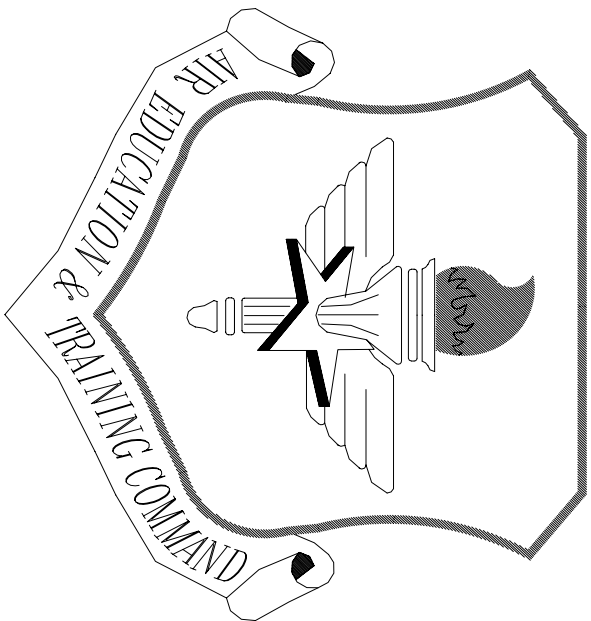

LITTLE ROCK A.F.B.
ARKANSAS


Civil Engineer	Chief Engineer
Chief of Operations	Bio Environmental Eng.
Fire Chief	Safety
Program Manager	Issng Agency

No.	Revision/Issue	Date	BY	APP'D
3	Equipment layout change of FCU 66 – Platform detail added			
2	Ductwork location changed to accommodate lack of space			
1	Ductwork moves up into attic and drops down over vent			


TEMPORARY LODGING
FACILITY

PARTIAL SECOND FLOOR
HVAC DUCTWORK PLAN
AS-BUILT

Drawn by TNS	Lead Designer WET
Tech Reviewer TNS	File Location NKA02-5001
Designed by TNS	Project Number NKA02-5001
Date 28 May 2002	Sheet M4
Scale AS NOTED	71 of 108

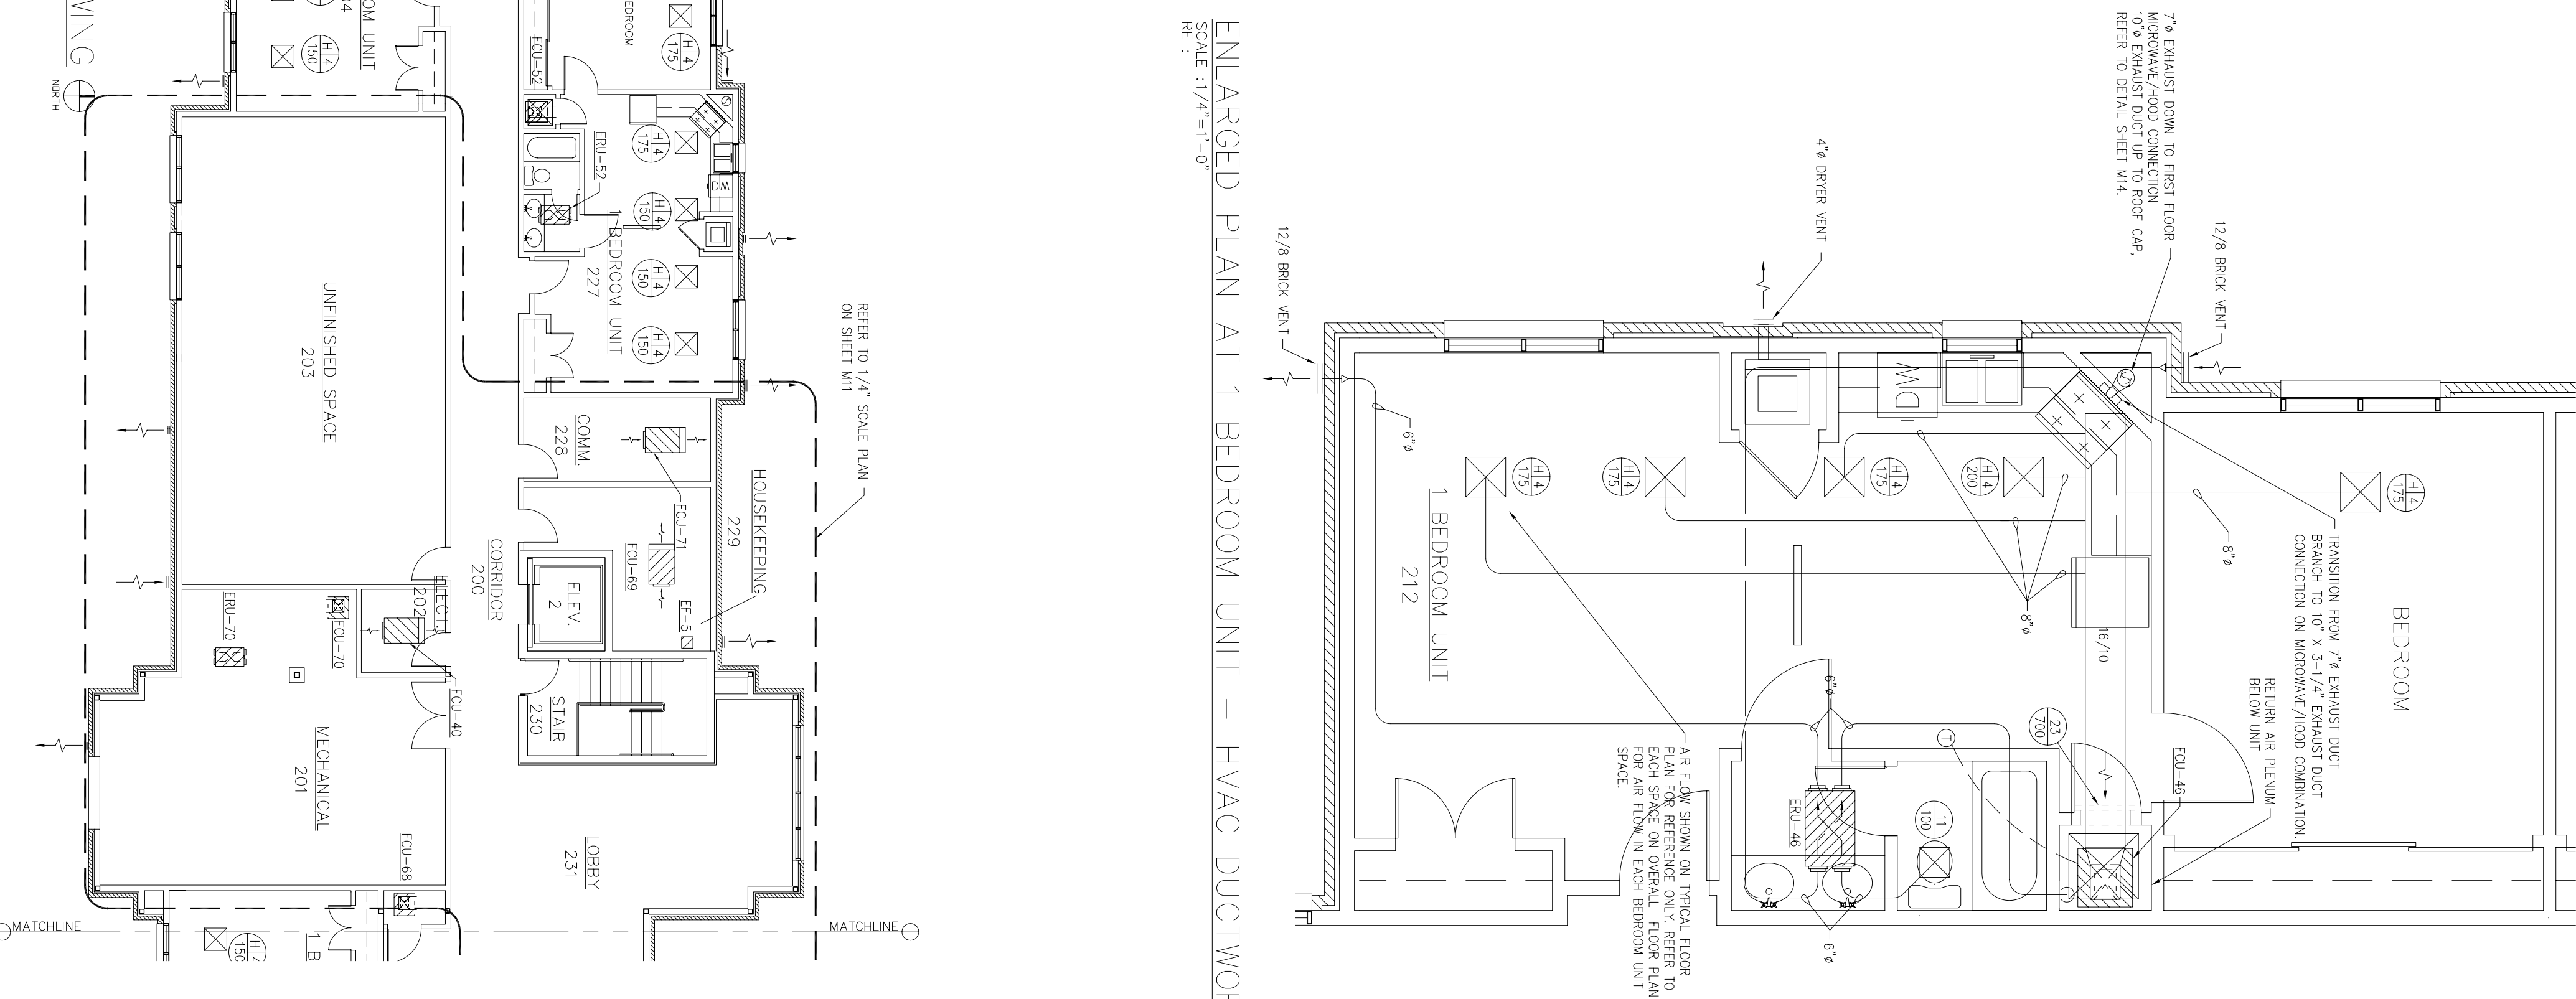

2 ENLARGED PLAN AT 1 BEDROOM UNIT – HVAC DUCTWORK
SCALE: 1/4"=1'-0"
RE: 1

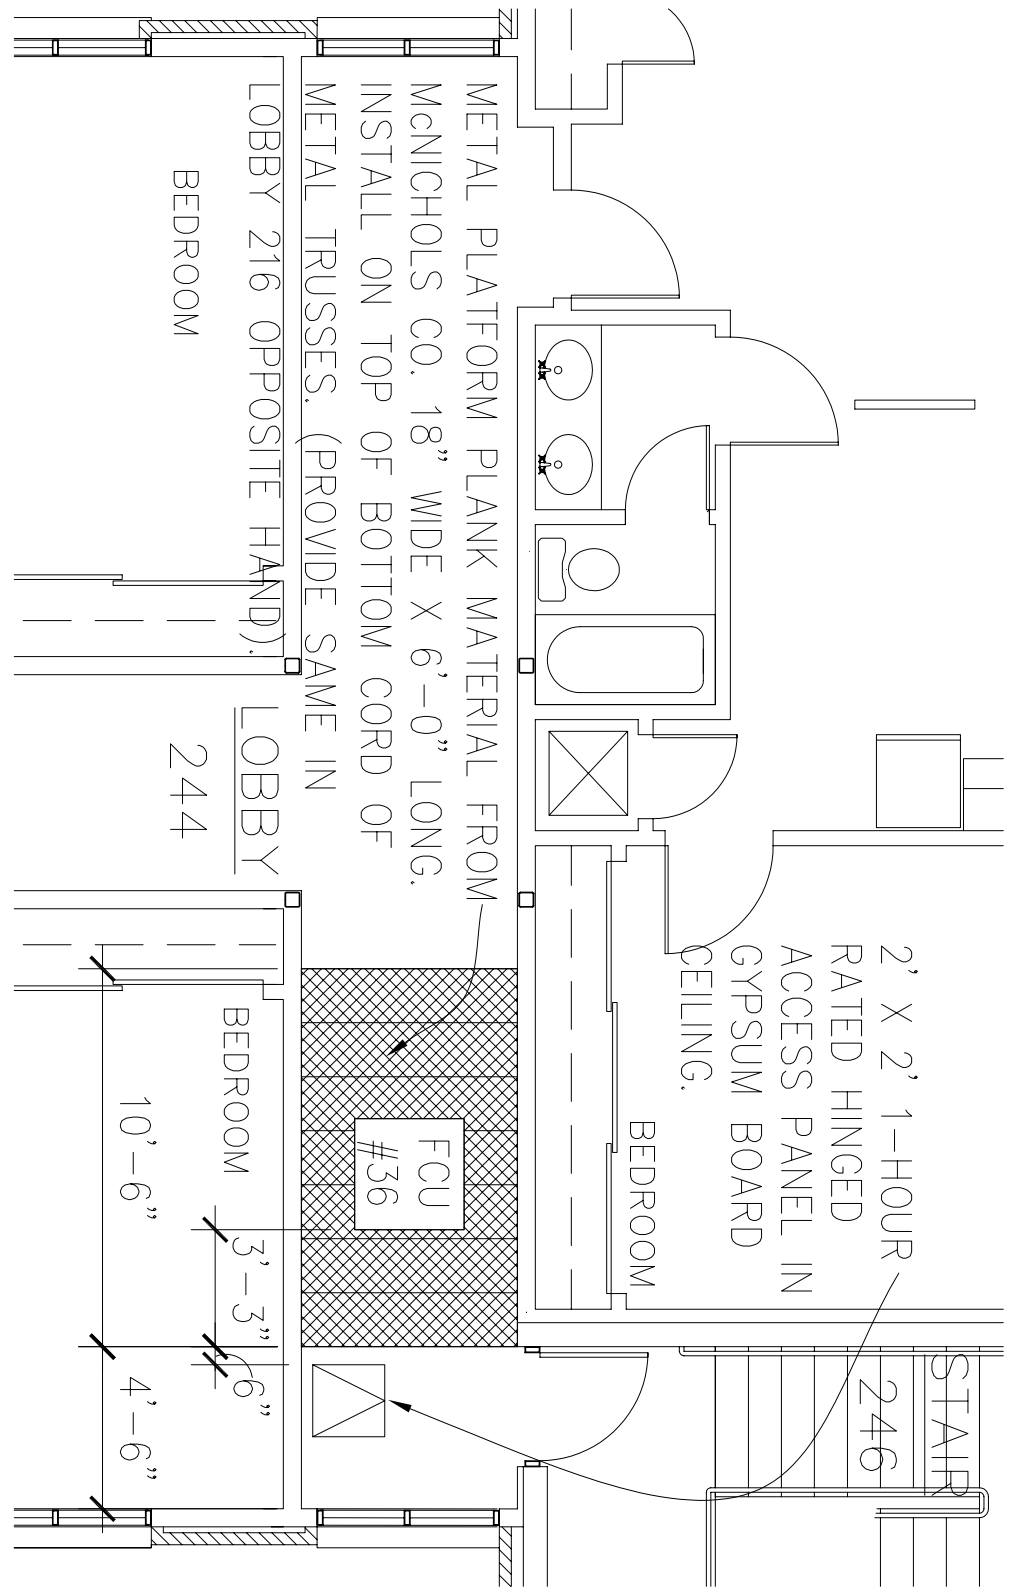

3 AS-BUILT PLATFORM DETAIL
SCALE: 3/16"=1'-0"
RE: 1

