


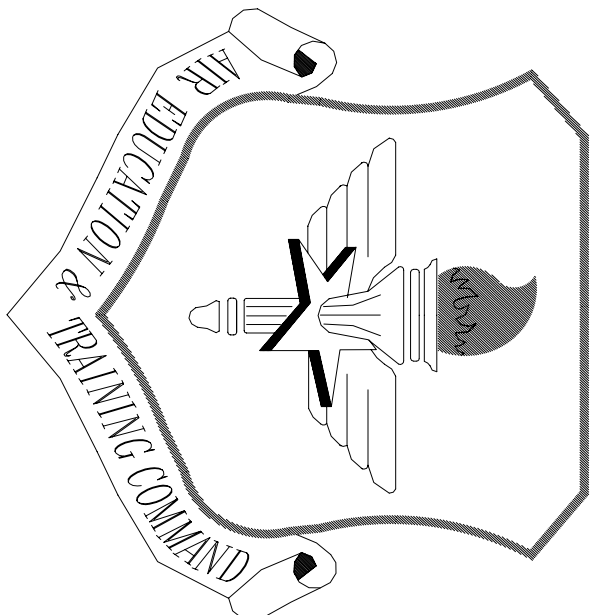

LITTLE ROCK A.F.B.
ARKANSAS


OWN ENGINEER	CHIEF ENGINEER
CHIEF OF OPERATIONS	BIO ENVIRONMENTAL ENG.
FIRE CHIEF	SAFETY
PROGRAM MANAGER	USING AGENCY

No.	Revision/Issue	Date	BY	APP'D
3	Added detail showing difference in trunk lines on the second floor			
2	Added Typical ERU Elevation			
1	Changes in duct locations			


PROJECT TITLE
TEMPORARY LODGING
FACILITY

SHEET TITLE
PARTIAL SECOND FLOOR
HVAC DUCTWORK PLAN
AS-BUILT




DRAWN BY TNS	LEAD DESIGNER WET
TECH. ENGINEER	FILE LOCATION
DESIGNED BY TNS	PROJECT NUMBER NNAK02-5001
DATE 28 MAY 2002	SHEET M5
SCALE AS NOTED	72 OF 108

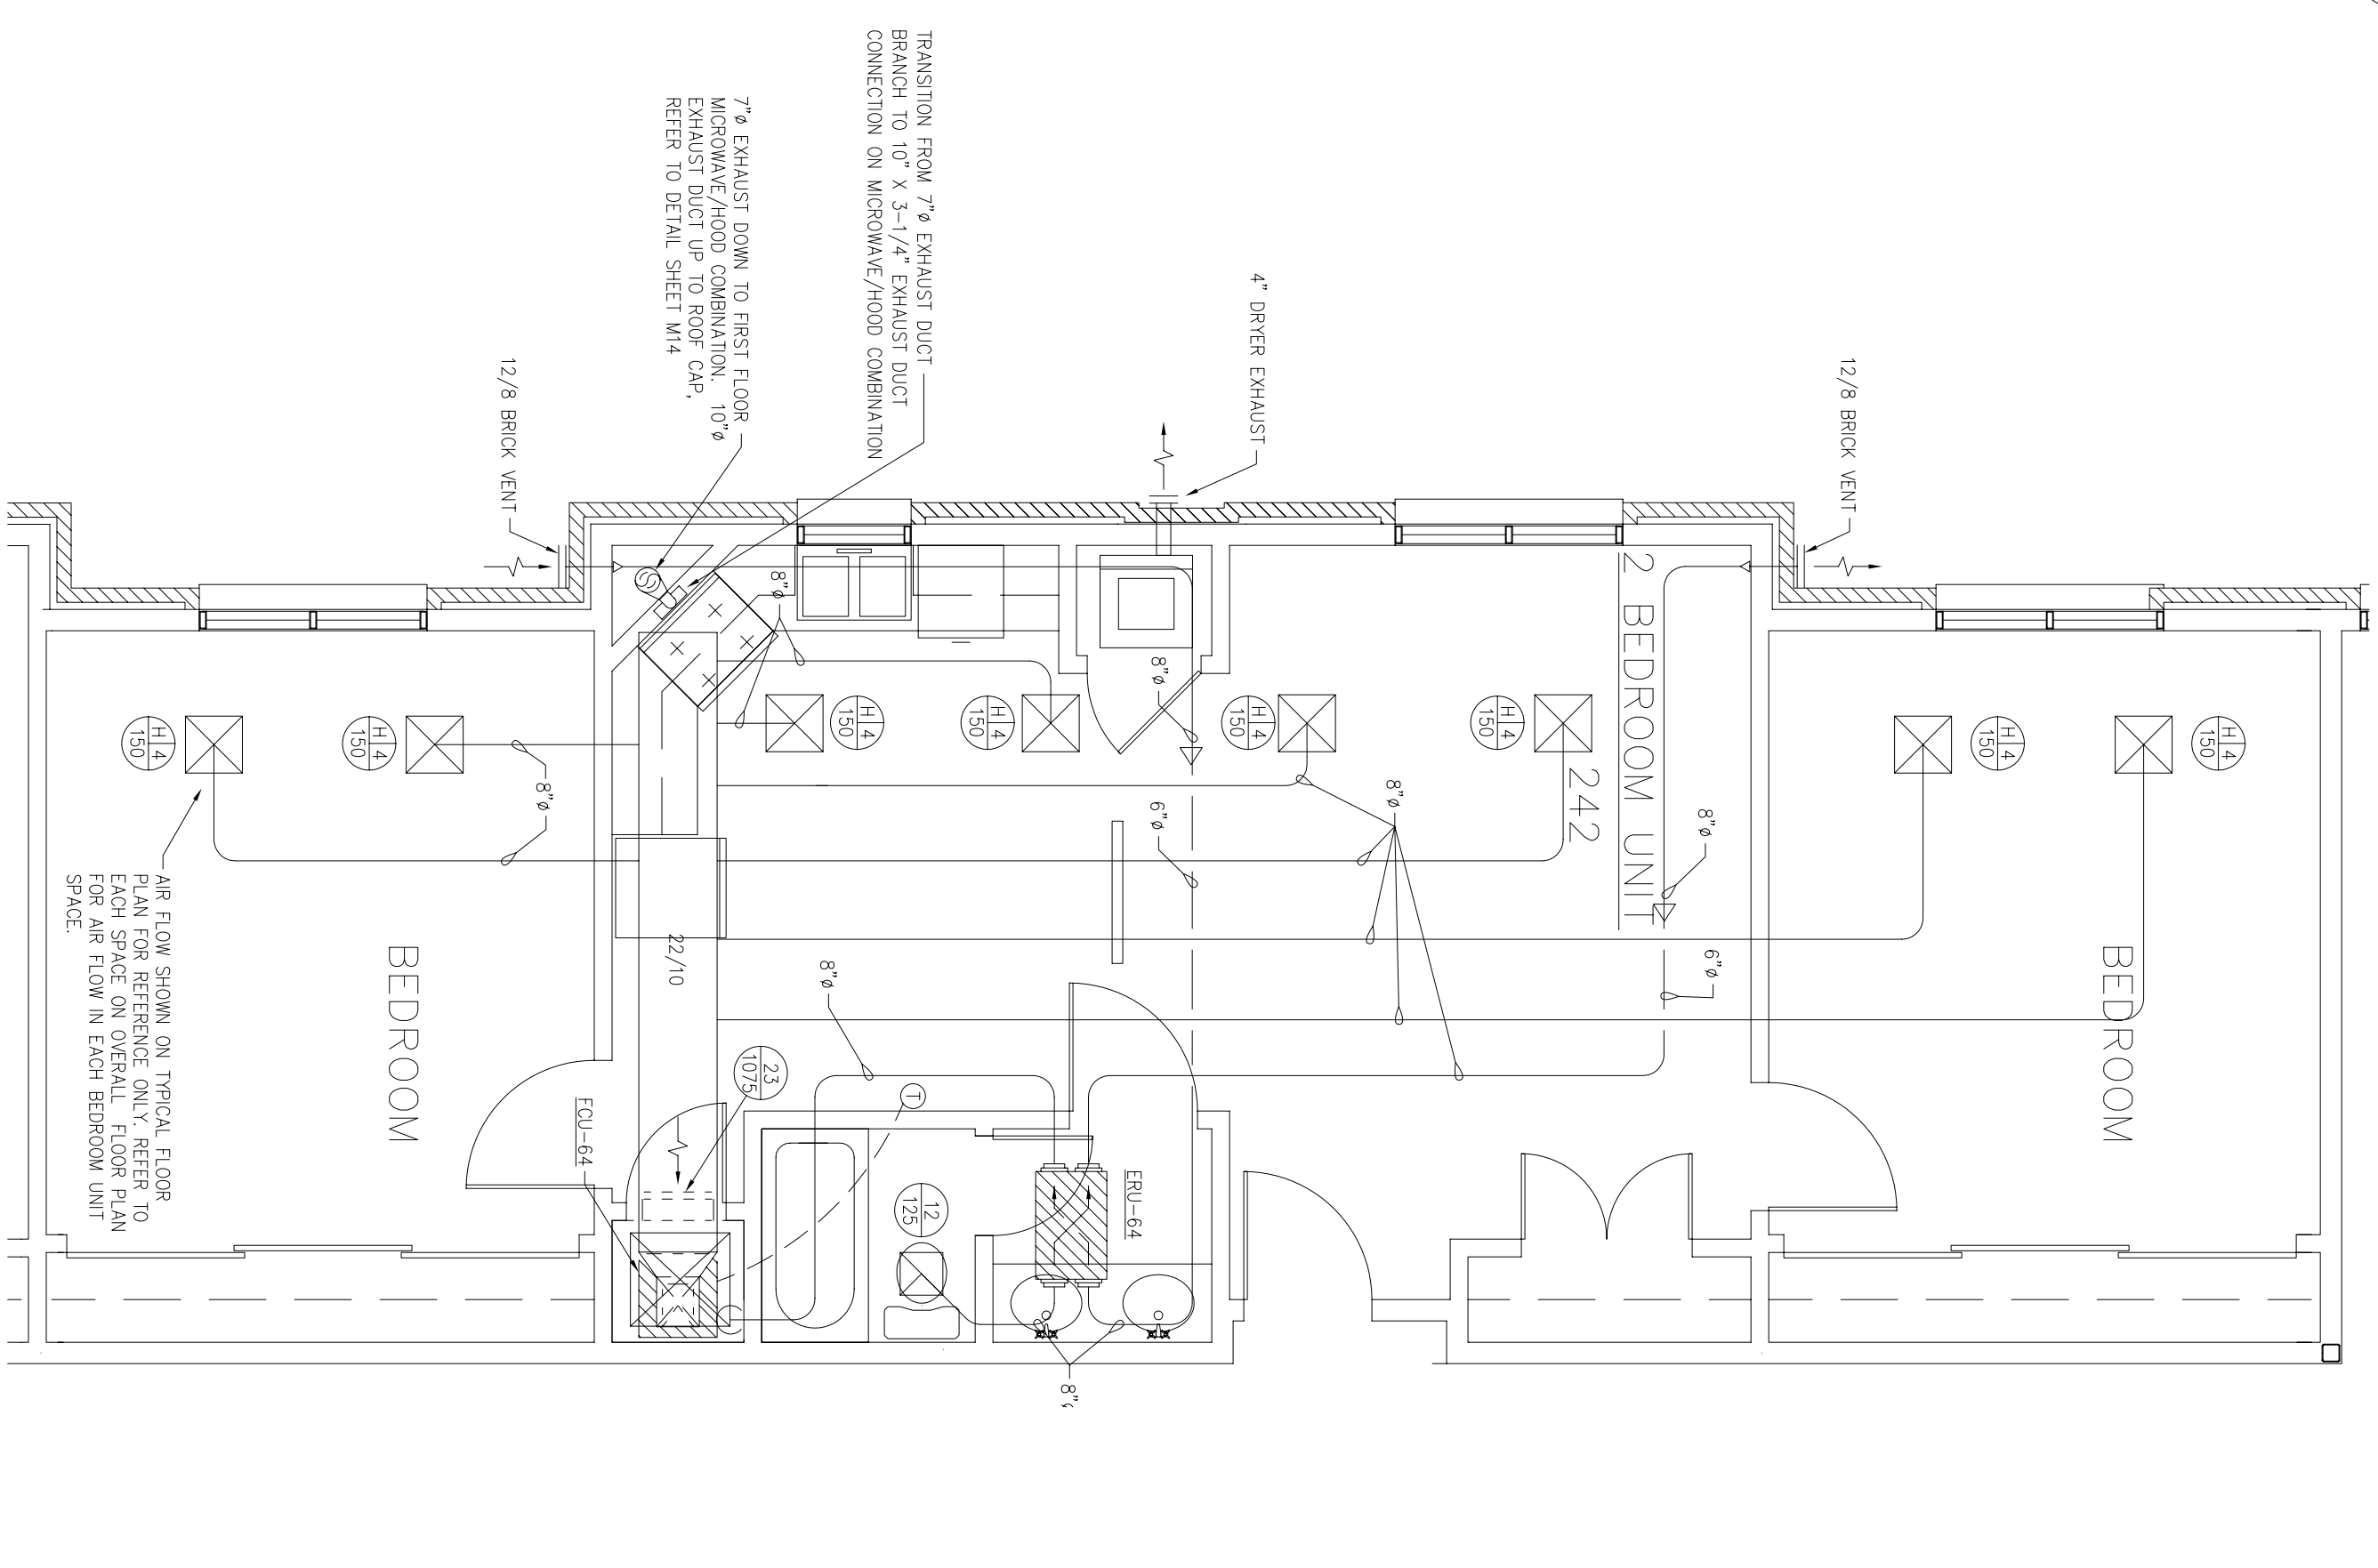

2 ENLARGED PLAN AT 2 BEDROOM UNIT – HVAC DUCTWORK
SCALE : 1/4"=1'-0"
RE :

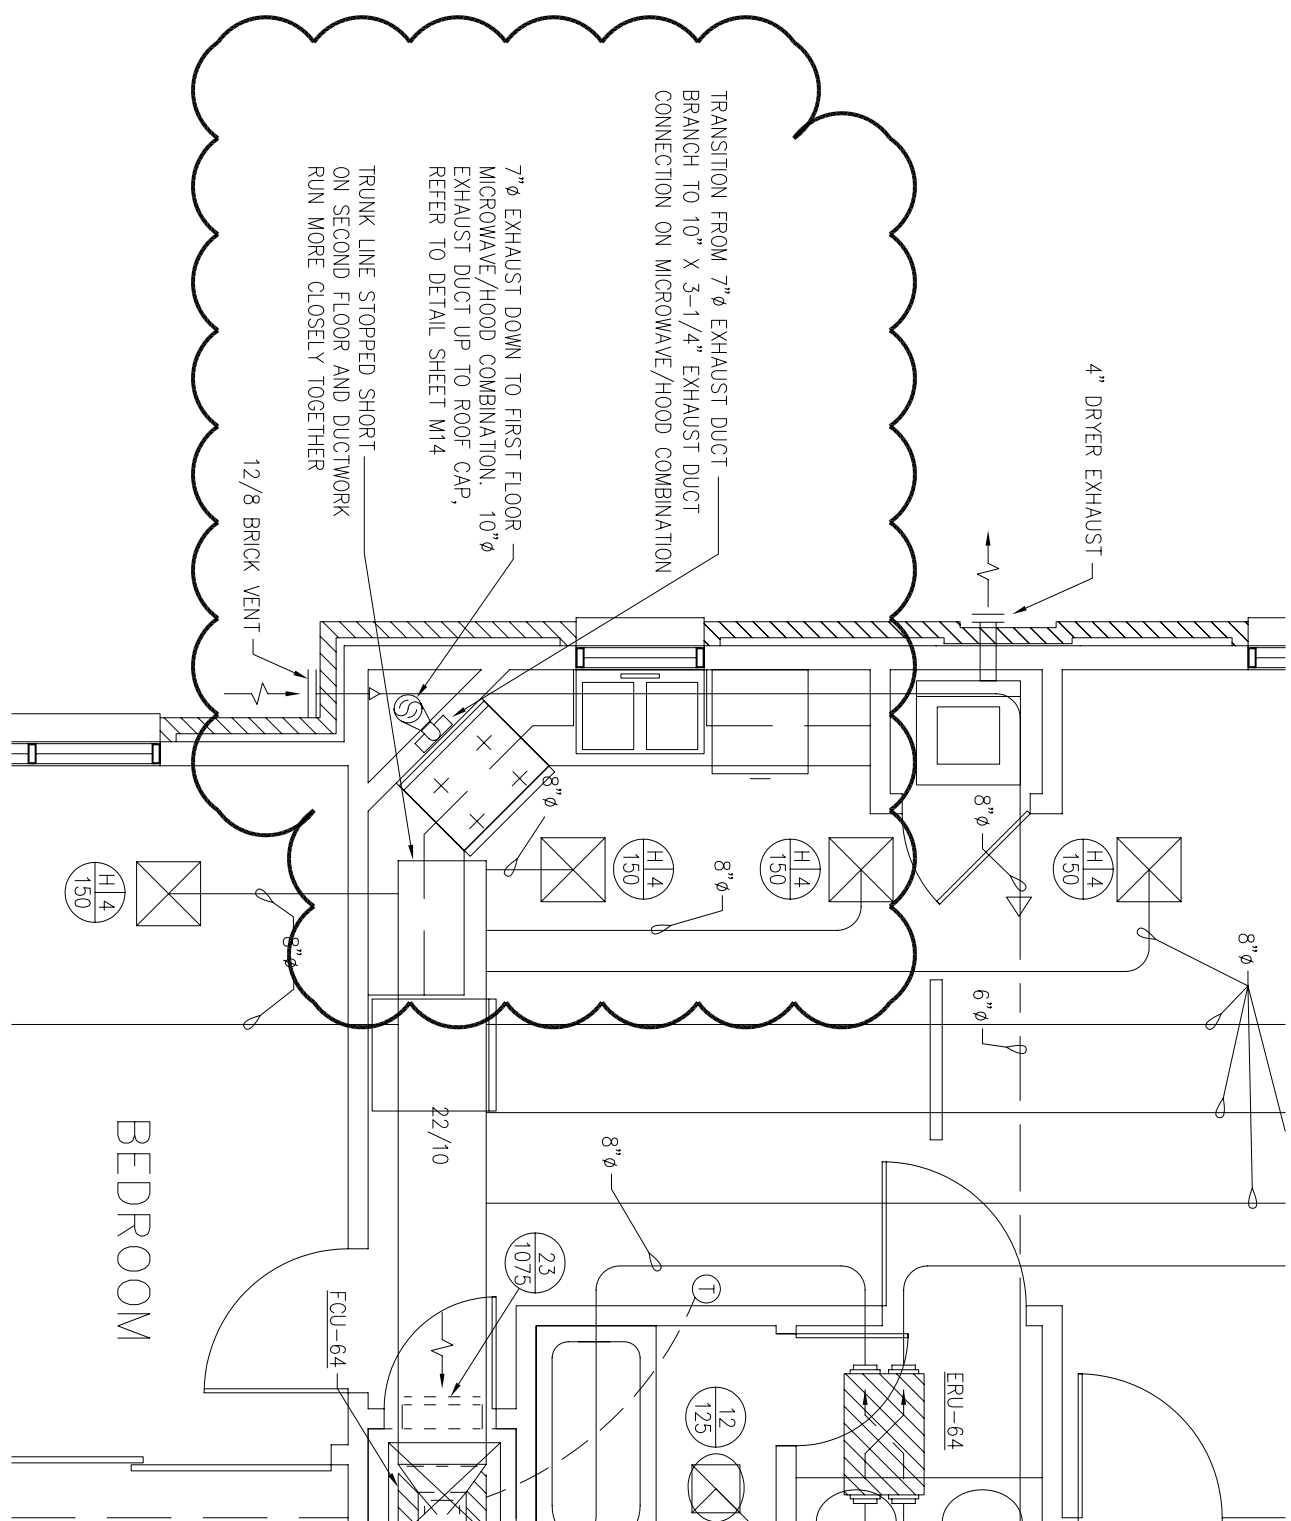

3 ENLARGED PLAN AT 2 BEDROOM UNIT
HVAC DUCTWORK (2ND FLOOR)
SCALE : 1/4"=1'-0"
RE :

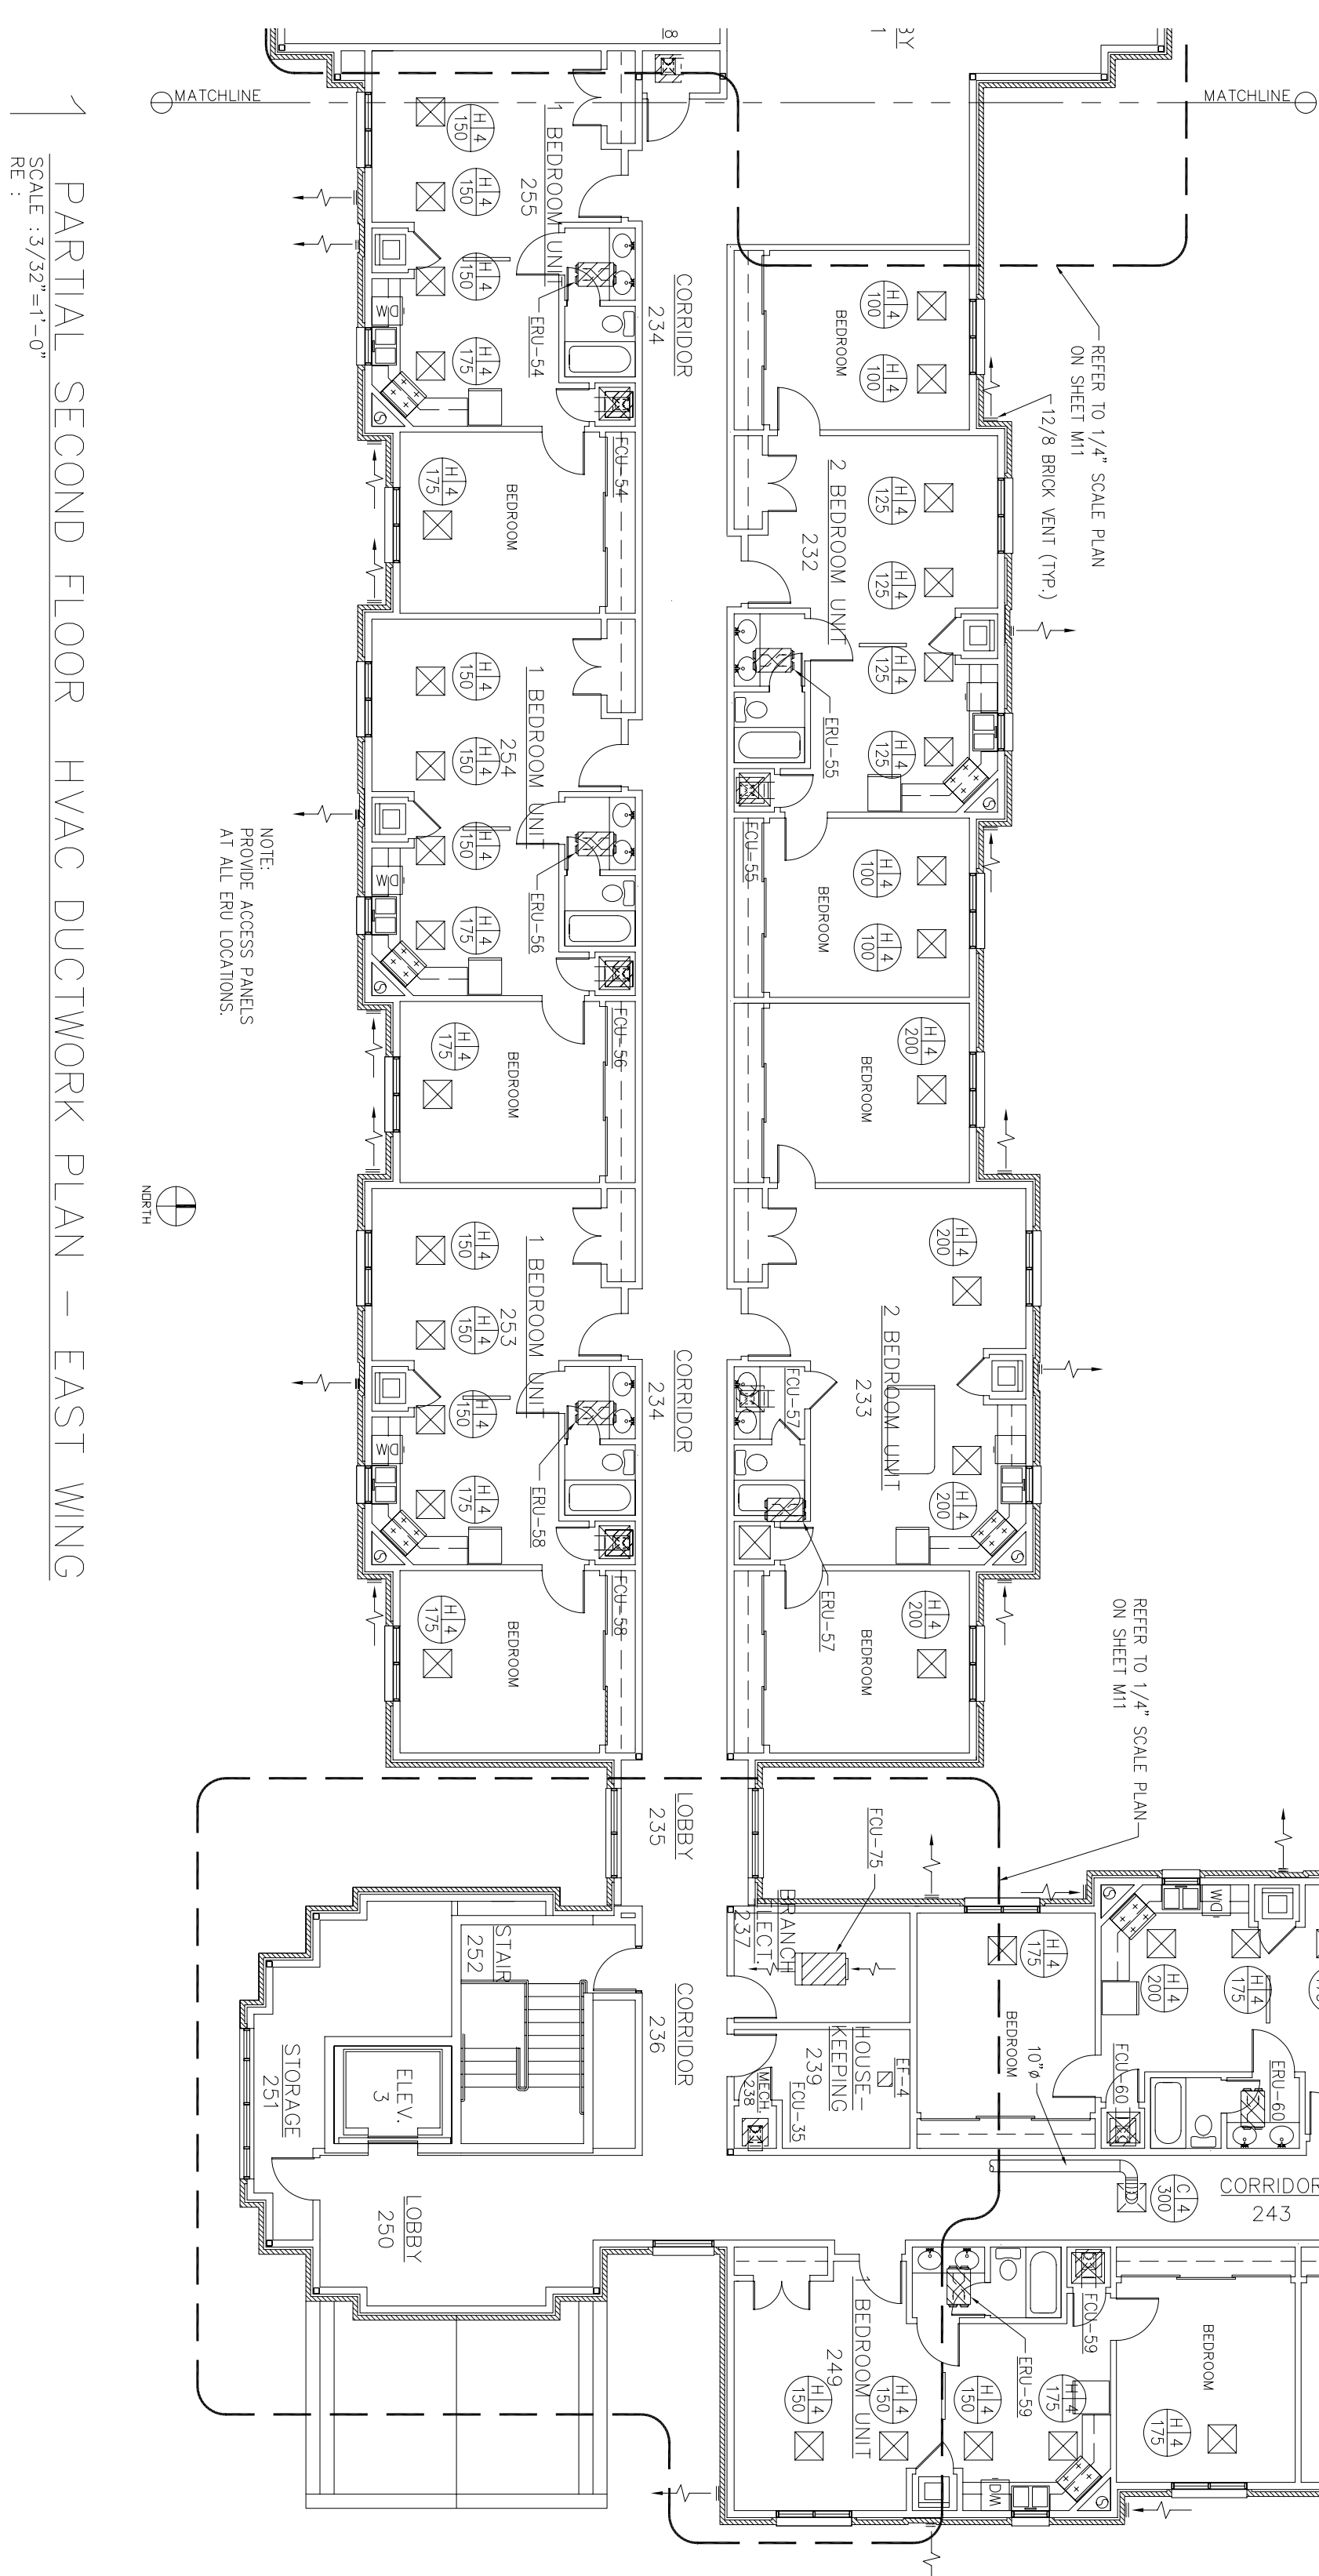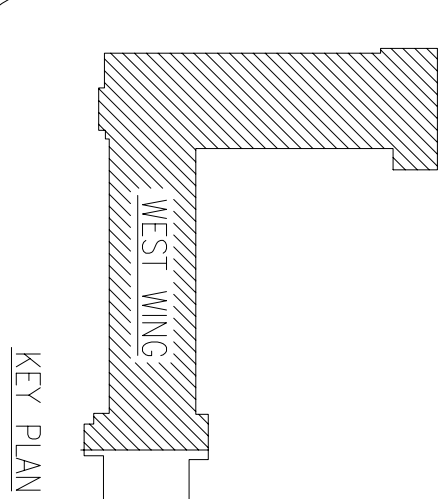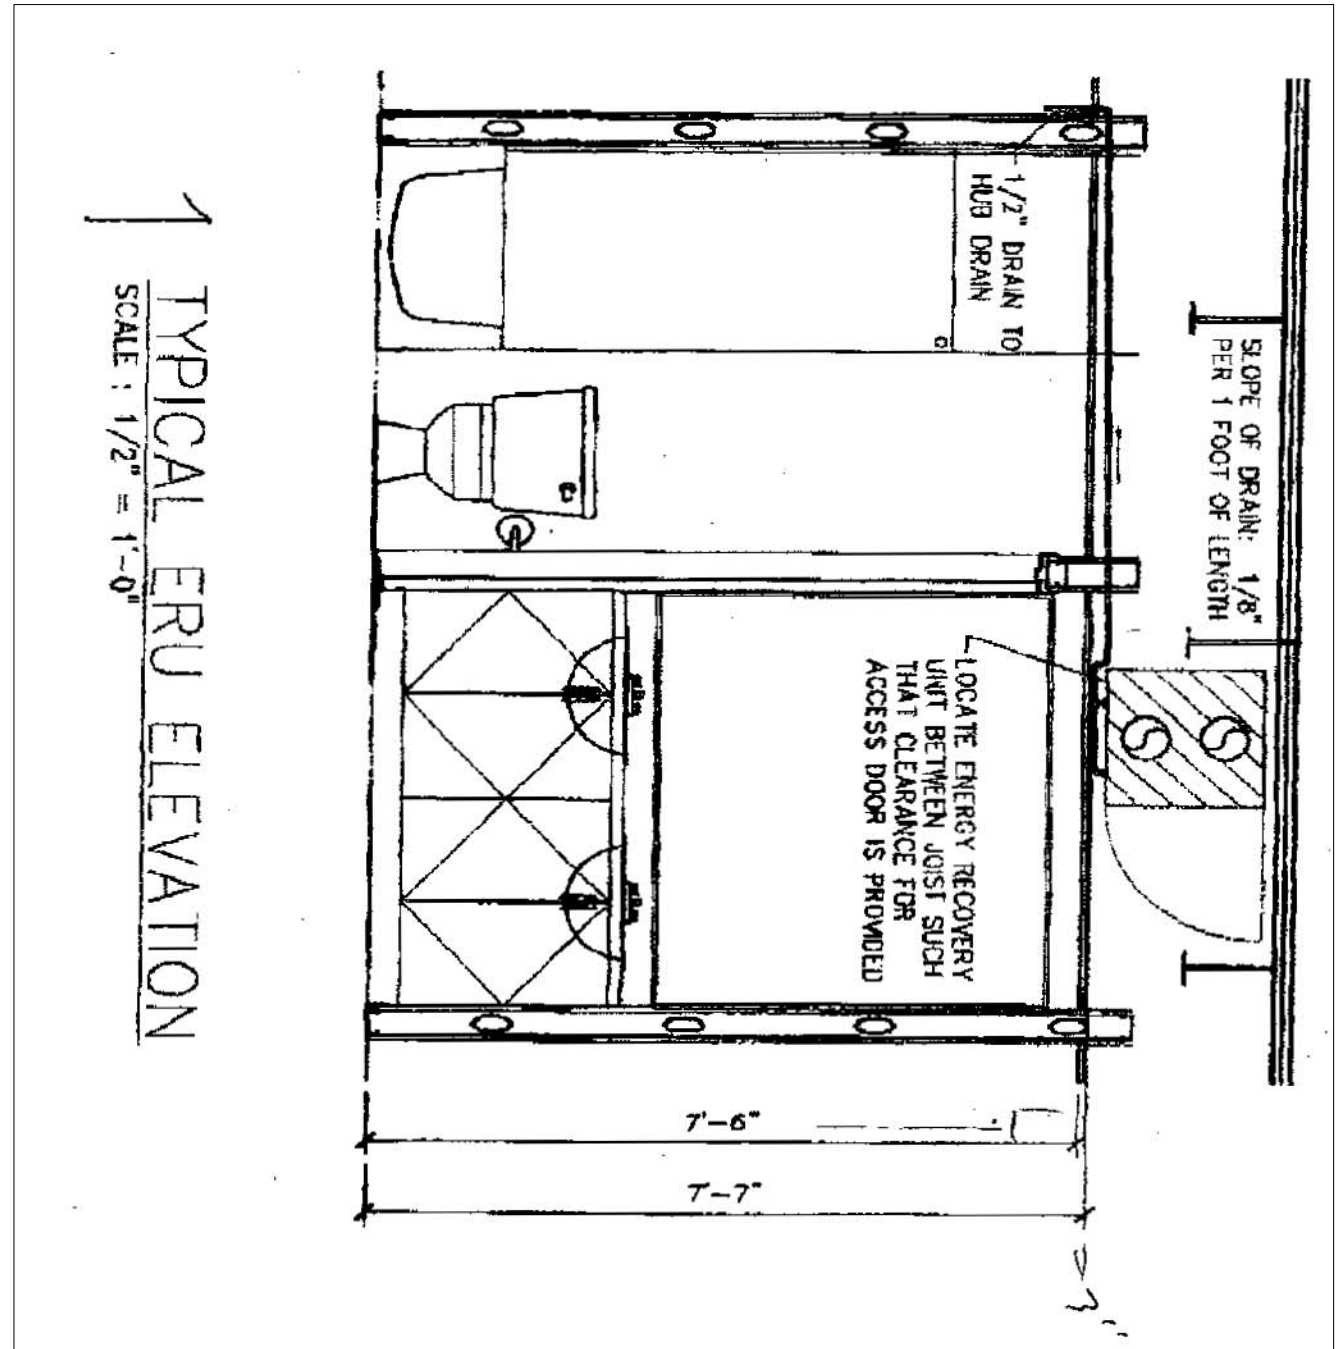

1 PARTIAL SECOND FLOOR HVAC DUCTWORK PLAN – EAST WING
SCALE : 3/32"=1'-0"
RE :