

LITTLE ROCK A.F.B.
ARKANSAS


CIVIL ENGINEER	CHIEF ENGINEER
CHIEF OF OPERATIONS	BIO ENVIRONMENTAL ENG.
FIRE CHIEF	SAFETY
PROGRAM MANAGER	USING AGENCY

No.	Revision/Issue	Date	BY	APP'D
1	No Changes from Design to As-Built			

PROJECT TITLE
TEMPORARY LODGING FACILITY

SHEET TITLE
PARTIAL FIRST FLOOR HVAC PIPING PLAN AS-BUILT

DRAWN BY VMI	LEAD DESIGNER WET
TECH REVIEWER	FILE LOCATION
DESIGNED BY NNS	PROJECT NUMBER NKA02-5001
DATE 28 MAY 2002	SHEET M7
SCALE 3/32"=1'-0"	74 of 108

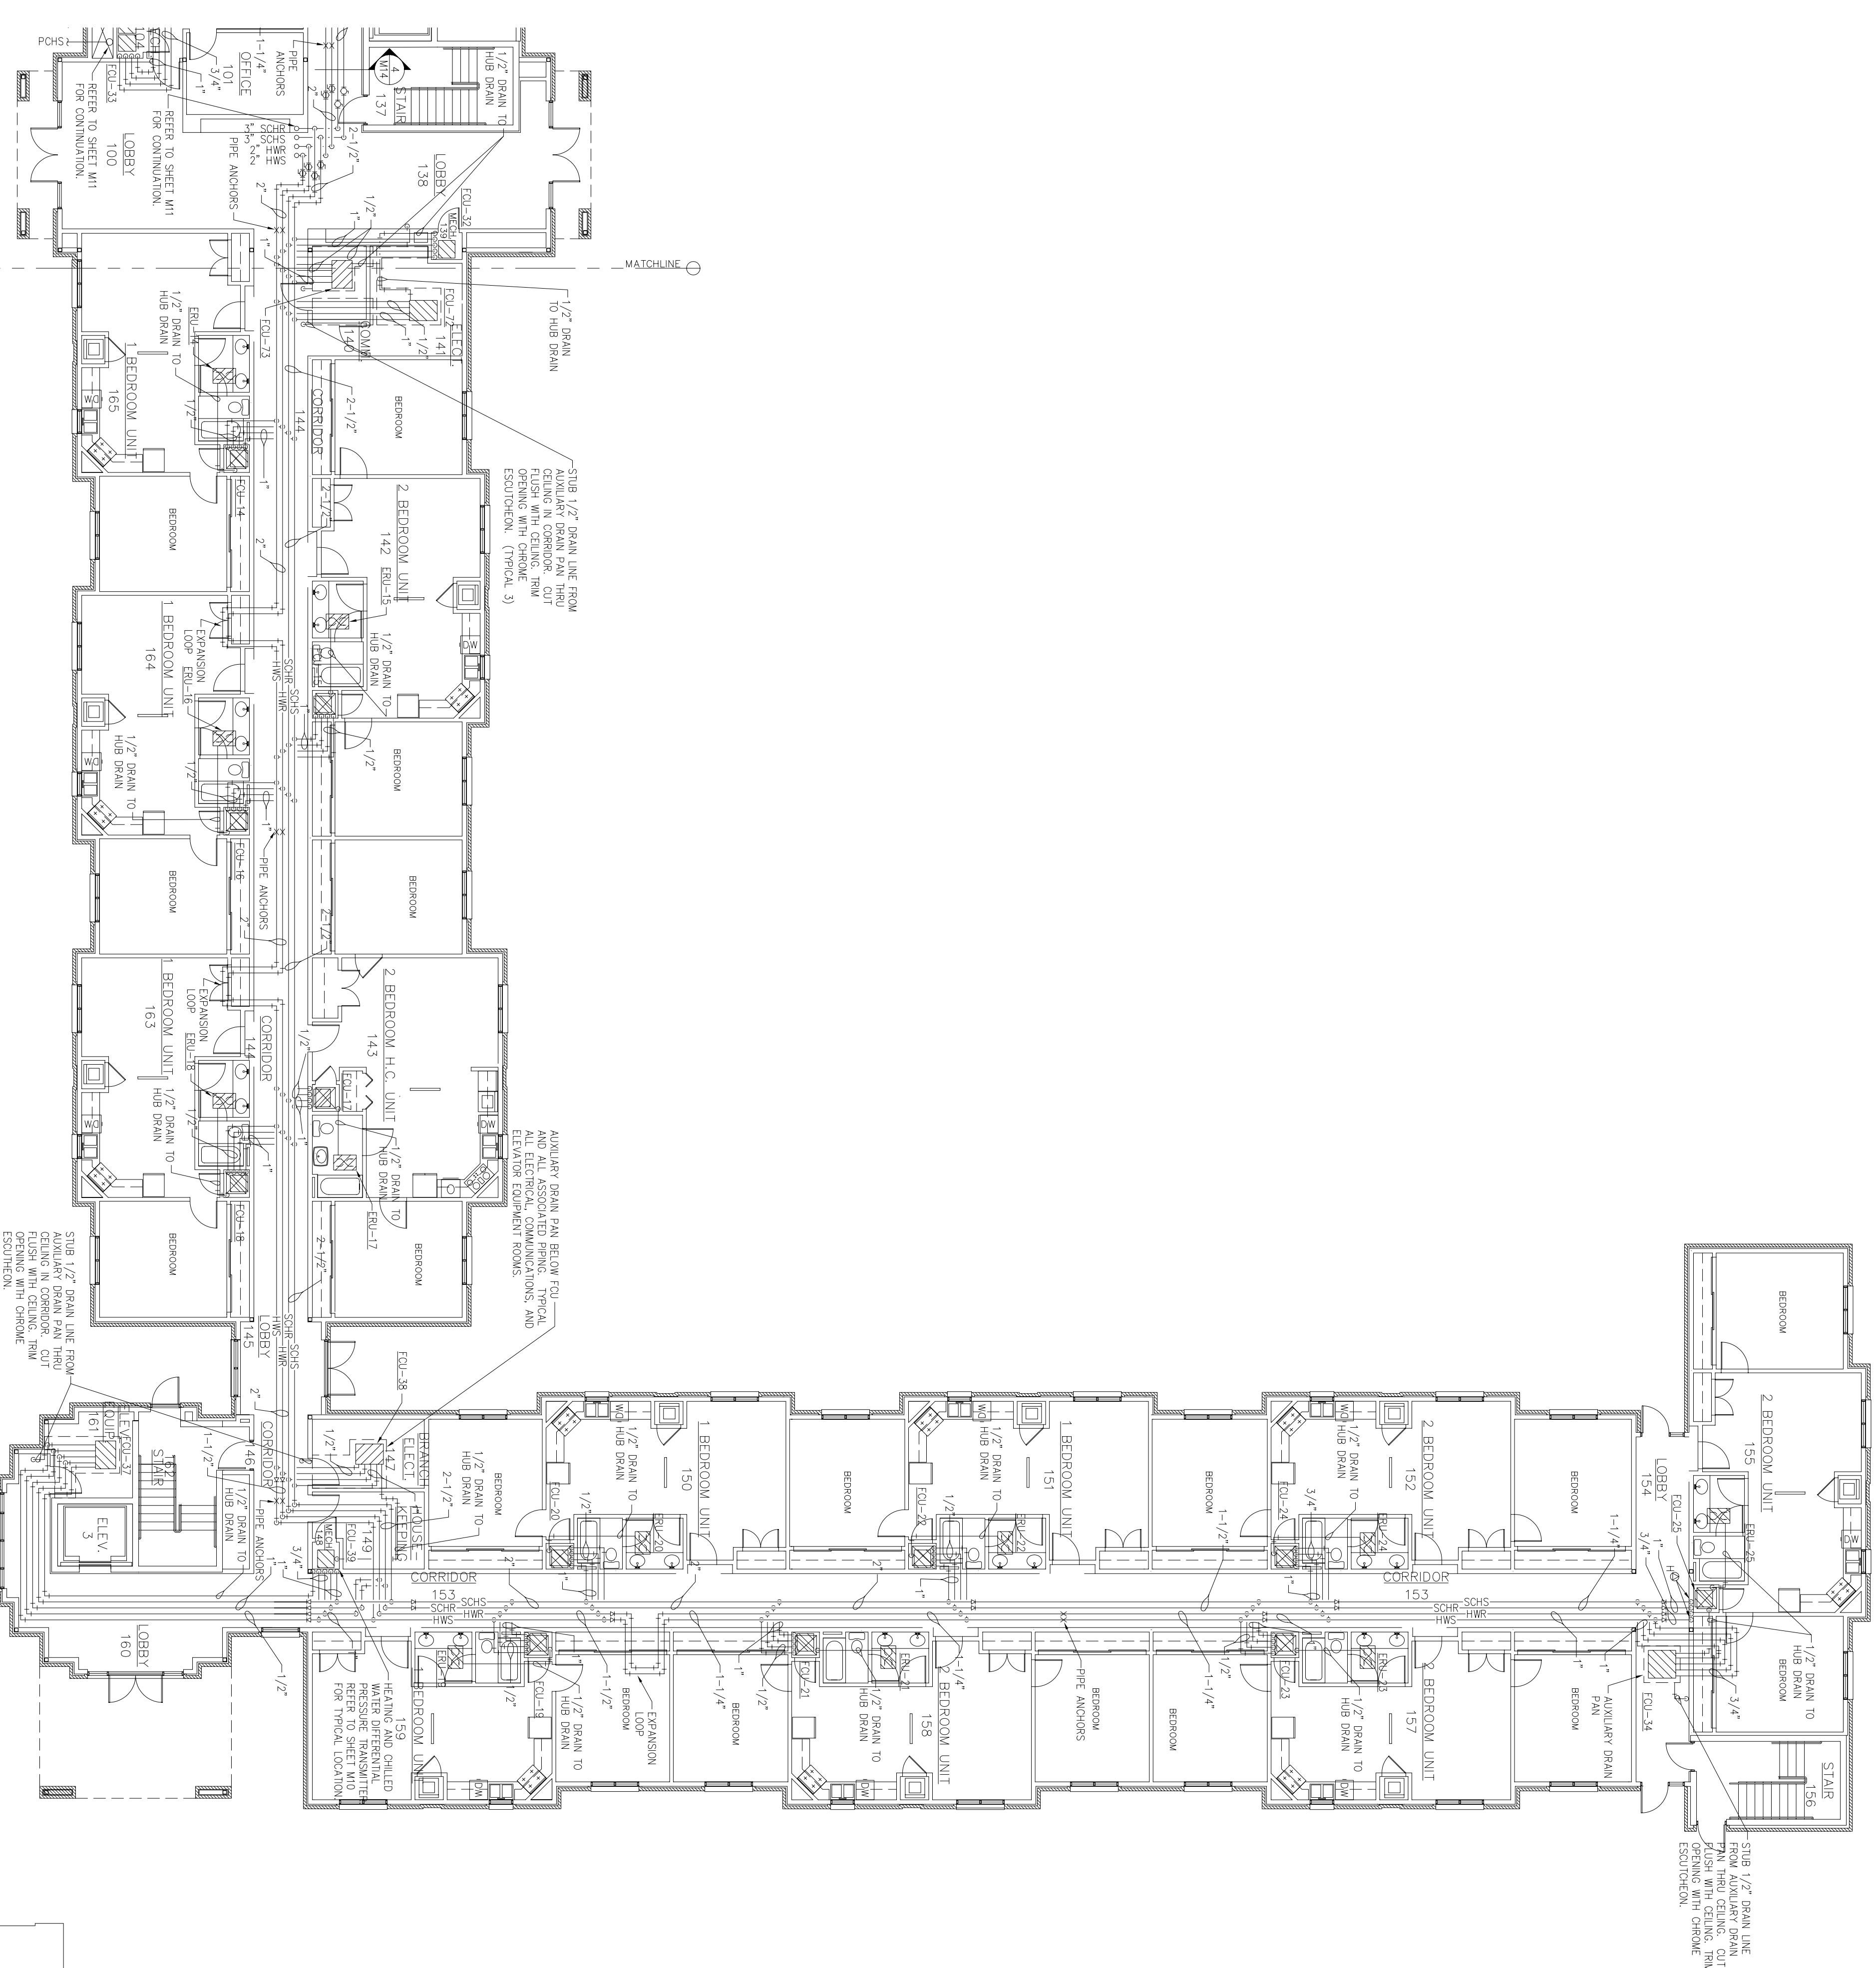

PARTIAL FIRST FLOOR HVAC PIPING PLAN - EAST WING
SCALE 3/32"=1'-0"

