


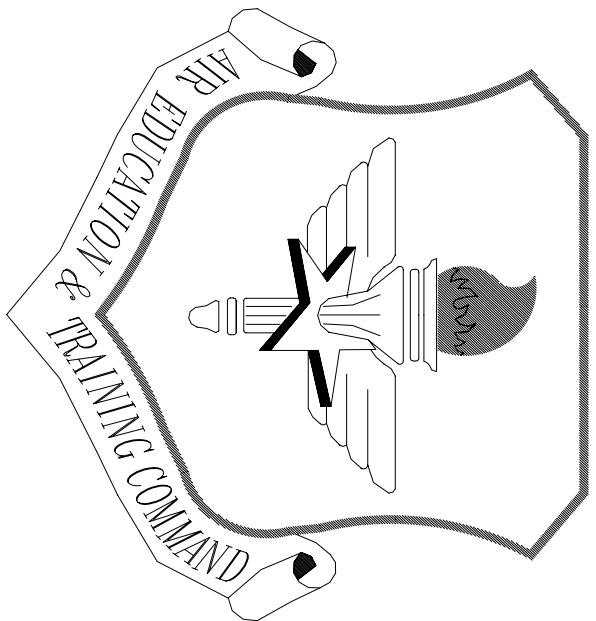

LITTLE ROCK A.F.B.
ARKANSAS



Civil Engineer	Chief Engineer
Chief of Operations	Bio Environmental Eng.
Fire Chief	Safety
Program Manager	Using Agency

No.	Revision/Issue	Date	BY	APP'D
1	No Changes from Design to As-Built			

PROJECT TITLE
TEMPORARY LODGING
FACILITY

SHEET TITLE
PARTIAL SECOND FLOOR
HVAC PIPING PLAN
AS-BUILT

Drawn by VMI	Lead Designer WEI
Tech Reviewer TNS	File Location
Designed by TNS	Project Number NKA02-5001
Date 28 MAY 2002	Sheet M8
Scale 3/32"=1'-0"	75 of 108

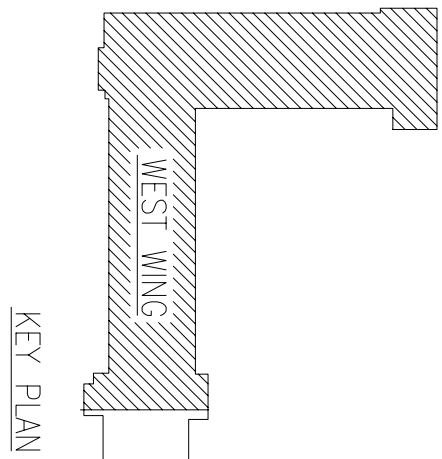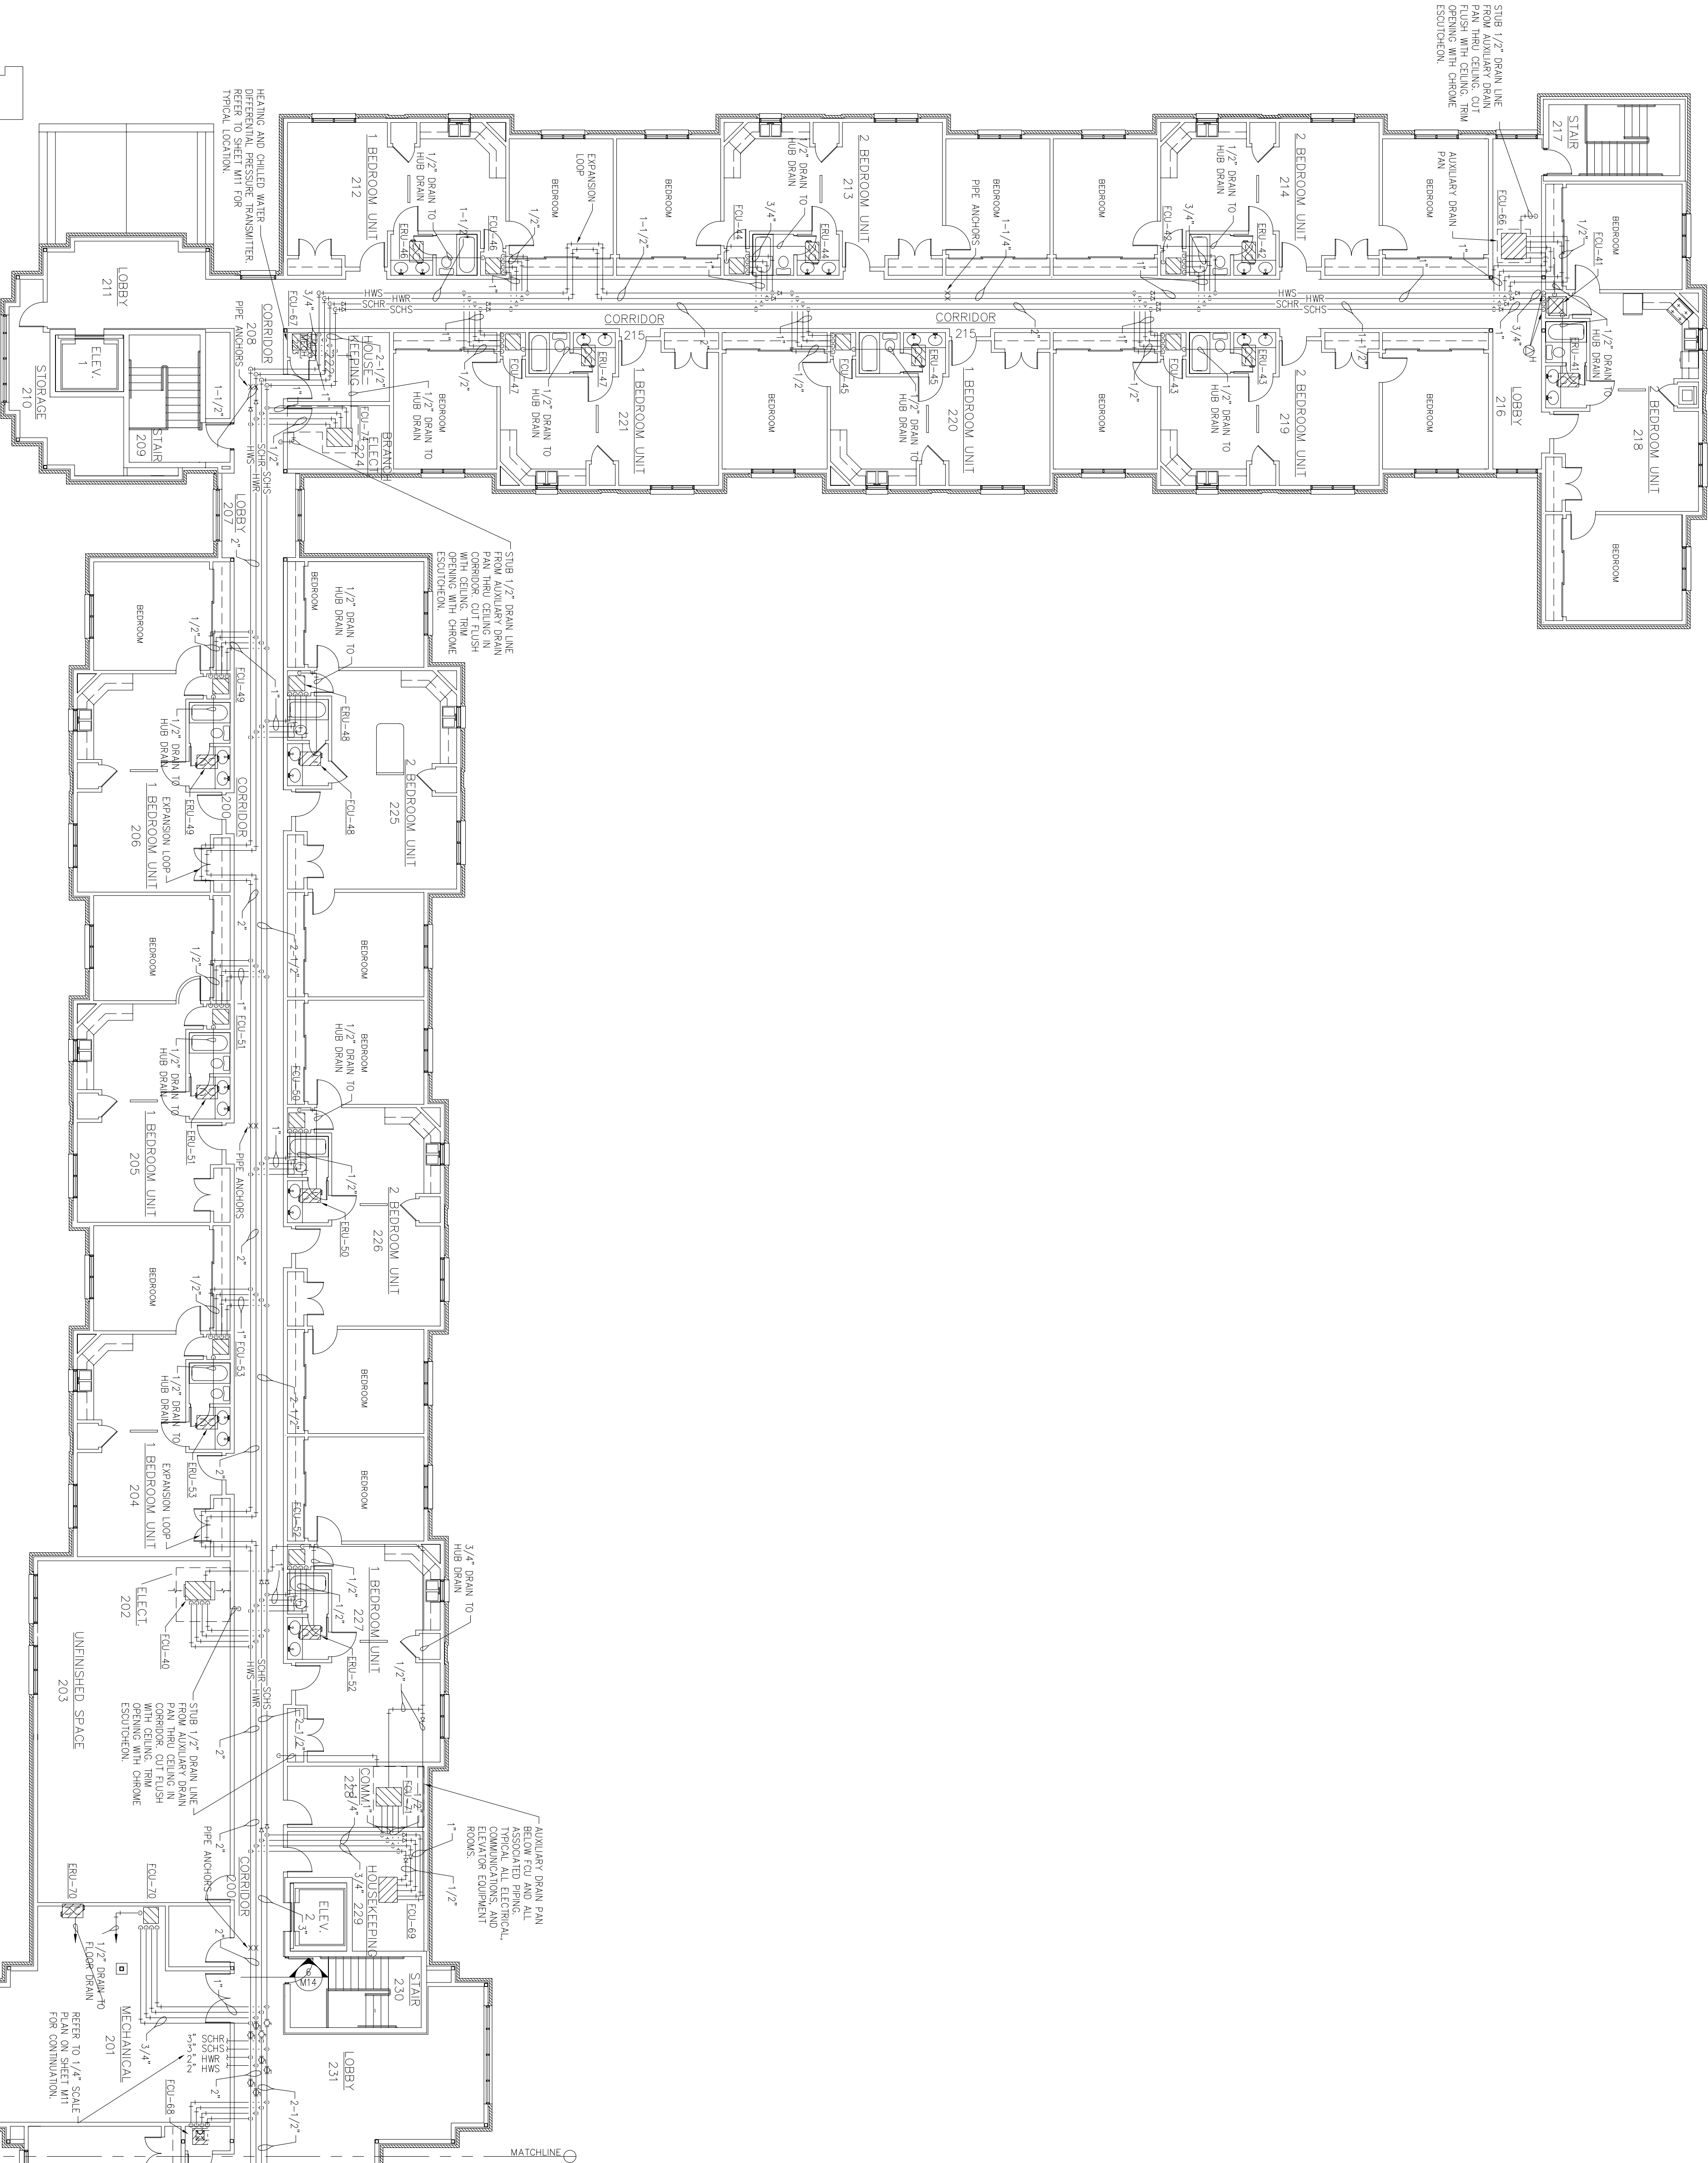

1 PARTIAL SECOND FLOOR HVAC PIPING PLAN – WEST WING
SCALE 3/32"=1'-0"
REF: 108