

LITTLE ROCK A.F.B.
ARKANSAS


CIVIL ENGINEER	CHIEF ENGINEER
CHIEF OF OPERATIONS	BIO ENVIRONMENTAL ENG.
FIRE CHIEF	SAFETY
PROGRAM MANAGER	USING AGENCY

No.	Revision/Issue	Date	BY	APP'D
1	No Changes from Design to As-Built			

PROJECT TITLE
TEMPORARY LODGING FACILITY

SHEET TITLE
PARTIAL SECOND FLOOR PLANS - HVAC AS-BUILT

DRAWN BY TNS	LEAD DESIGNER WET
DESIGNED BY TNS	PROJECT NUMBER NKAHQ2-5001
DATE 28 MAY 2002	SHEET M111
SCALE AS NOTED	78 of 108

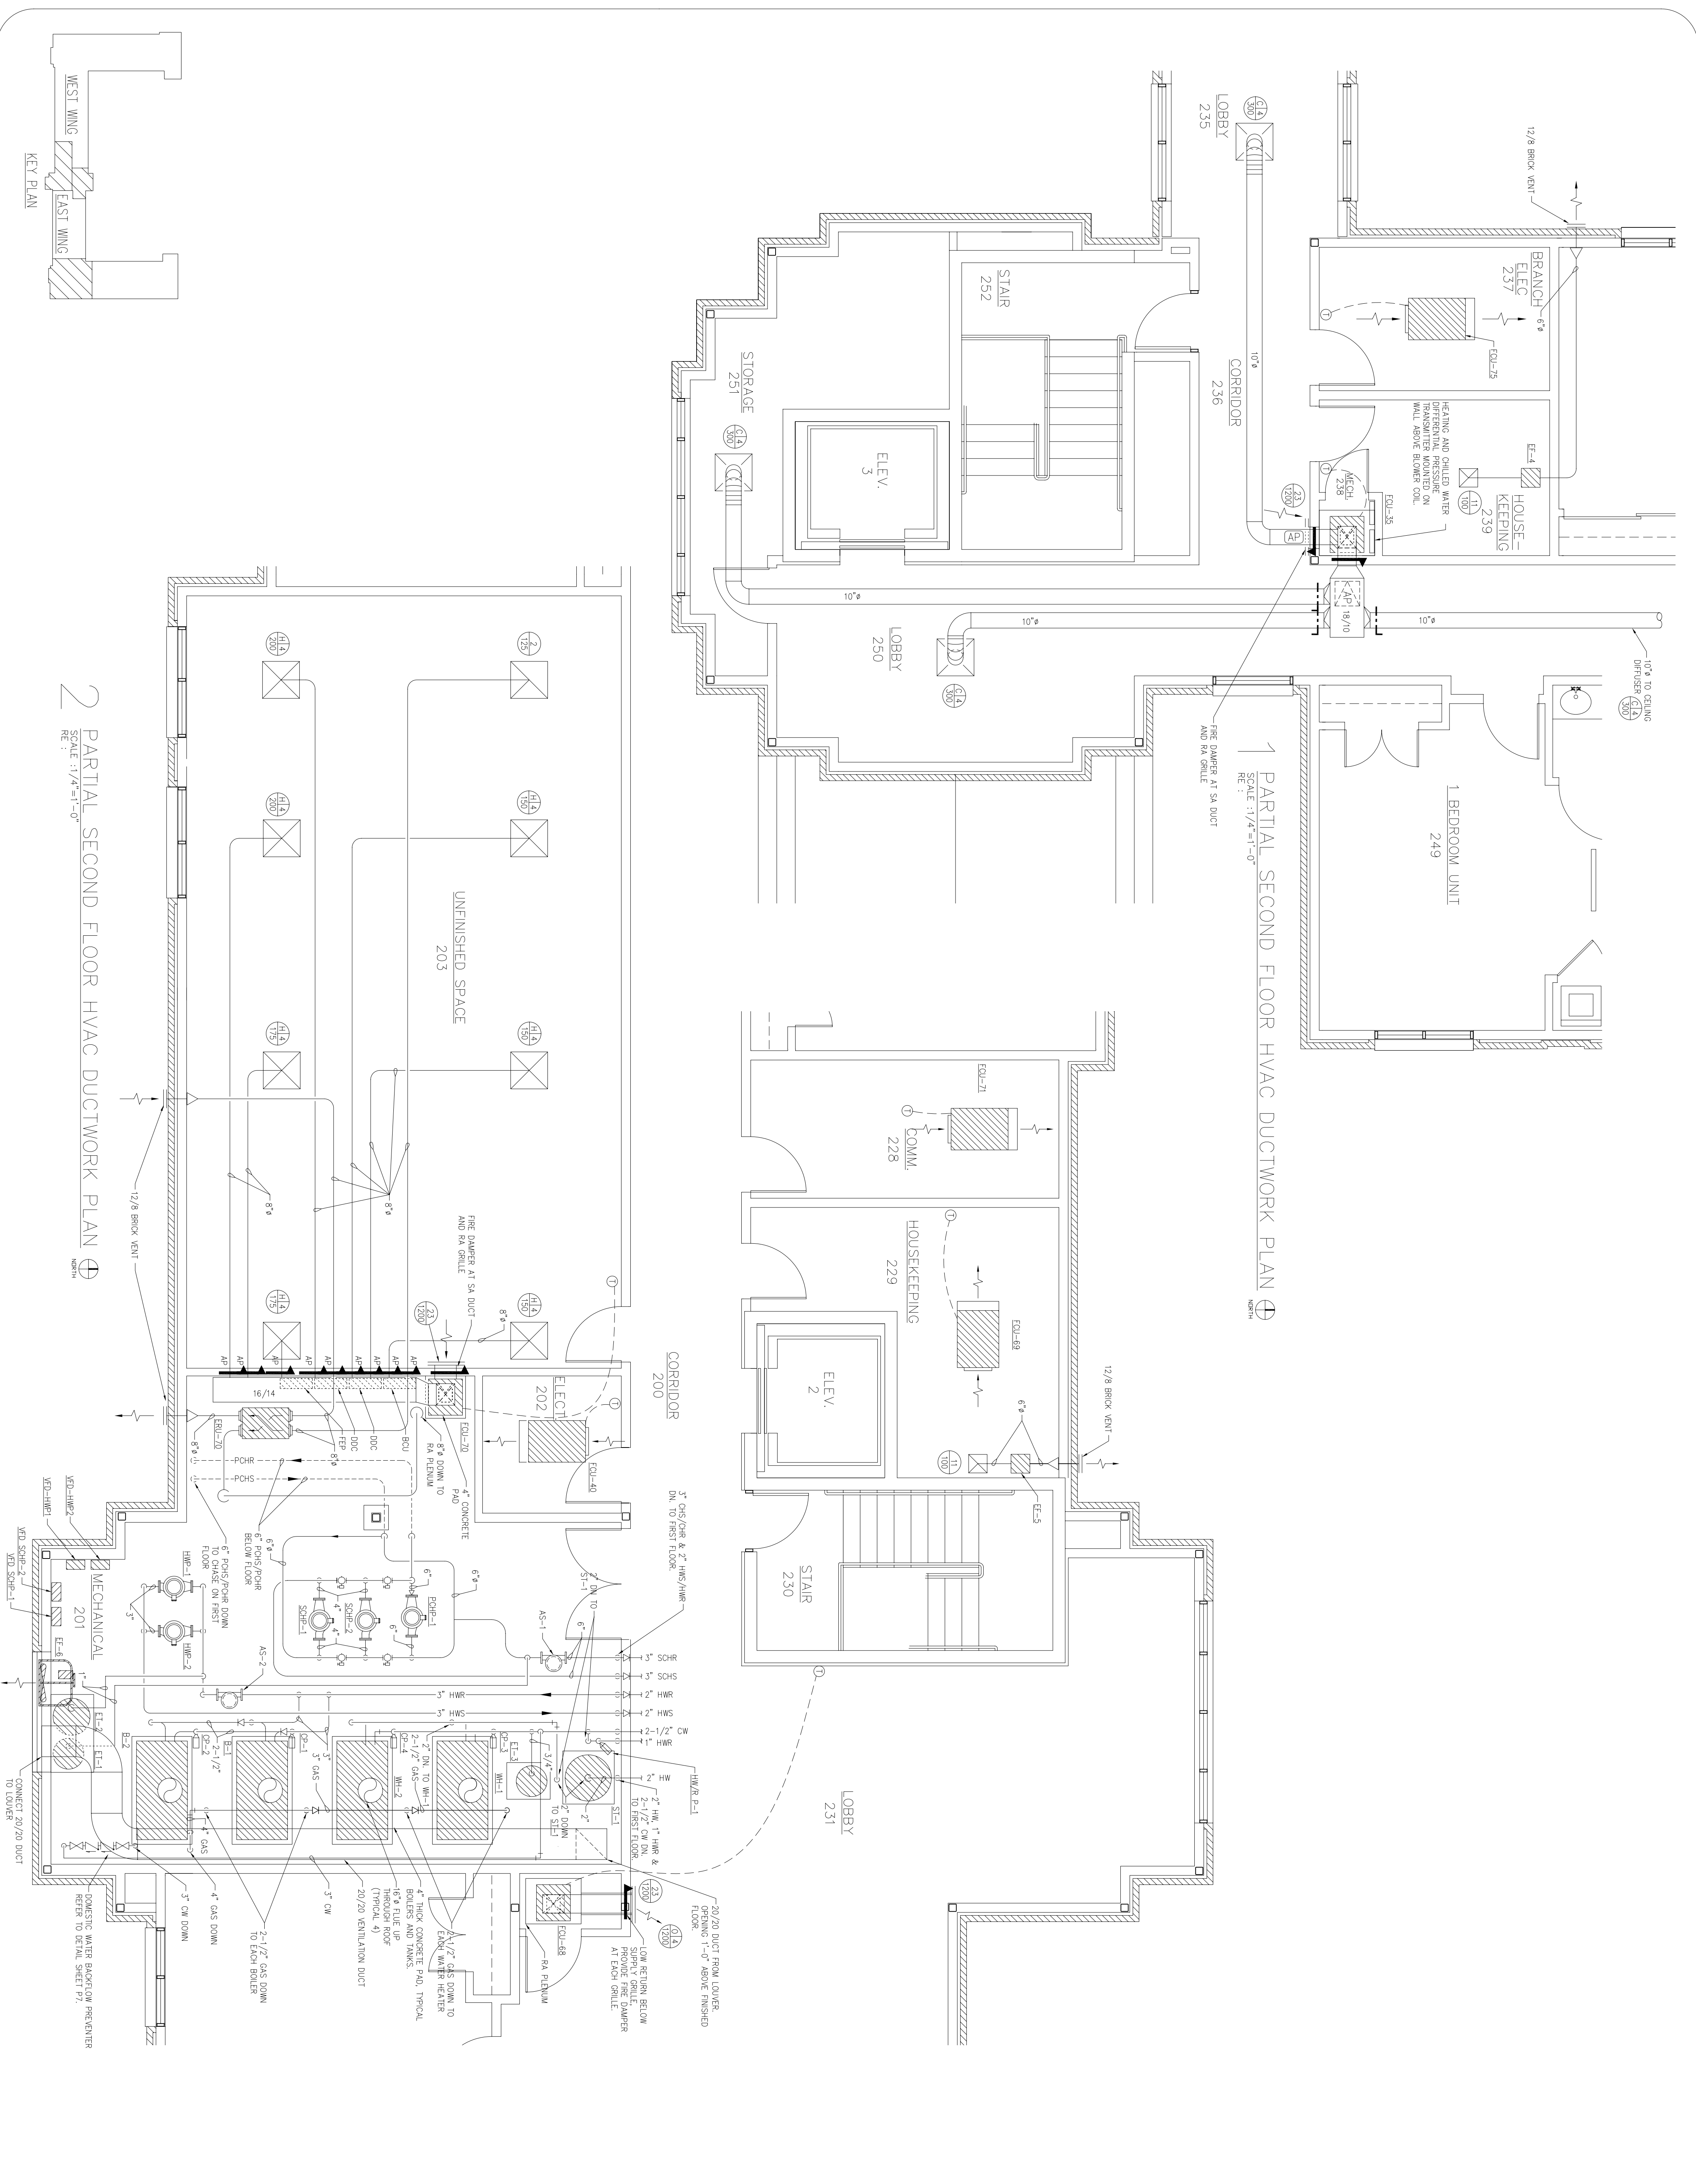

1 PARTIAL SECOND FLOOR HVAC DUCTWORK PLAN
SCALE: 1/4"=1'-0"
RE: 1

2 PARTIAL SECOND FLOOR HVAC DUCTWORK PLAN
SCALE: 1/4"=1'-0"
RE: 1