

LITTLE ROCK A.F.B.  
ARKANSAS


OWE ENGINEER	CHIEF ENGINEER
CHIEF OF OPERATIONS	BIO ENVIRONMENTAL ENG.
FIRE CHIEF	SAFETY
PROGRAM MANAGER	USING AGENCY

APP'D	BY	Date	Revision/Issue	No.
			No Changes from Design to As-Built	1


PROJECT TITLE  
TEMPORARY LODGING  
FACILITY

SHEET TITLE  
HVAC DETAILS  
AS-BUILT


DRAWN BY VWJ	LEAD DESIGNER WET
TECH REVIEWER	FILE LOCATION
DESIGNED BY TNS	PROJECT NUMBER NKA402-5001
DATE 28 MAY 2002	SHEET M12
SCALE NONE	79 of 108

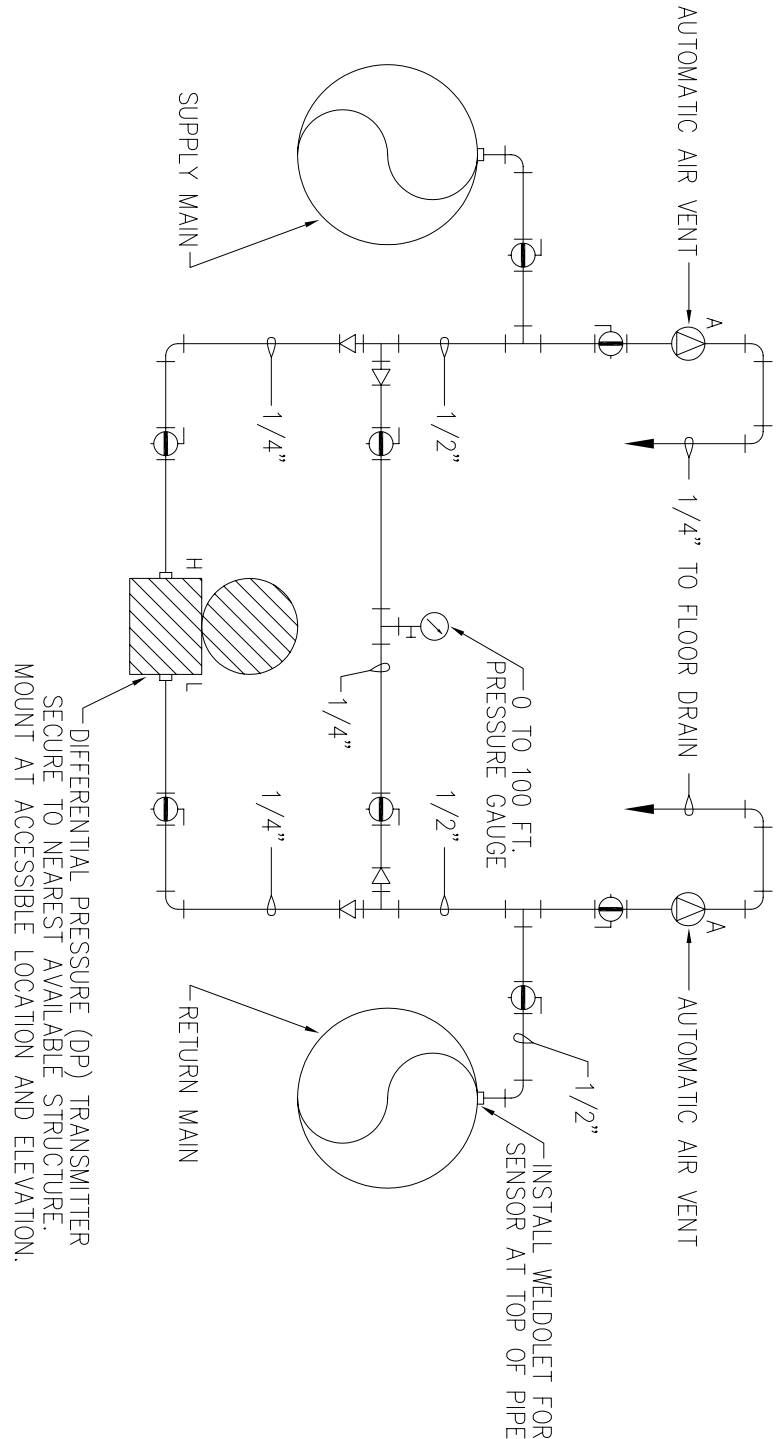


② DIFFERENTIAL PRESSURE TRANSMITTER DETAIL  
NOT TO SCALE

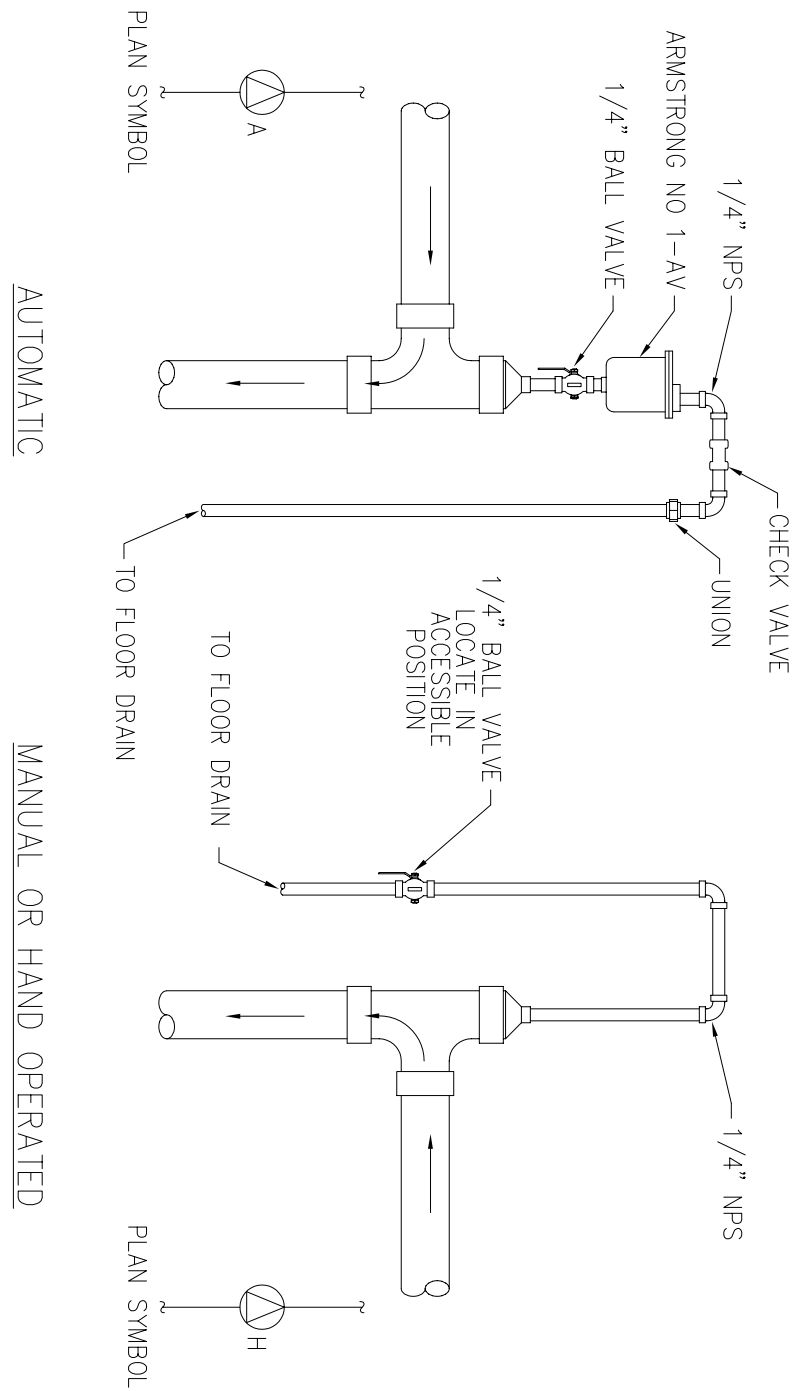


③ AIR ELIMINATOR DETAIL  
NOT TO SCALE

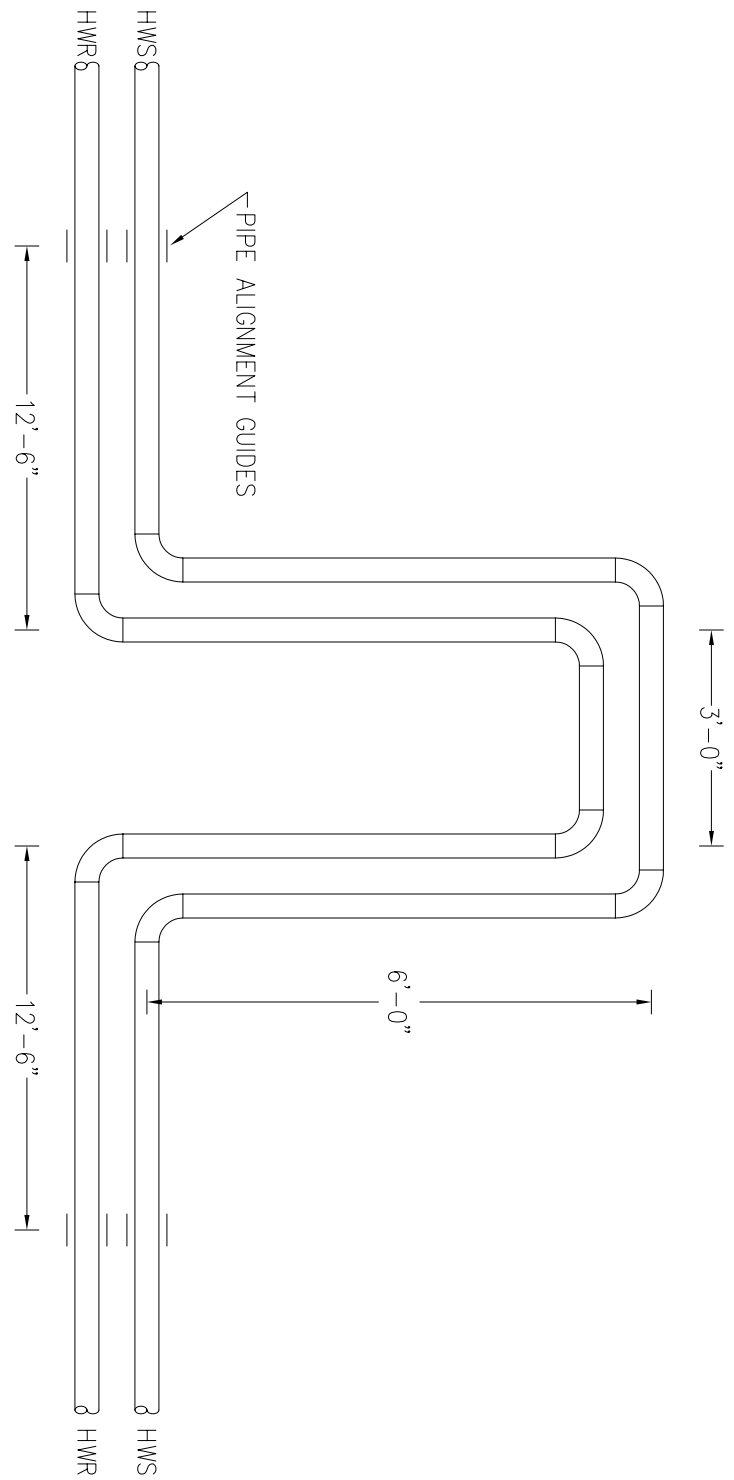

⑥ PIPING EXPANSION LOOP DETAIL  
NOT TO SCALE

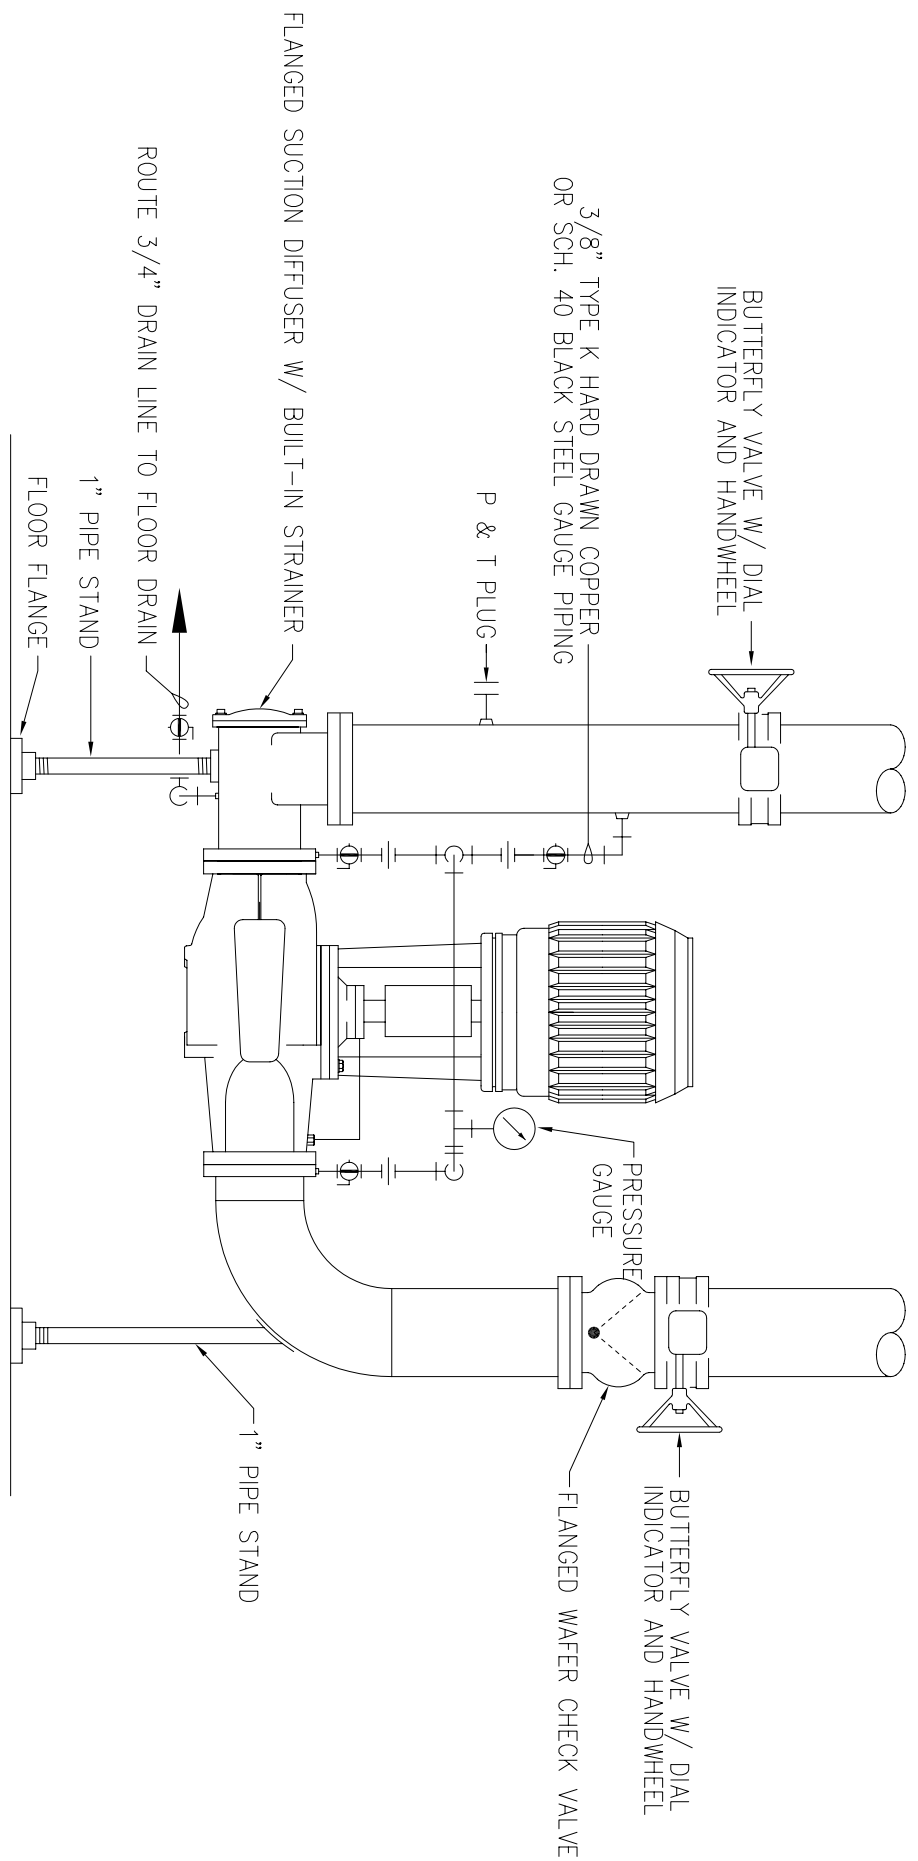

① VERTICAL INLINE PUMP PIPING DETAIL  
NOT TO SCALE

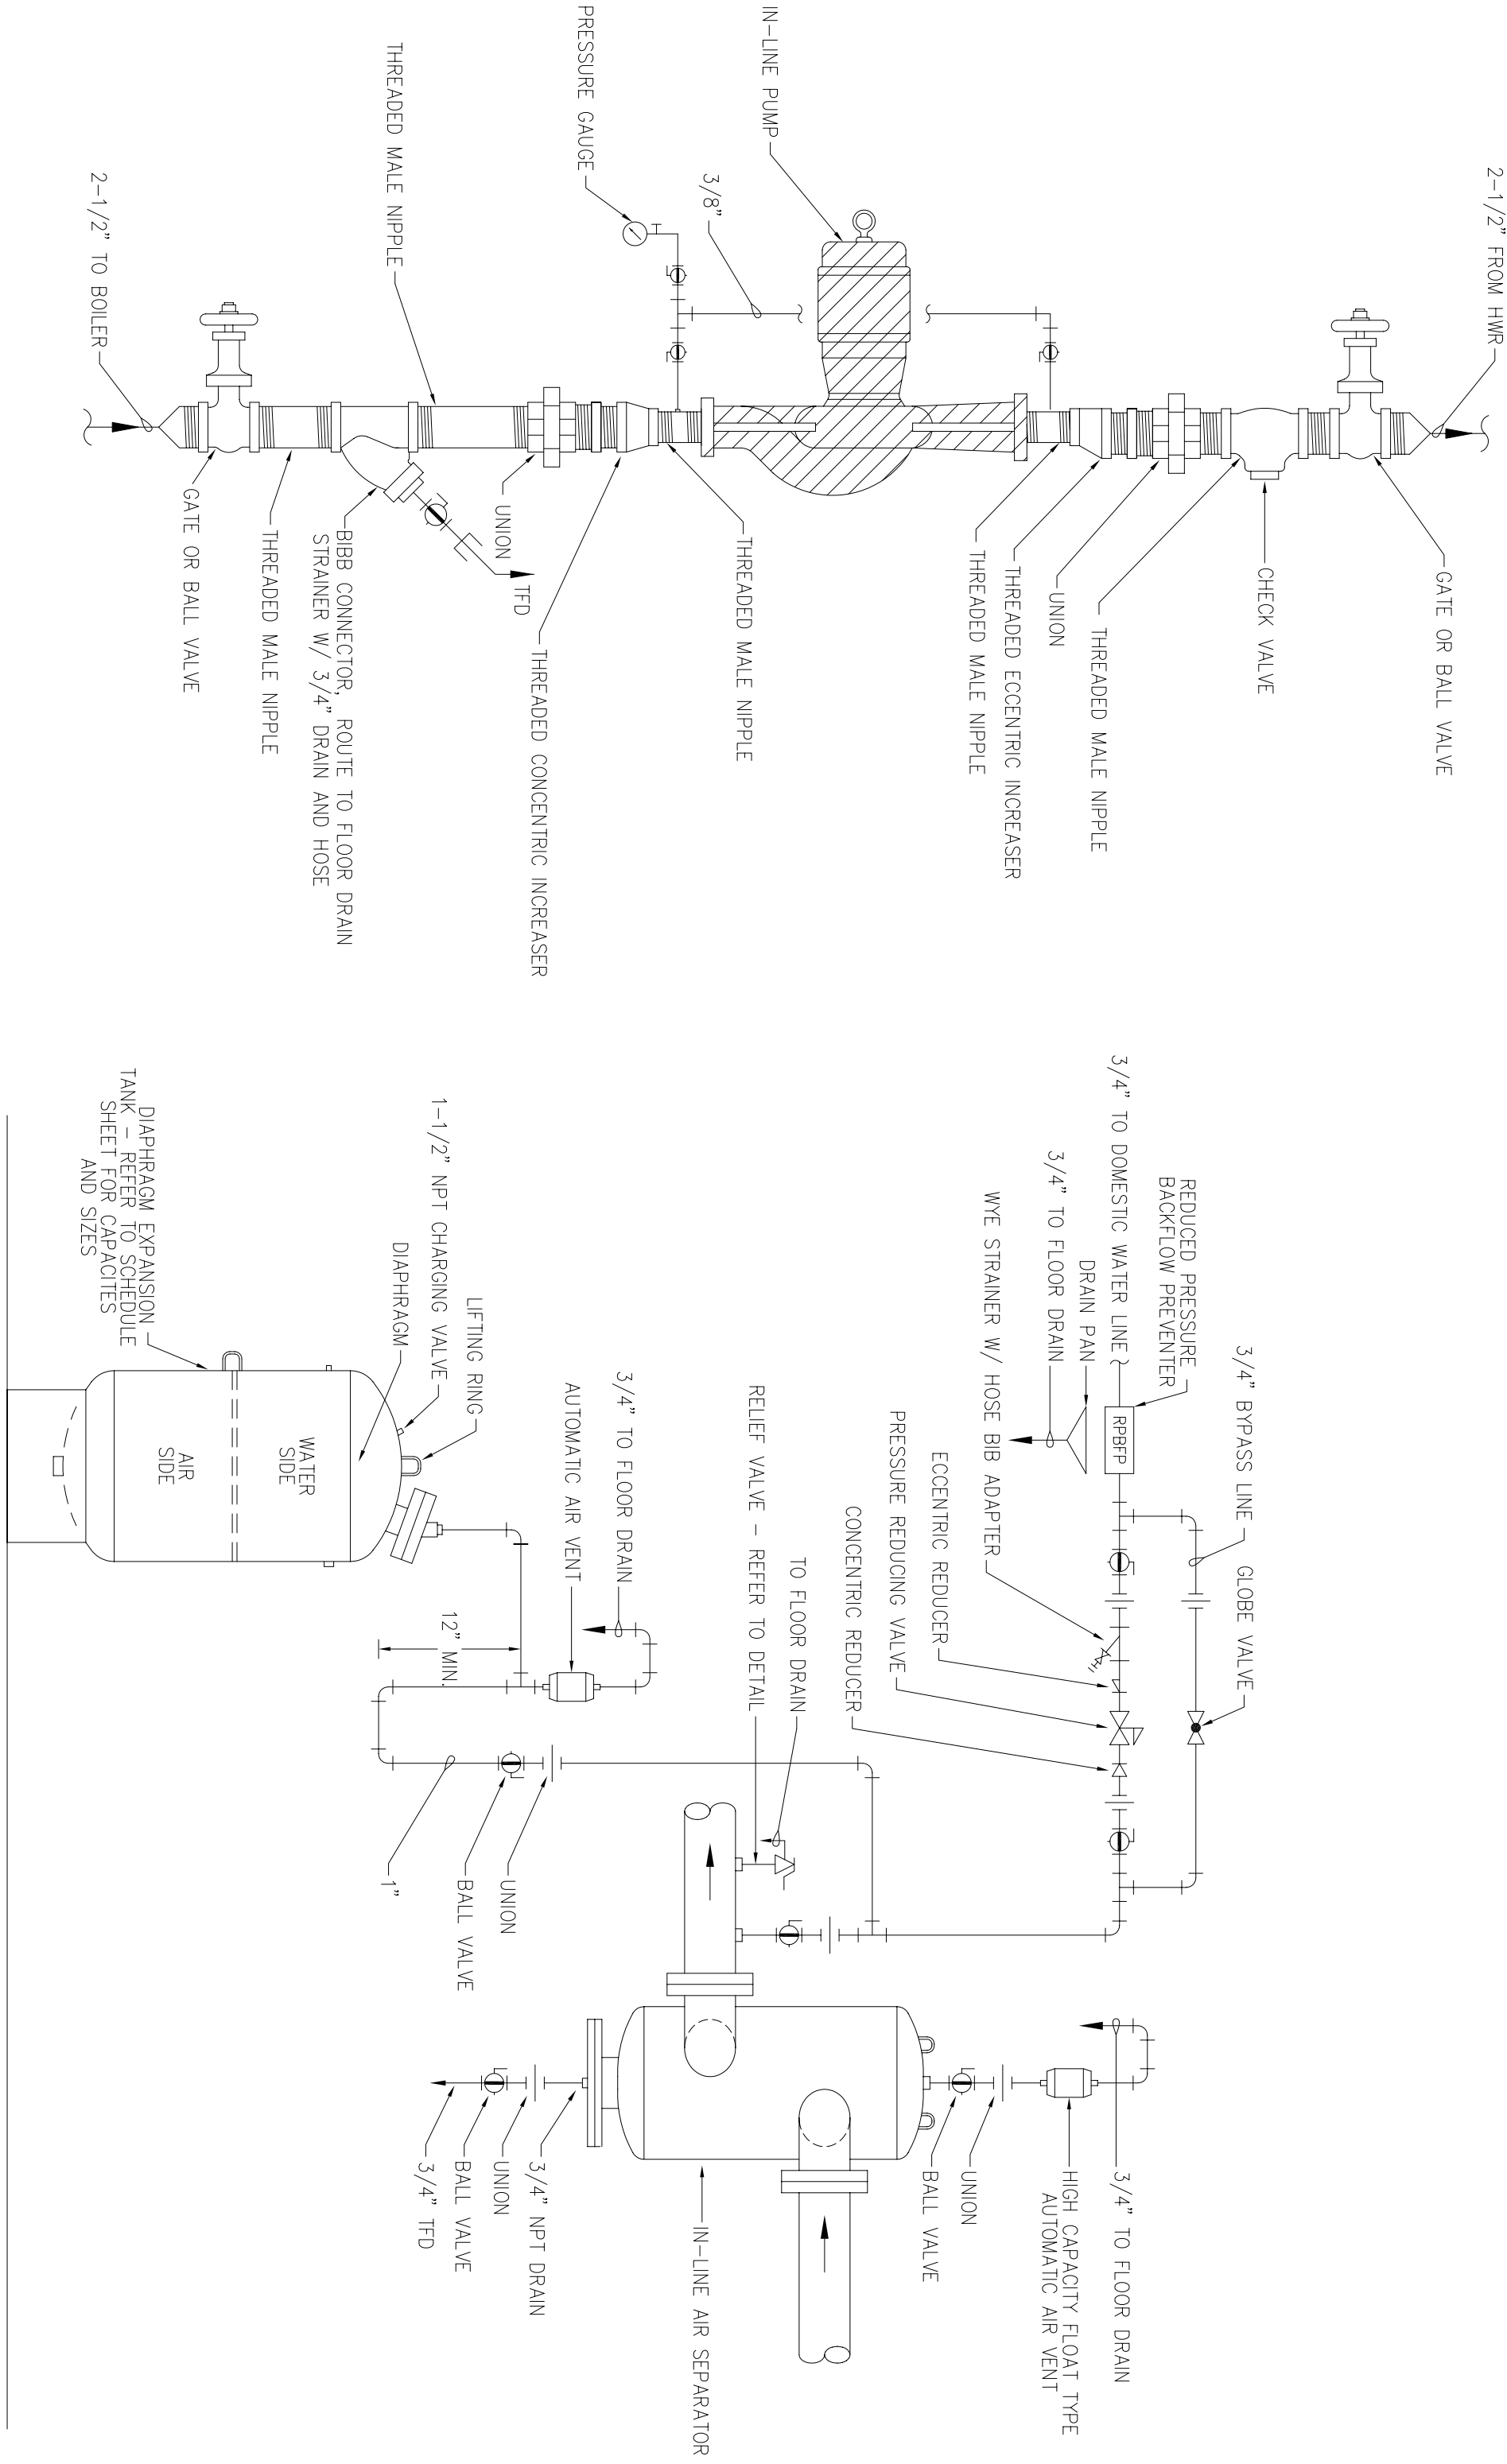

④ BOILER PUMP PIPING DETAIL  
NOT TO SCALE

⑤ AIR CONTROL PIPING DETAIL  
NOT TO SCALE