

LITTLE ROCK A.F.B.  
ARKANSAS


|                     |                        |
|---------------------|------------------------|
| CHIEF ENGINEER      | CHIEF ENGINEER         |
| CHIEF OF OPERATIONS | BIO ENVIRONMENTAL ENG. |
| FIRE CHIEF          | SAFETY                 |
| PROGRAM MANAGER     | USING AGENCY           |

| No. | Revision/Issue                     | Date | BY | APP'D |
|-----|------------------------------------|------|----|-------|
| 1   | No Changes from Design to As-Built |      |    |       |


PROJECT TITLE  
**TEMPORARY LODGING FACILITY**

SHEET TITLE  
**HVAC CONTROL DIAGRAMS AS-BUILT**

|                     |                               |
|---------------------|-------------------------------|
| DRAWN BY<br>TNS     | LEAD DESIGNER<br>WET          |
| TCN REVIEWER        | FILE LOCATION                 |
| DESIGNED BY<br>TNS  | PROJECT NUMBER<br>NKAAD2-5001 |
| DATE<br>28 MAY 2002 | SHEET<br>M16                  |
| SCALE<br>NONE       | 83 OF 108                     |

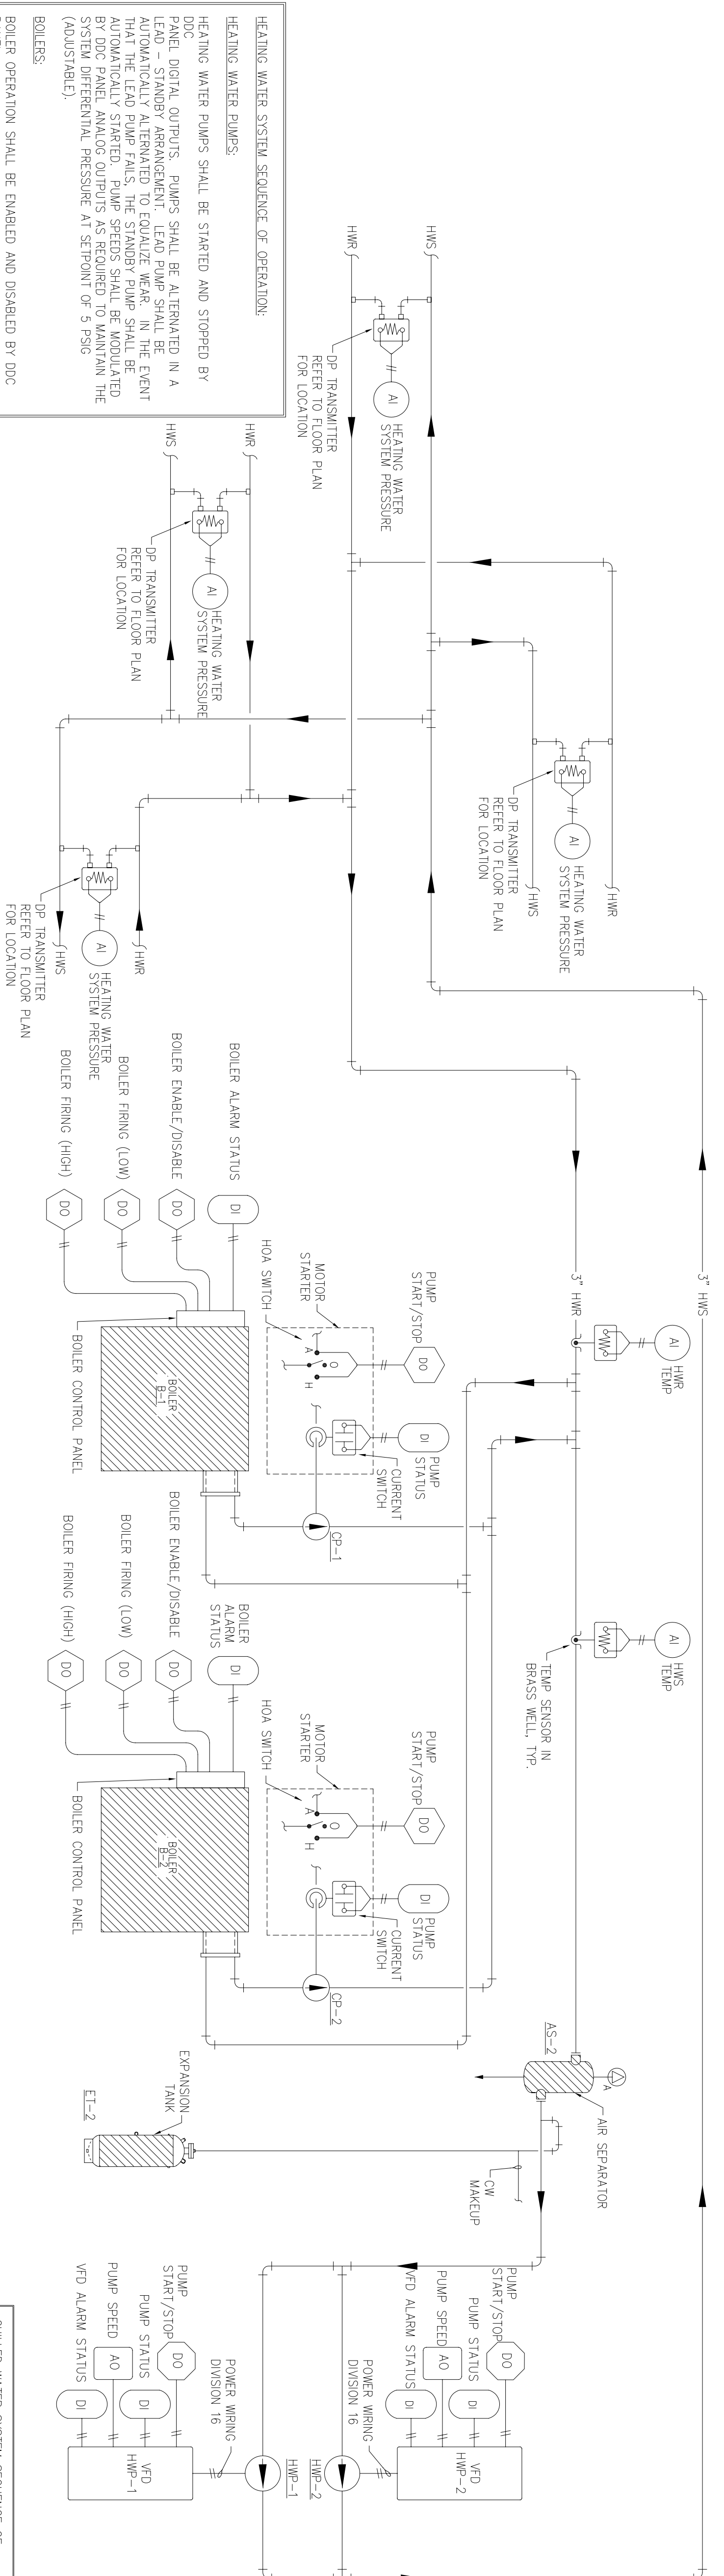

1 HEATING WATER SYSTEM CONTROL DIAGRAM  
NOT TO SCALE

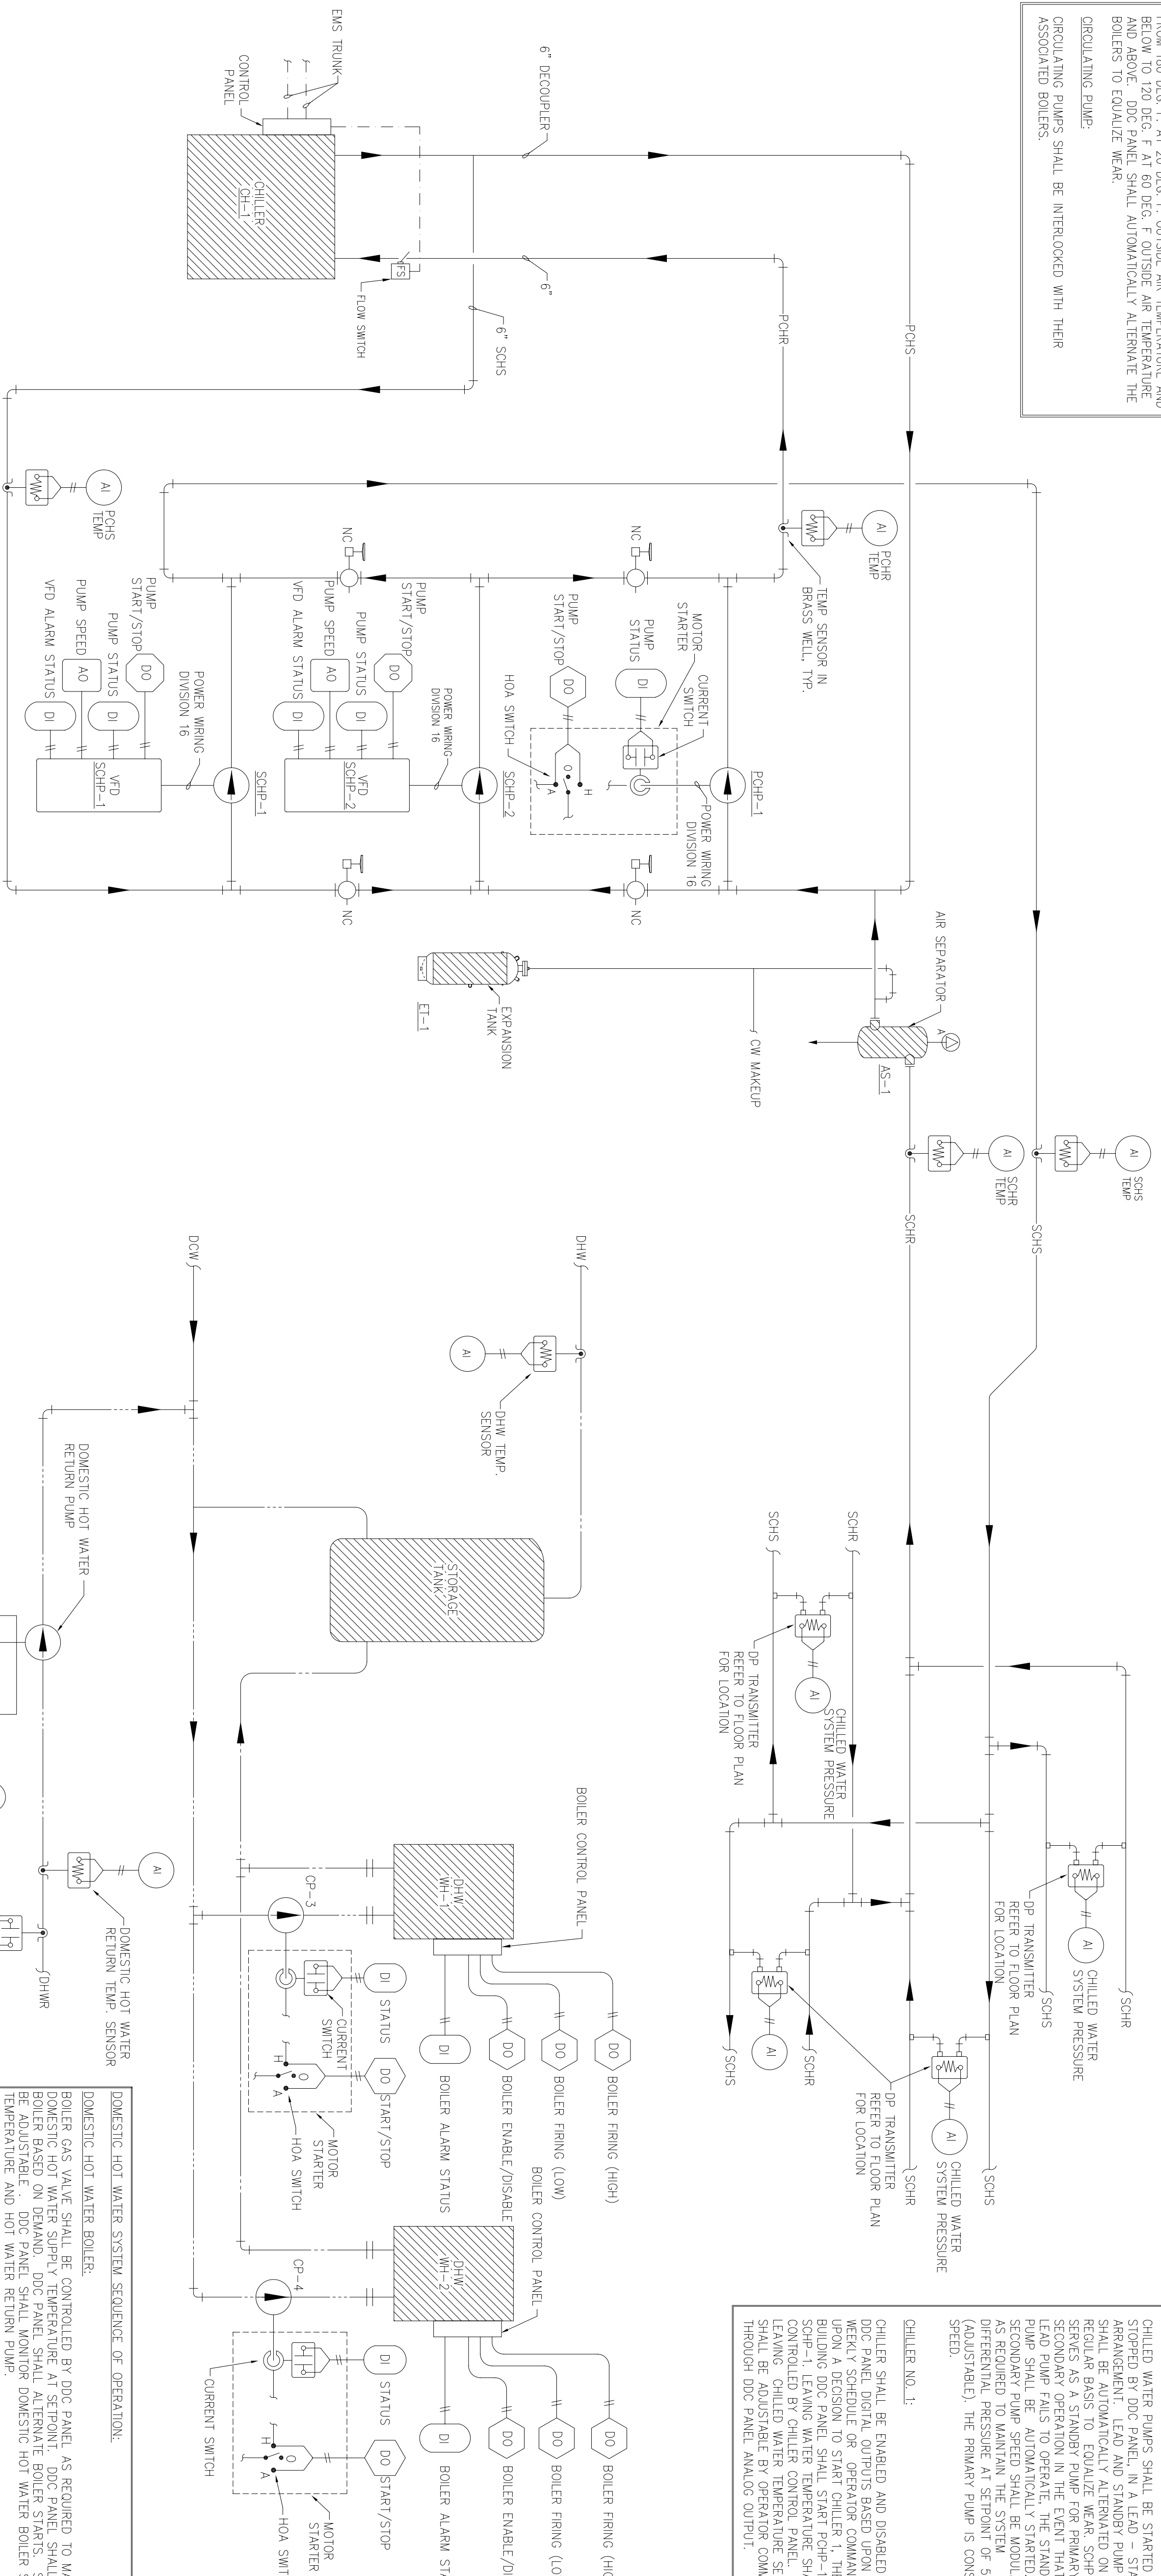

2 CHILLED WATER SYSTEM CONTROL DIAGRAM  
NOT TO SCALE

3 DOMESTIC HOT WATER SYSTEM CONTROL DIAGRAM  
NOT TO SCALE

