

LITTLE ROCK A.F.B.  
ARKANSAS


CON. ENGINEER	CHIEF ENGINEER
CHIEF OF OPERATIONS	BIO ENVIRONMENTAL ENG.
FIRE CHIEF	SAFETY
PROGRAM MANAGER	USING AGENCY

No.	Revision/Issue	Date	BY	APP'D
1	Added fire sprinkler test lines & flow switch test stations			

PROJECT TITLE  
TEMPORARY LODGING  
FACILITY


SHEET TITLE  
PARTIAL  
FIRST FLOOR  
PLUMBING PLAN  
AS-BUILT

DRAWN BY PNS	LEAD DESIGNER WET
TITLE REVISOR	FILE LOCATION
DESIGNED BY LSK	PROJECT NUMBER NKA402-5001
DATE 28 MAY 2002	SHEET P2
SCALE AS NOTED	87 of 108

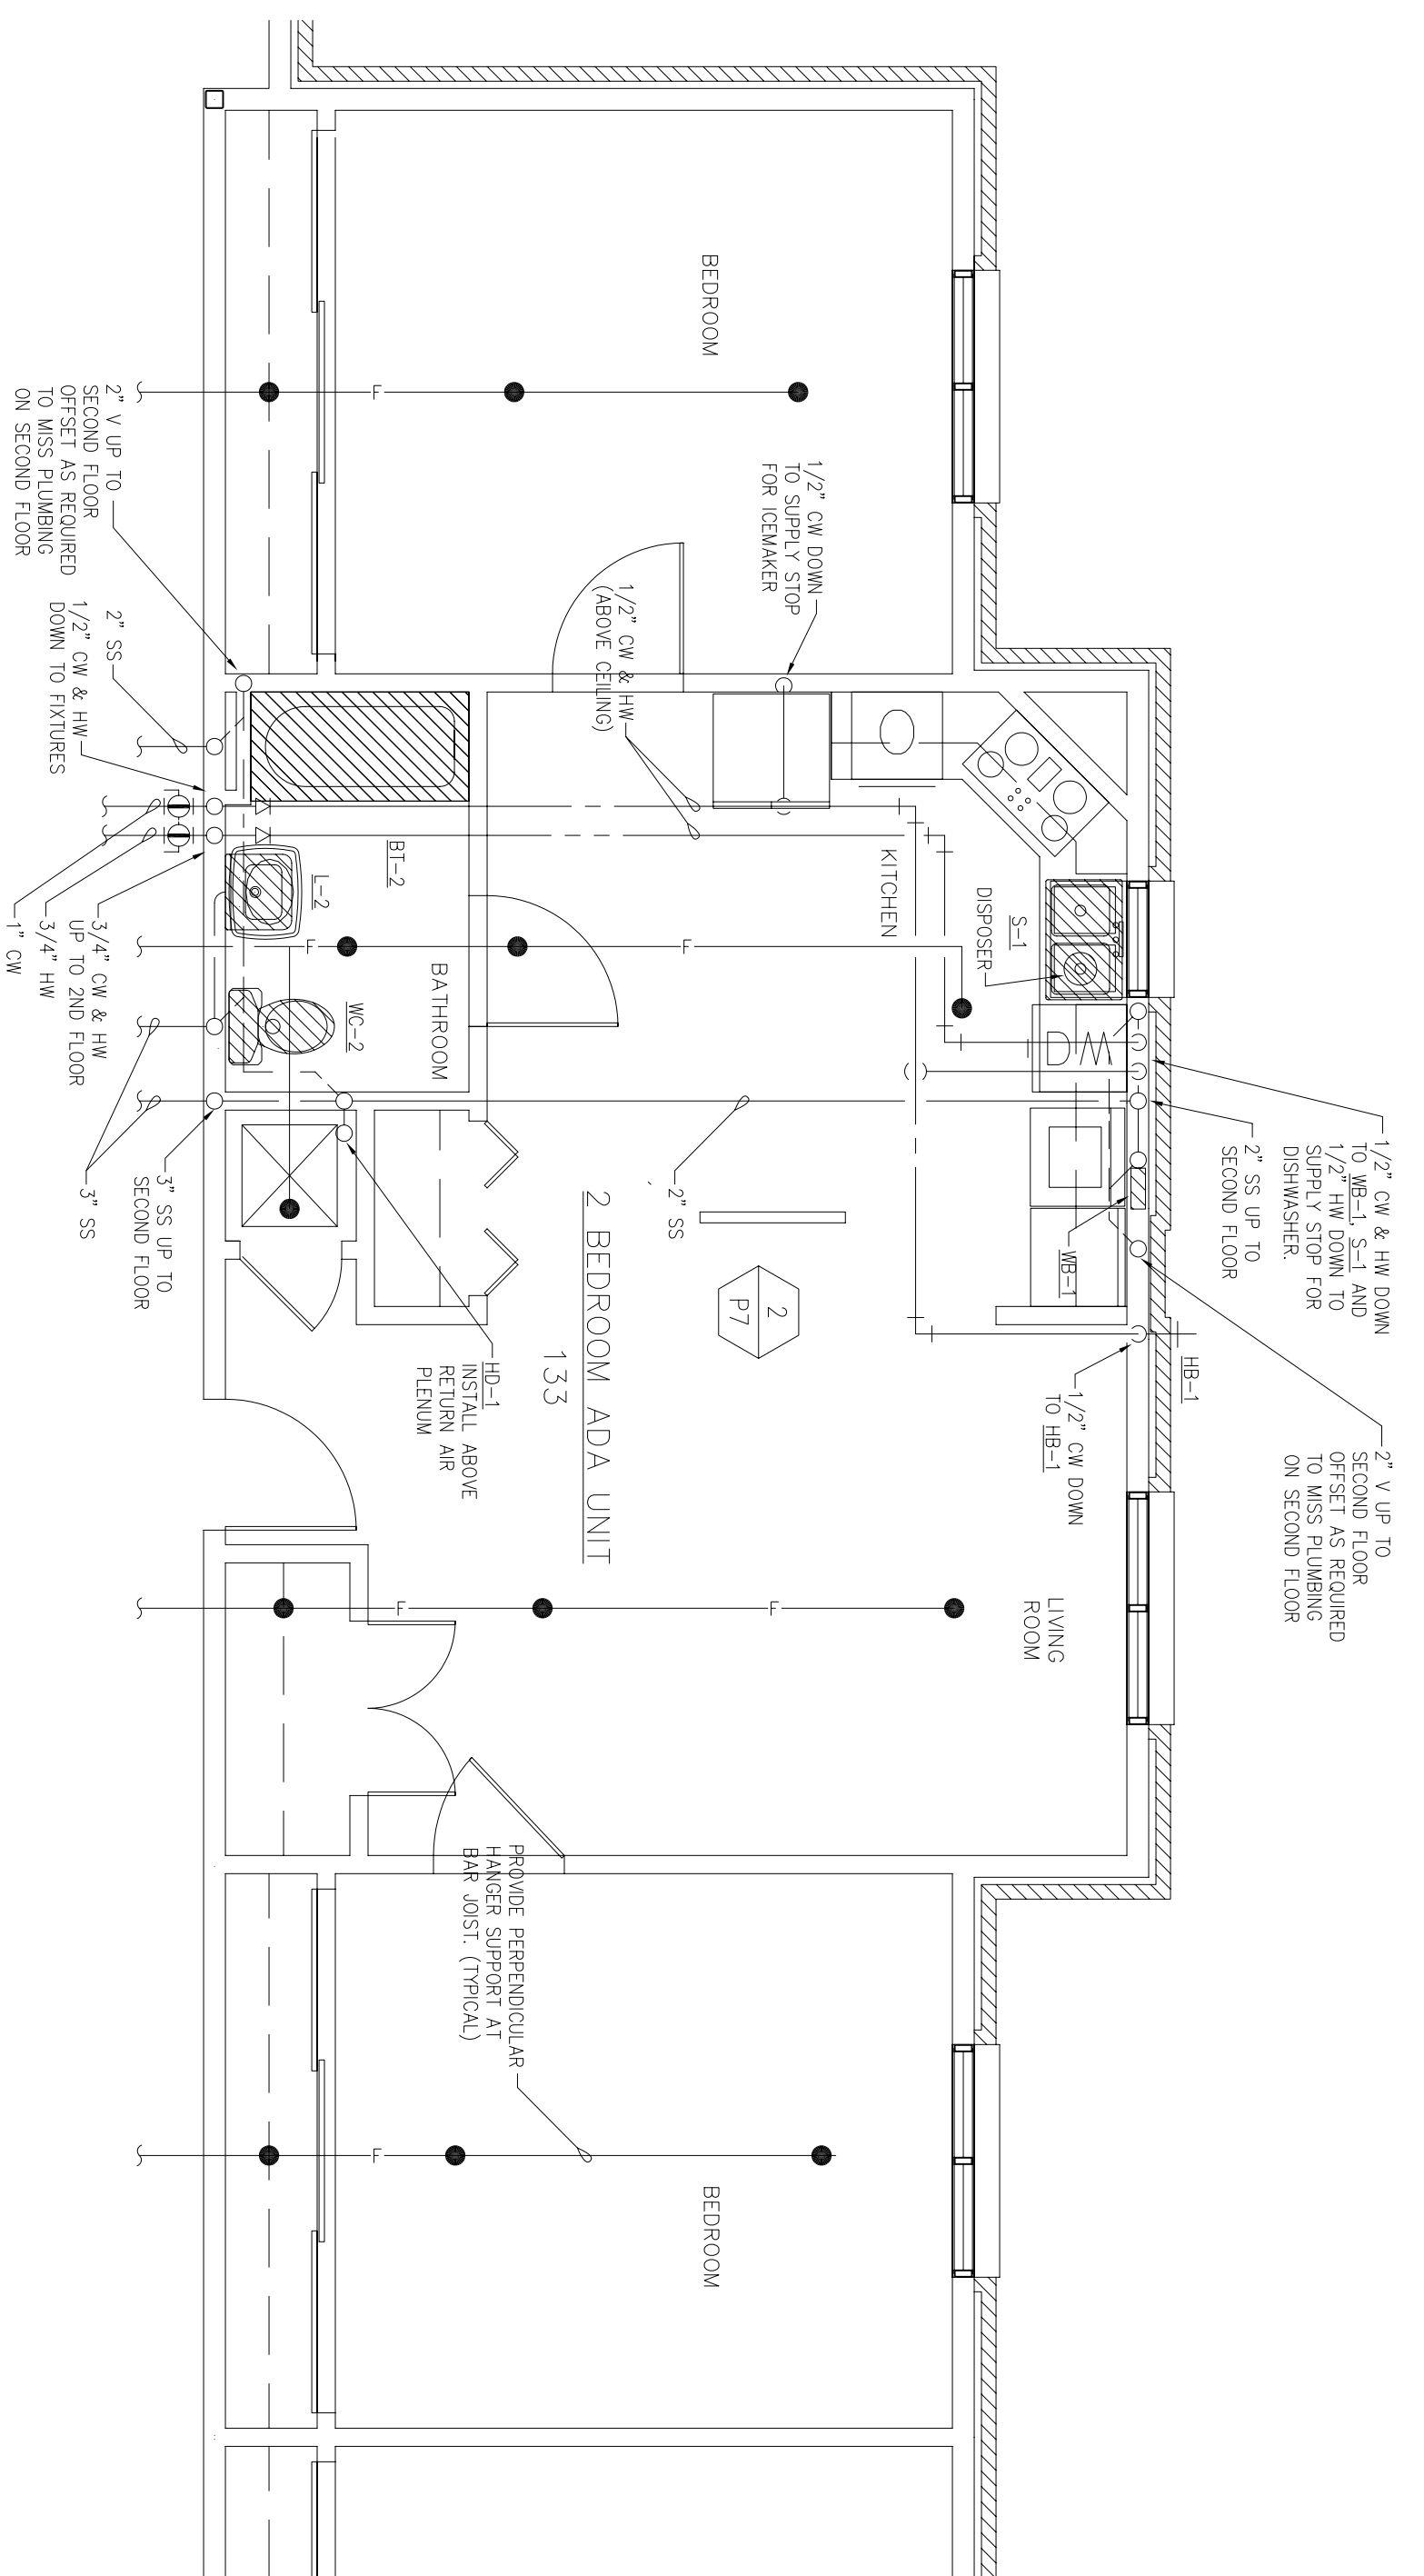

2 ENLARGED PLAN AT ADA UNIT - PLUMBING  
SCALE: 1/4"=1'-0"

- LEGEND
- PRISANT TYPE SPRINKLER HEAD
  - UPRIGHT TYPE SPRINKLER HEAD
  - ▲ SIDEWALL TYPE SPRINKLER HEAD
  - FIRE LINE
  - TAMPON SWITCH
  - FLOW SWITCH

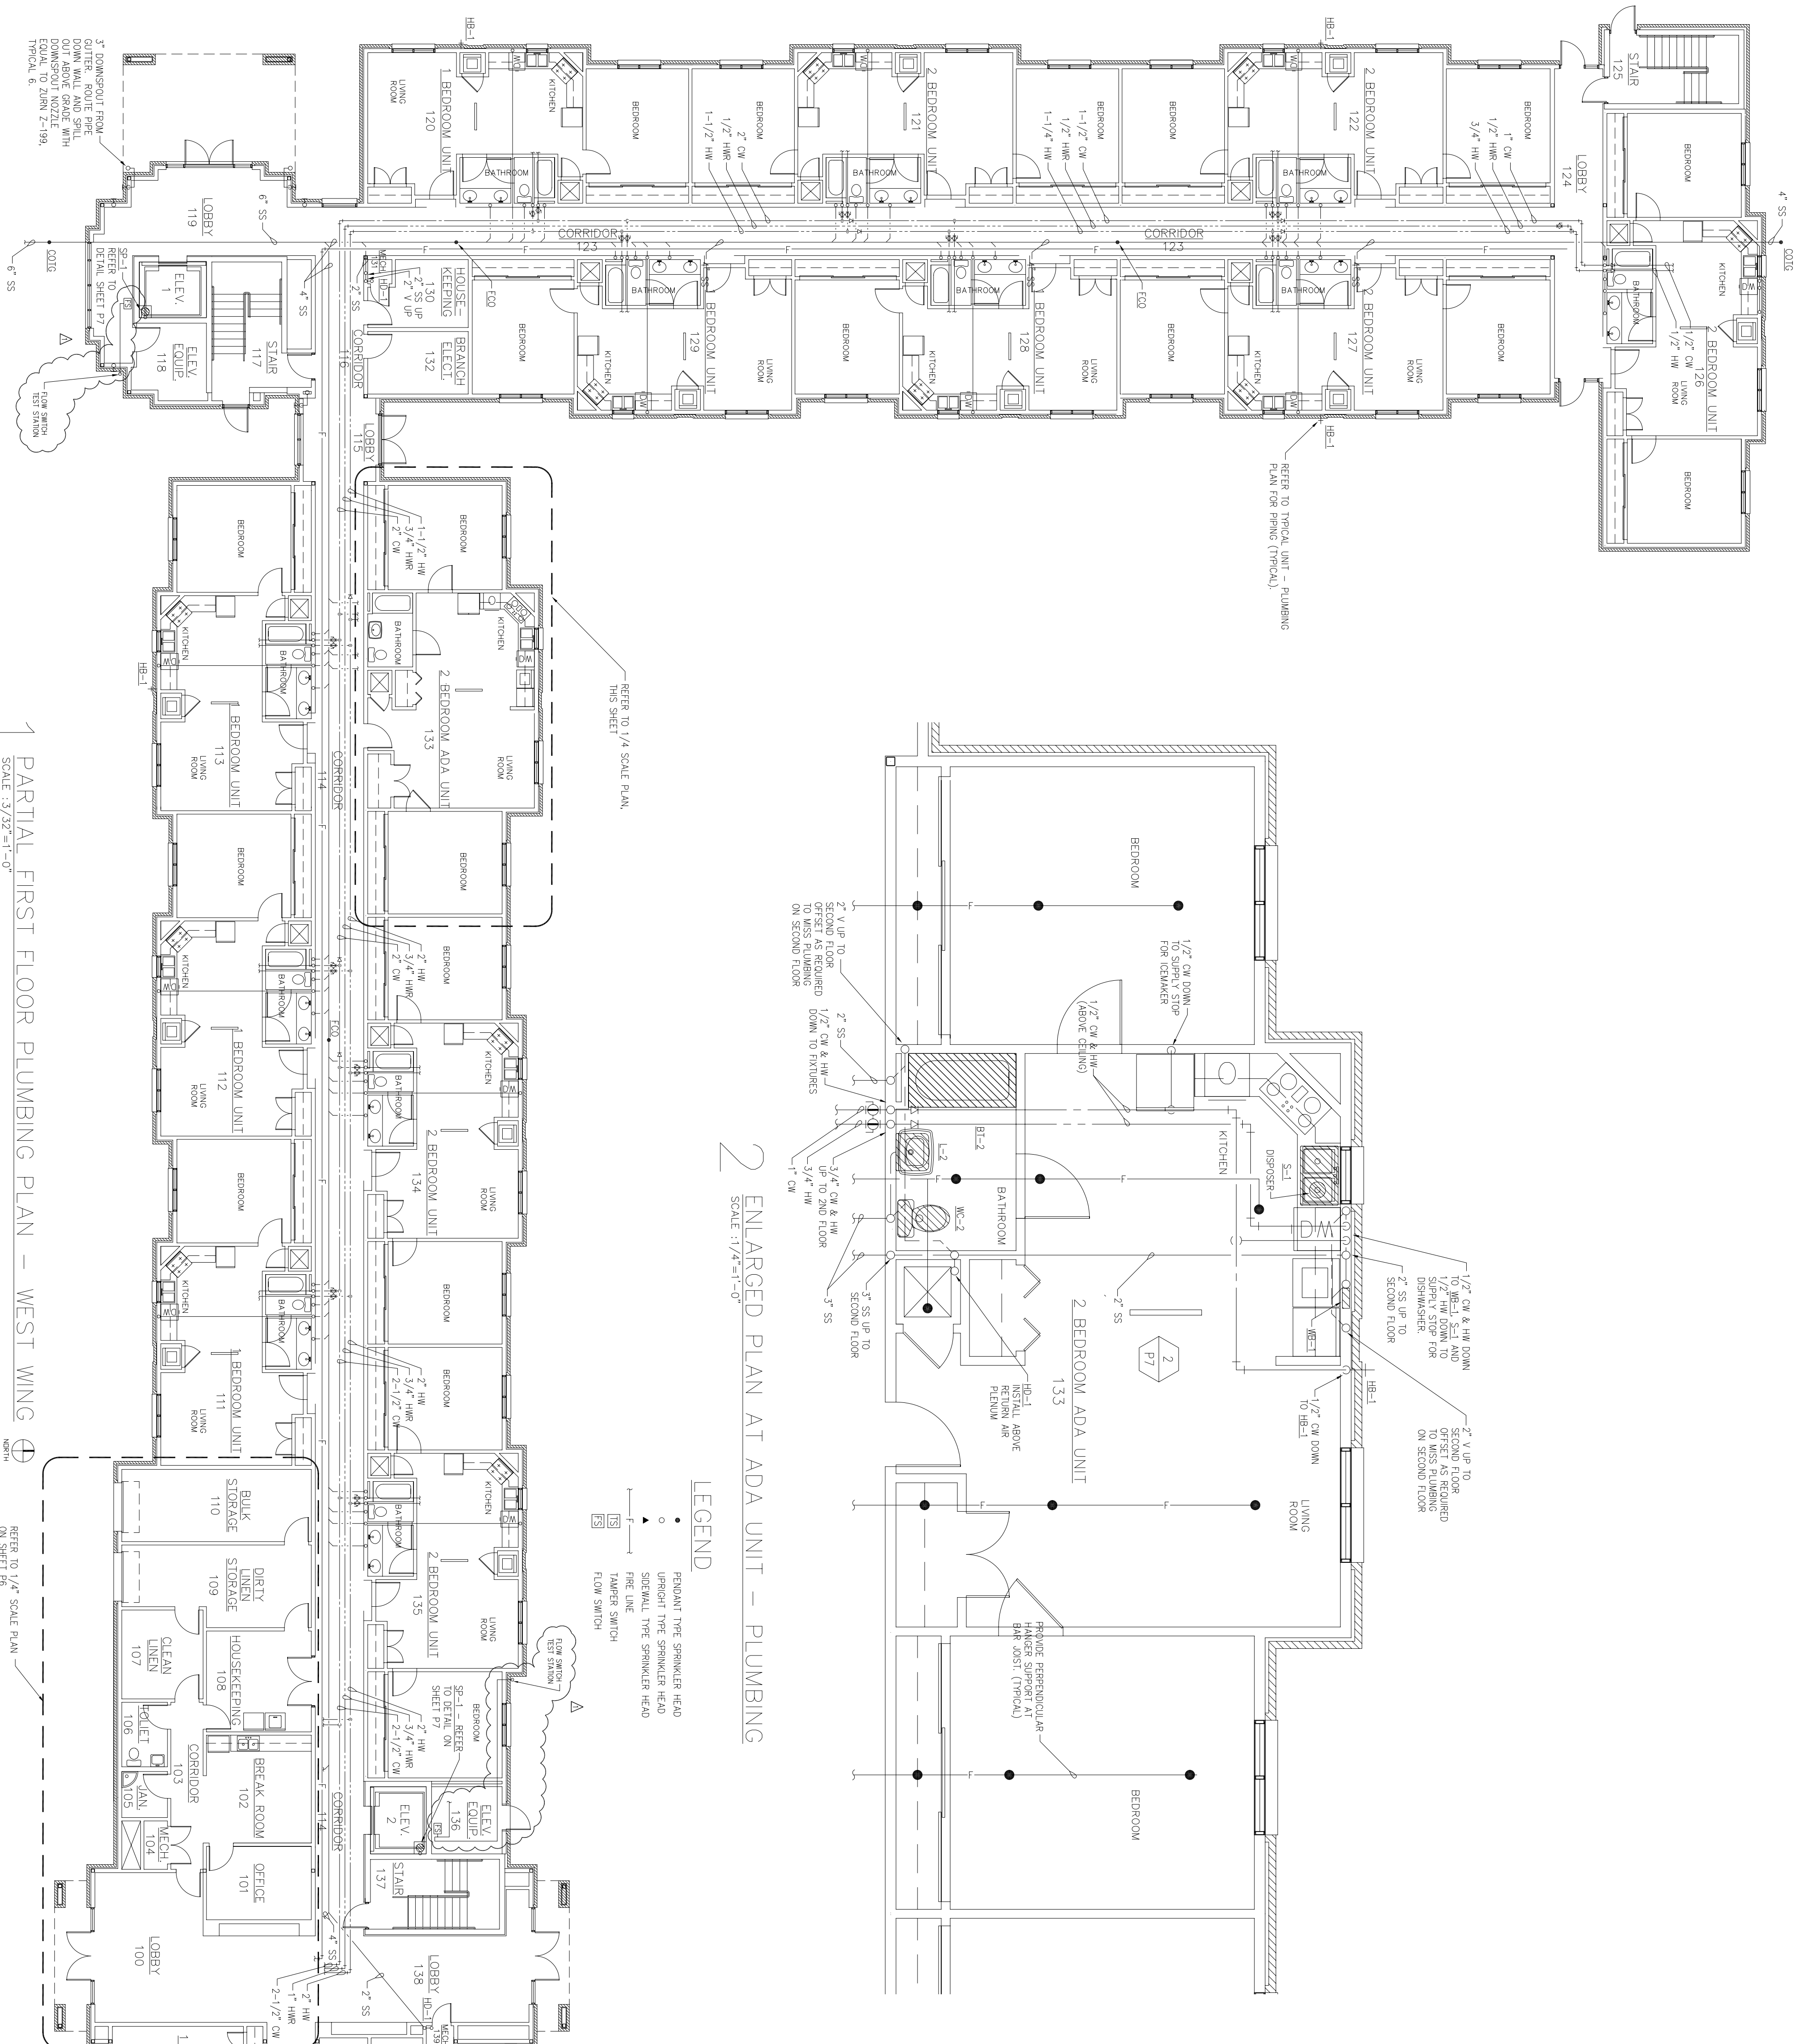

1 PARTIAL FIRST FLOOR PLUMBING PLAN - WEST WING  
SCALE: 3/32"=1'-0"

