


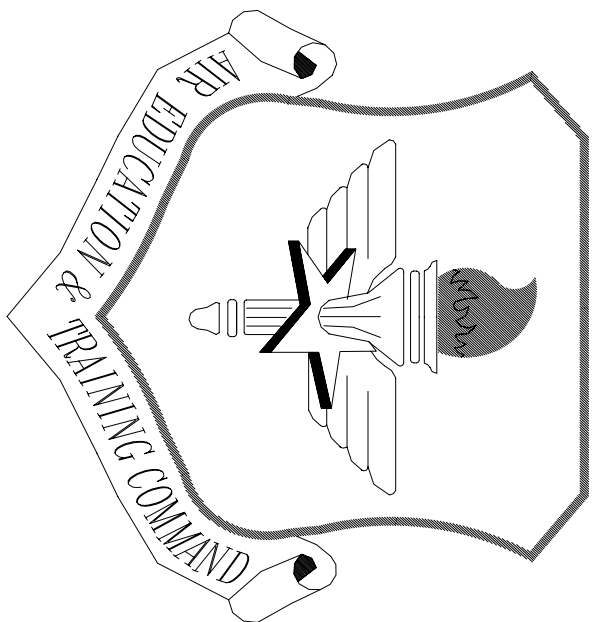

LITTLE ROCK A.F.B.
ARKANSAS


Civil Engineer	Chief Engineer
Chief of Operations	Bio Environmental Eng.
Fire Chief	Safety
Program Manager	Using Agency

No.	Revision/Issue	Date	BY	APP'D
1	Added Fire Sprinkler Test Lines locations			

PROJECT TITLE
TEMPORARY LODGING
FACILITY


SHEET TITLE
PARTIAL SECOND FLOOR
PLUMBING PLAN
AS-BUILT

DRAWN BY PNS	LEAD DESIGNER WET
TCO REVIEWER	FILE LOCATION
DESIGNED BY LSK	PROJECT NUMBER NKAKO2-5001
DATE 28 MAY 2002	SHEET P4
SCALE AS NOTED	89 OF 108

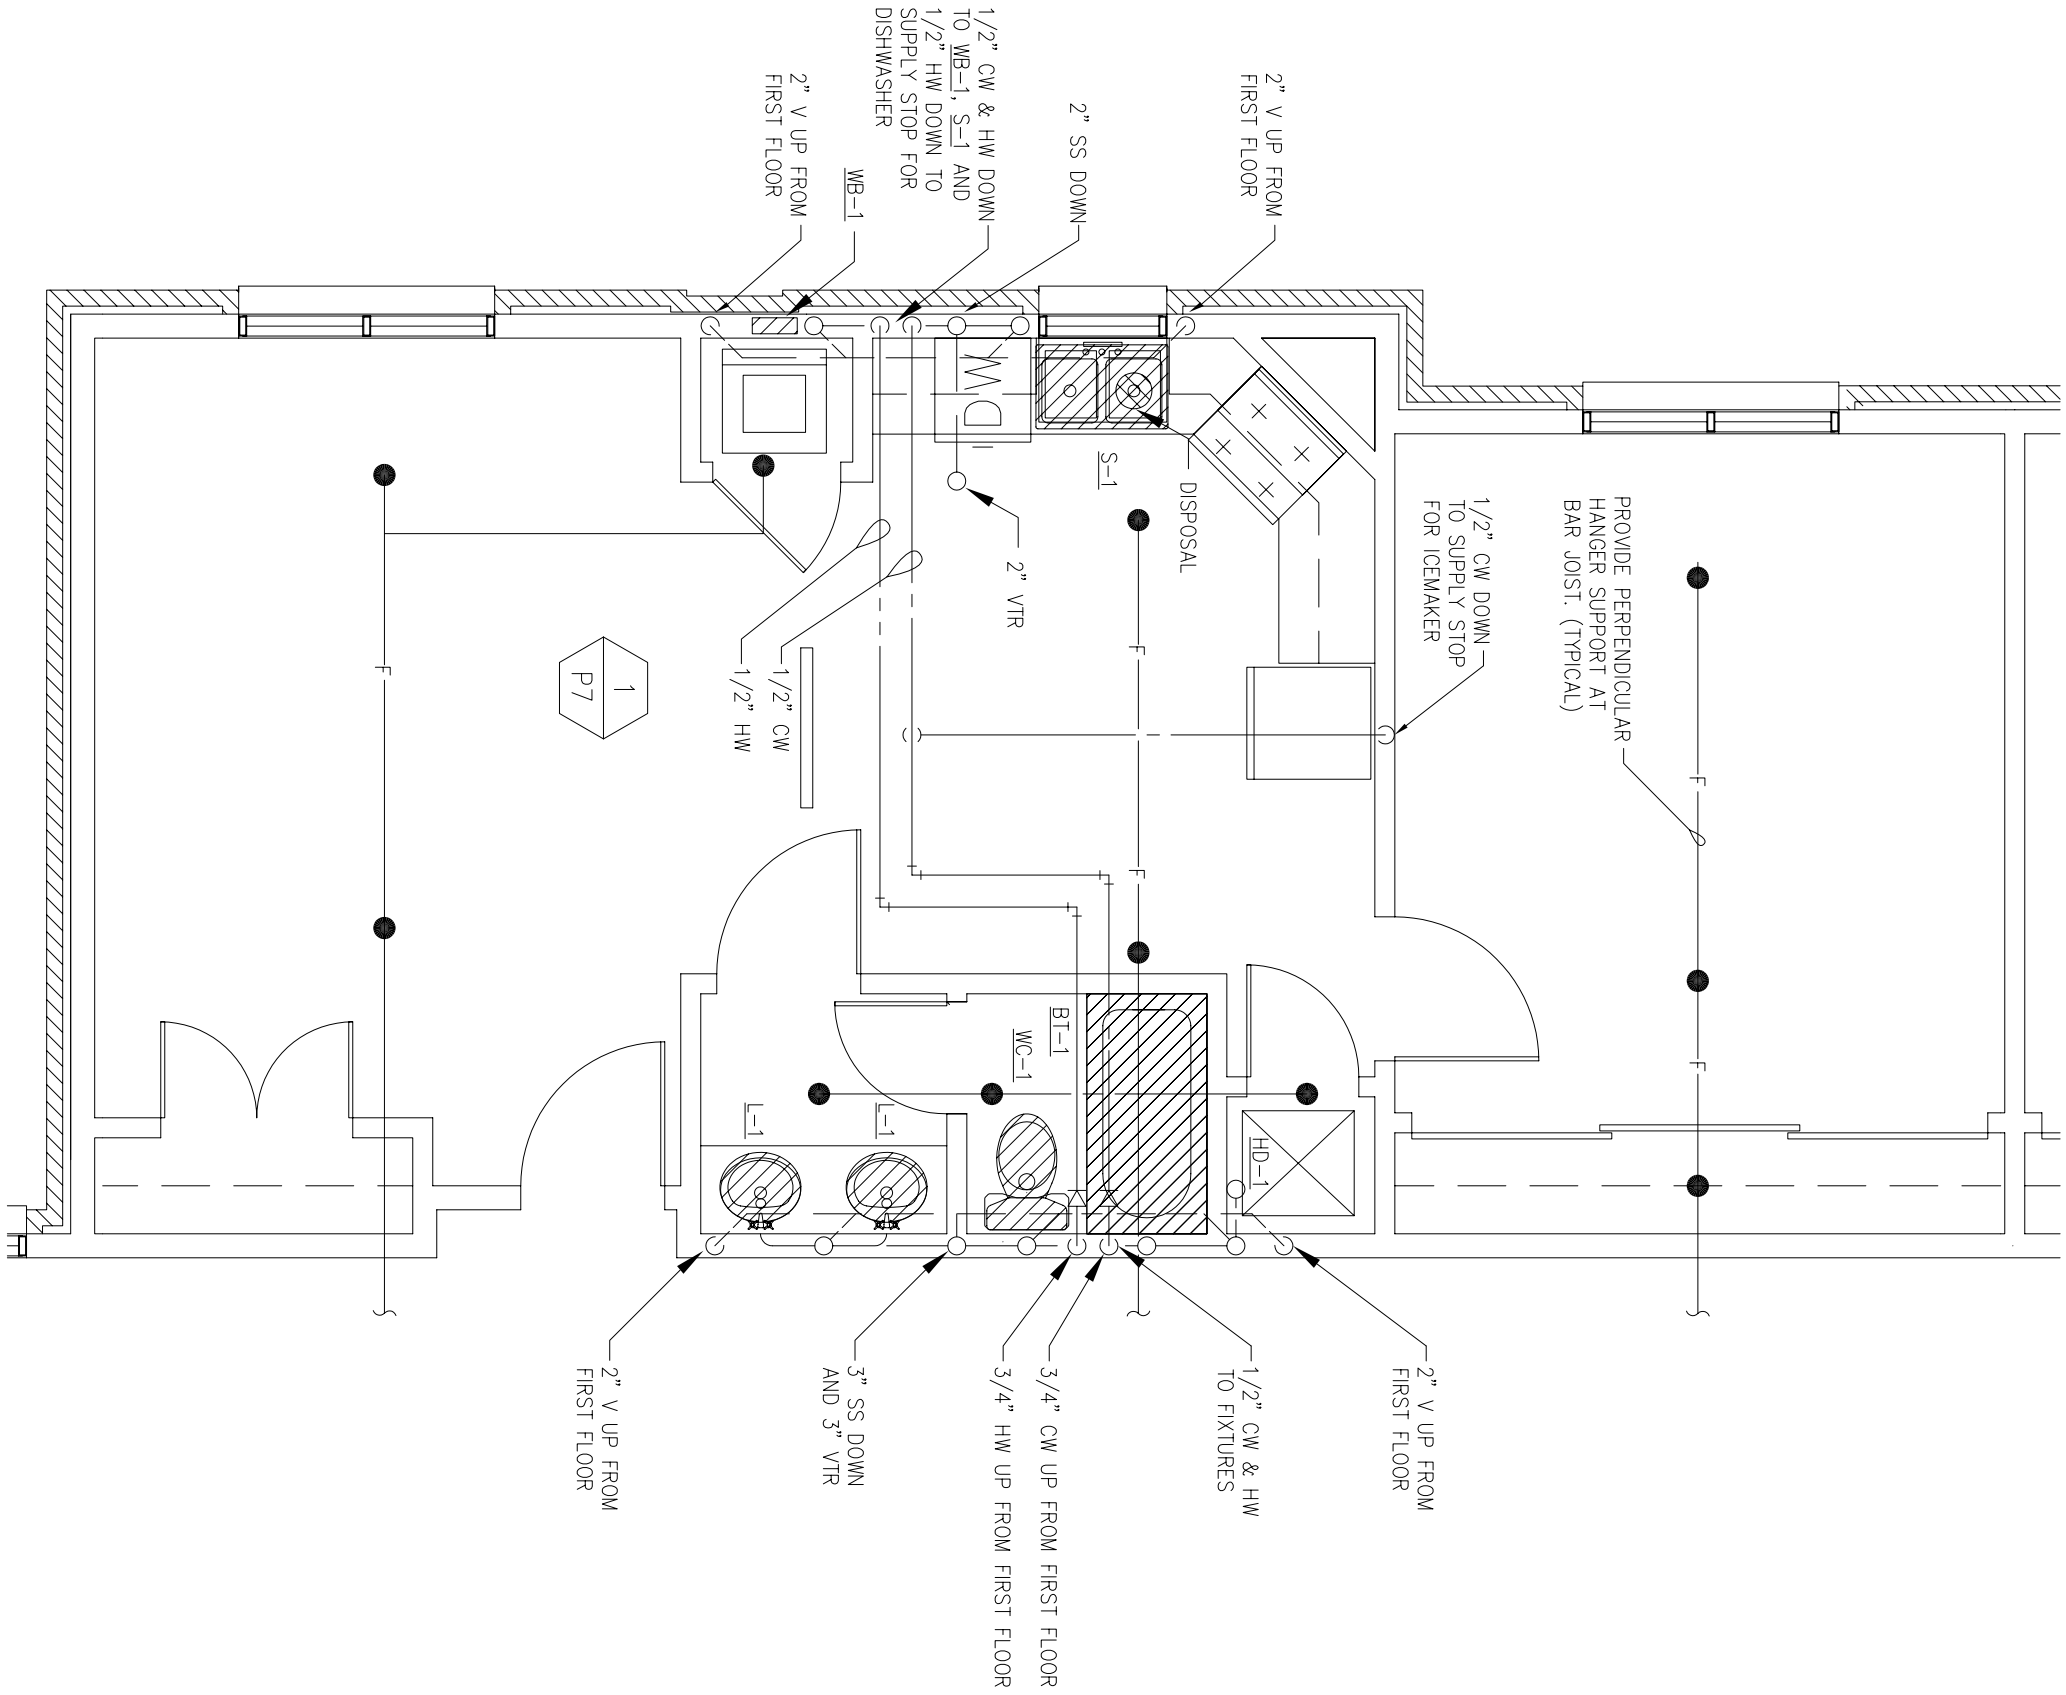

- LEGEND
- PENDANT TYPE SPRINKLER HEAD
 - UPRIGHT TYPE SPRINKLER HEAD
 - ▲ SIDEWALL TYPE SPRINKLER HEAD
 - F — FIRE LINE
 - FS — TAPPER SWITCH
 - FS — FLOW SWITCH

2 ENLARGED PLAN AT 1 BEDROOM UNIT - PLUMBING
SCALE: 1/4" = 1'-0"

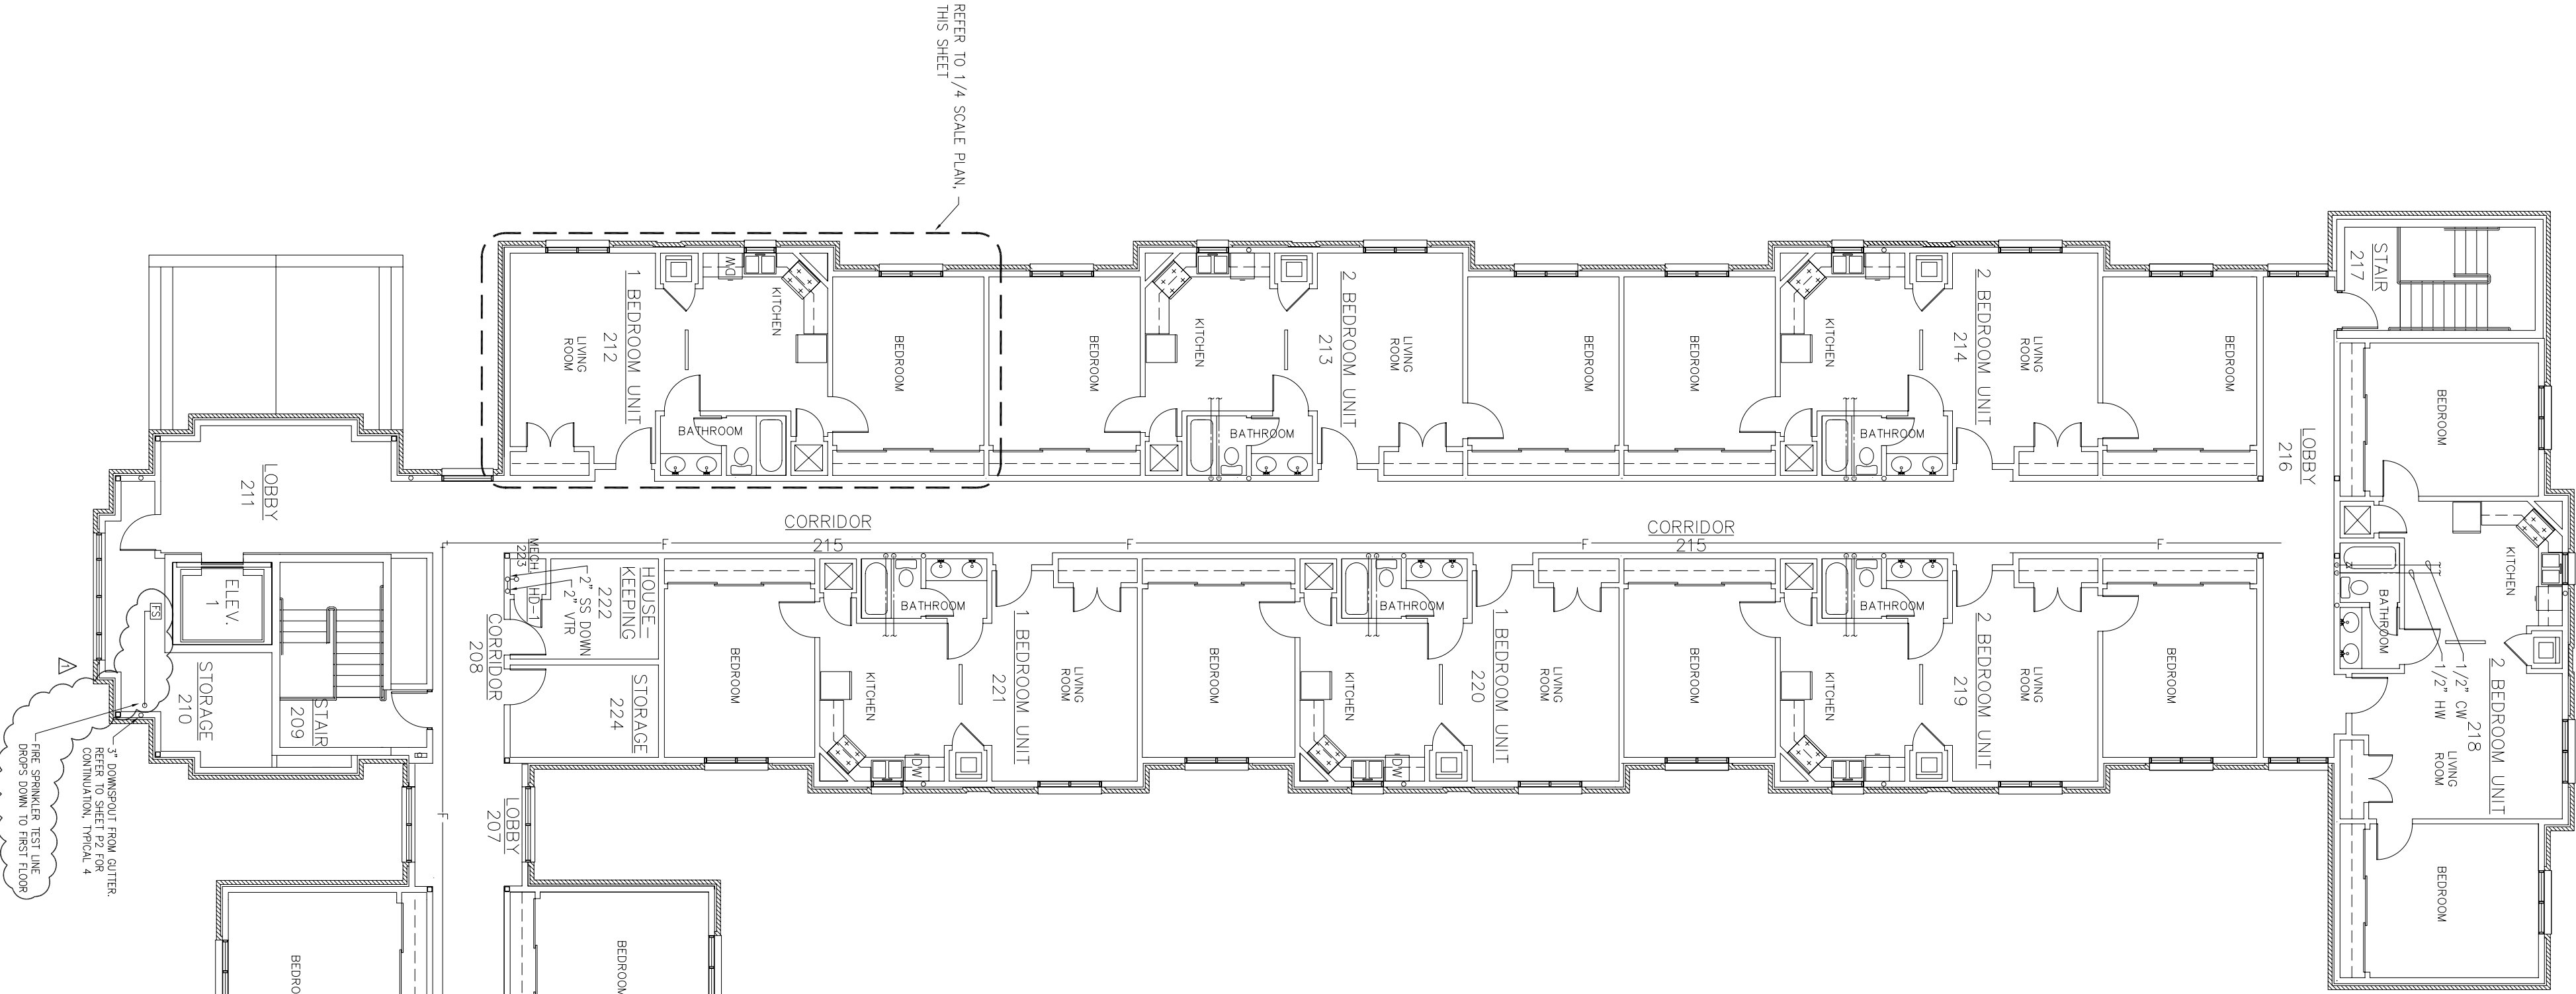

1 PARTIAL SECOND FLOOR PLUMBING PLAN - WEST WING
SCALE: 3/32" = 1'-0"

