

LITTLE ROCK A.F.B.
ARKANSAS




CIVIL ENGINEER	CHIEF ENGINEER
CHIEF OF OPERATIONS	BIO ENVIRONMENTAL ENG.
FIRE CHIEF	SAFETY
PROGRAM MANAGER	USING AGENCY

No.	Revision/Issue	Date	BY	APP'D
2	Added Fire Sprinkler Test Line locations			
1	Added detail for Typical Bathroom Sanitary Sewer			

PROJECT TITLE
TEMPORARY LODGING FACILITY


SHEET TITLE
PARTIAL SECOND FLOOR PLUMBING PLAN
AS-BUILT

DRAWN BY PNS	LEAD DESIGNER WET
TICR REVIEWER LSK	FILE LOCATION
DESIGNED BY LSK	PROJECT NUMBER WKA002-5001
DATE 28 MAY 2002	SHEET P5
SCALE AS NOTED	90 or 108

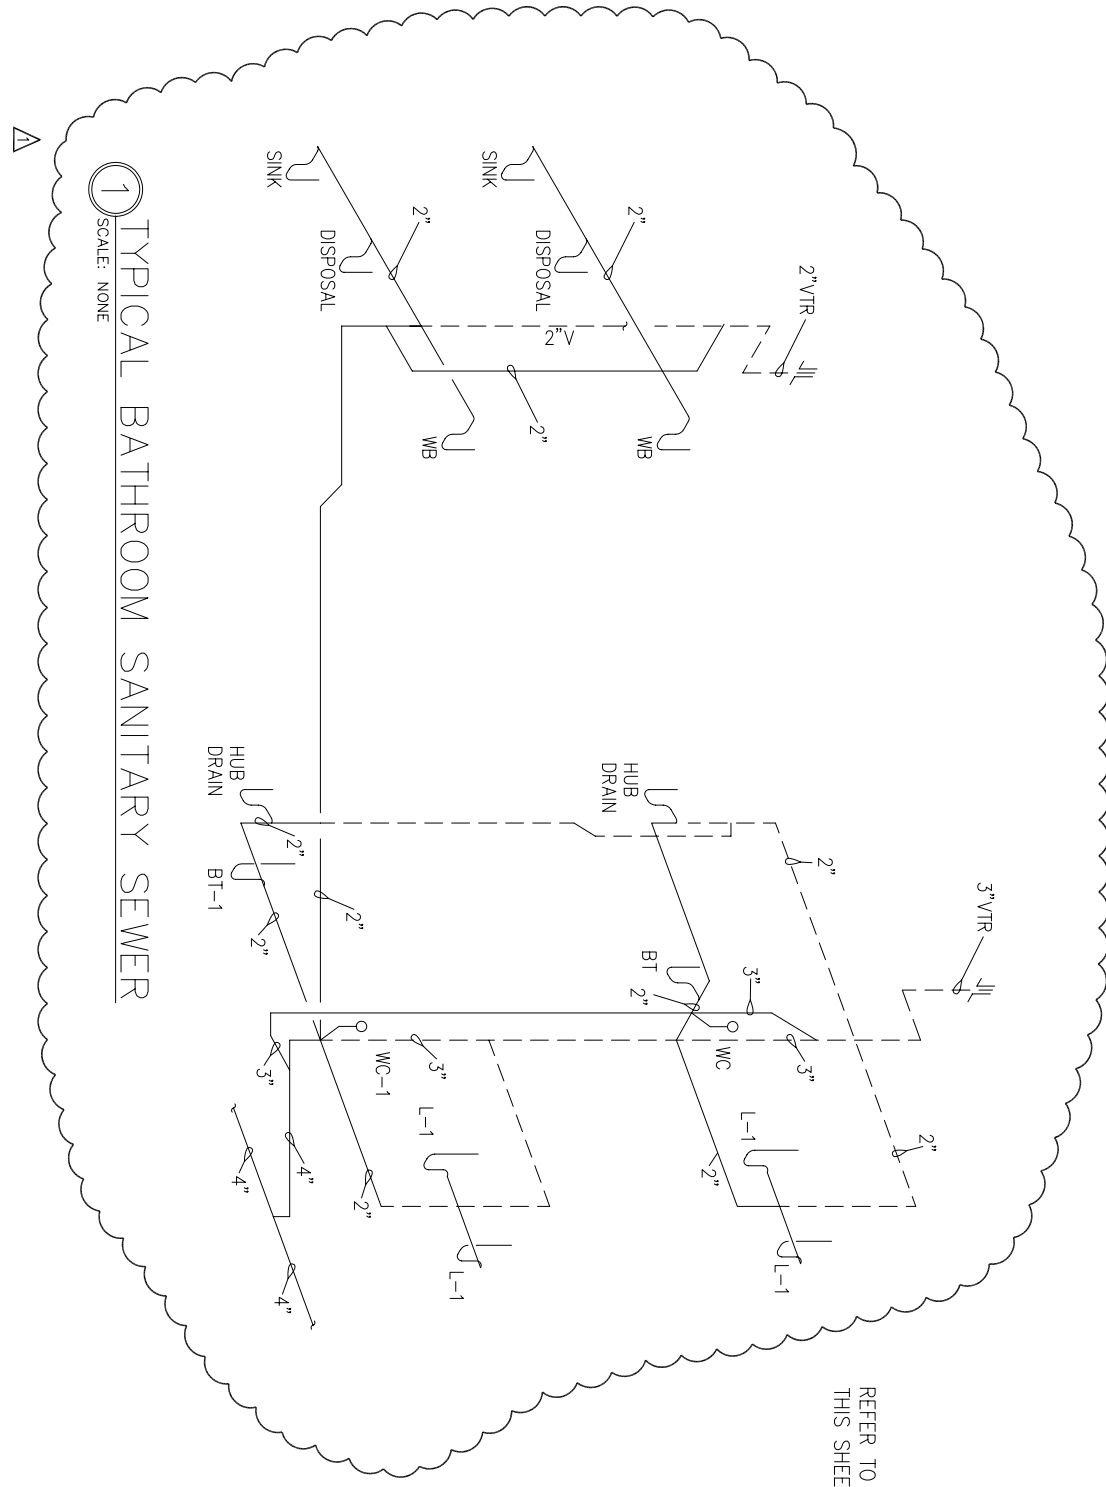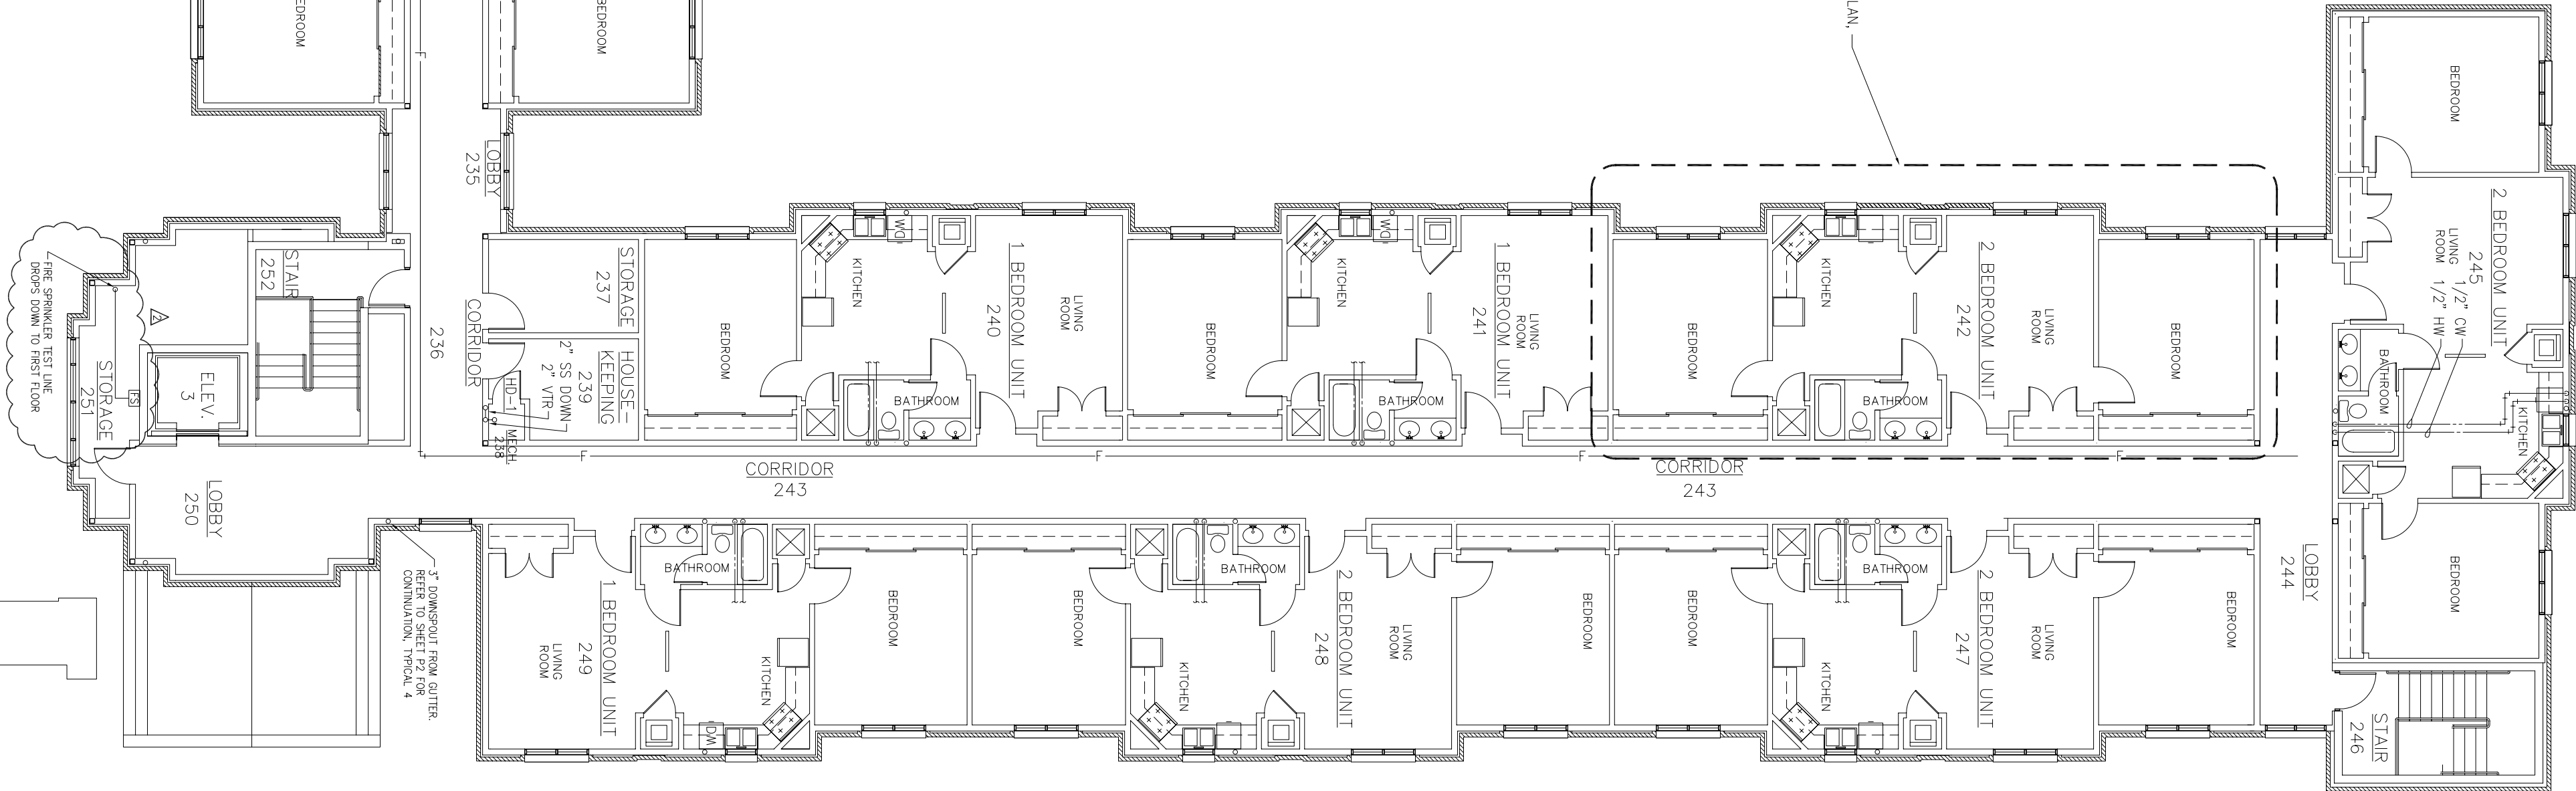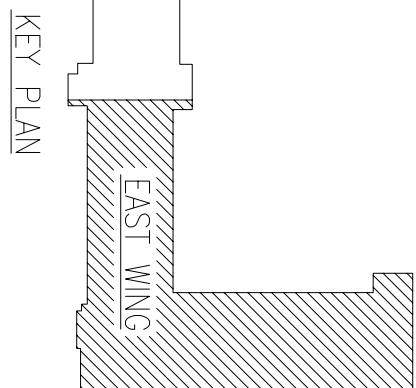

- LEGEND
- PENDANT TYPE SPRINKLER HEAD
 - SIDEWALL TYPE SPRINKLER HEAD
 - FIRE LINE
 - FS TAMPER SWITCH
 - FS FLOW SWITCH

1 ENLARGED PLAN AT 2 BEDROOM UNIT - PLUMBING
SCALE : 1/4"=1'-0"

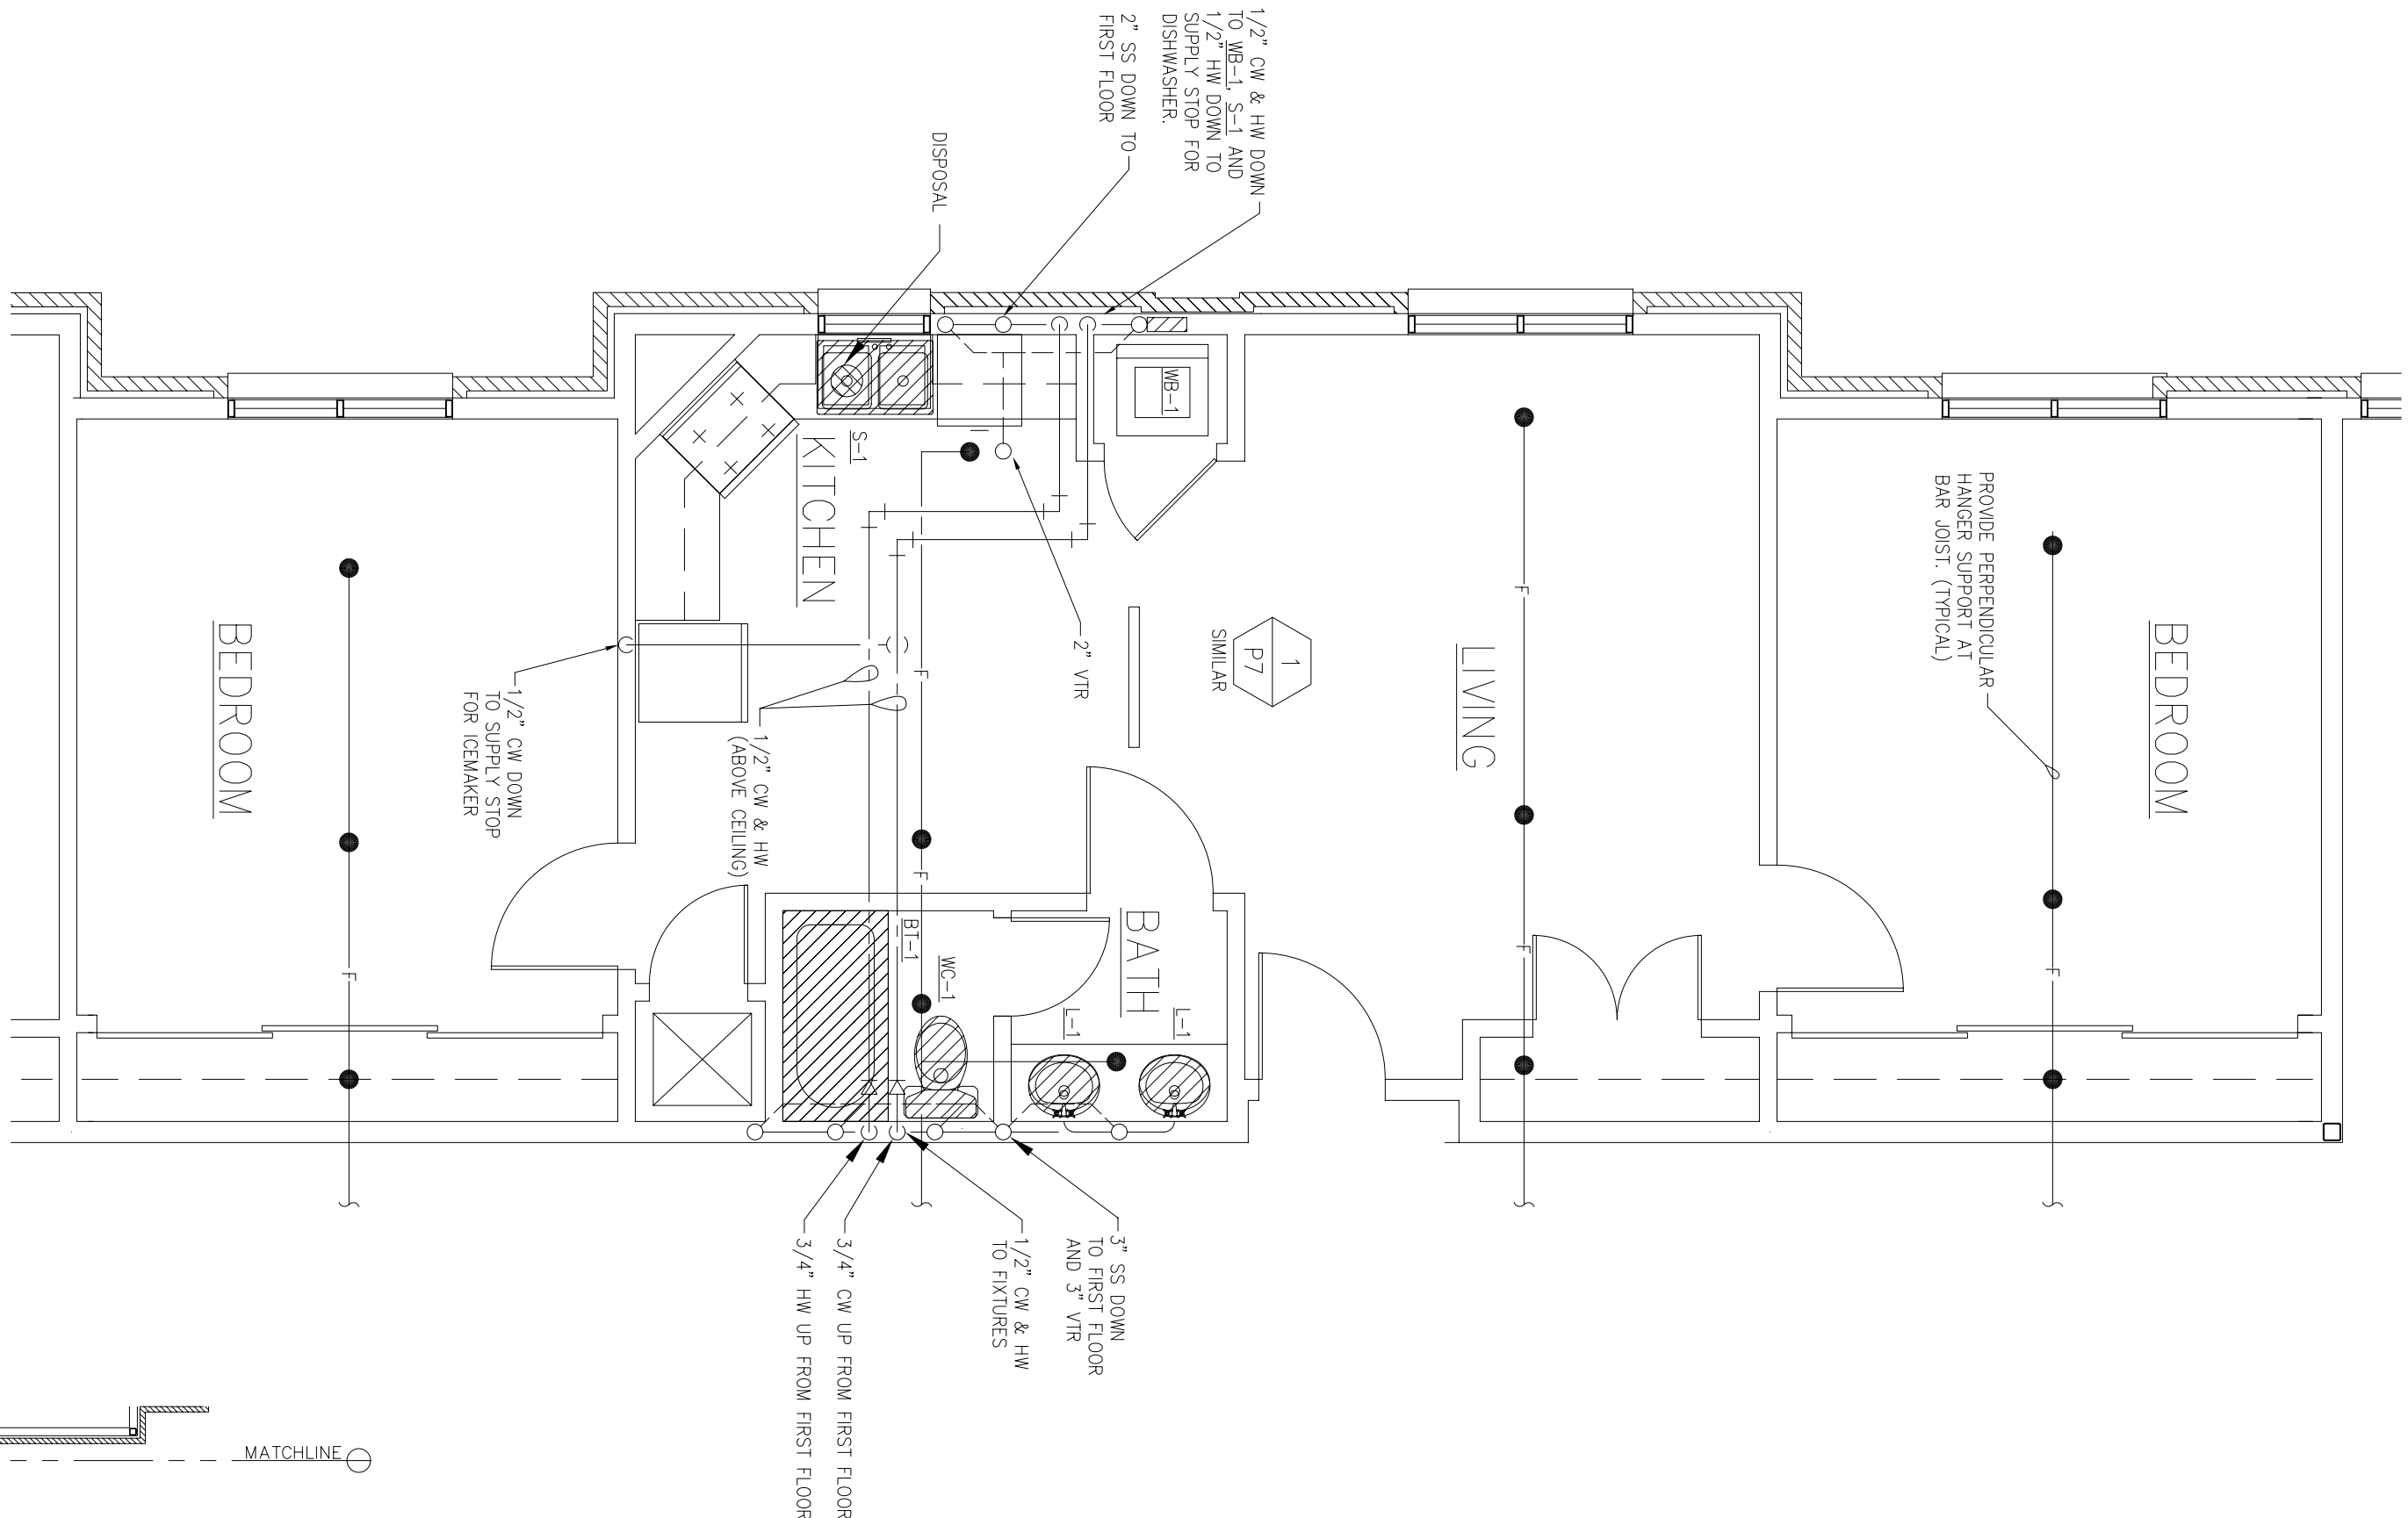

1 PARTIAL SECOND FLOOR PLUMBING PLAN - EAST WING
SCALE : 3/32"=1'-0"

