



LITTLE ROCK A.F.B.
ARKANSAS

DISPOSITION	DESCRIPTION	ROOMING	WATER		WWT	WASTE	R/OAD
			COLD	HOT			
WC-1	WATER CLOSET	FLOOR	1"	N/A	2"	4"	INTERGRAL
WC-2	WATER CLOSET	FLOOR/ADA	1"	N/A	2"	4"	INTERGRAL
L-1	LAVATORY	COUNTERTOP	1/2"	1/2"	2"	2"	1-1/4"
L-2	LAVATORY	WALL/ADA	1/2"	1/2"	2"	2"	1-1/4"
L-3	LAVATORY	WALL	1/2"	1/2"	2"	2"	1-1/4"
S-1	DOUBLE SINK WITH DISPOSAL	COUNTERTOP	1/2"	1/2"	2"	2"	1-1/2"
SS-1	SERVICE SINK	FLOOR/CORNER	1/2"	1/2"	2"	3"	1-1/2"
HB-1	HOSE BIBB	EXTERIOR WALL	1/2"	N/A	N/A	N/A	N/A
HB-2	HOSE BIBB	INTERIOR WALL	1/2"	N/A	N/A	N/A	N/A
WB-1	WASHER BOX	RECESSED	1/2"	1/2"	2"	2"	2"


5 DOMESTIC WATER HEATER PIPING DETAIL
SCALE: NONE

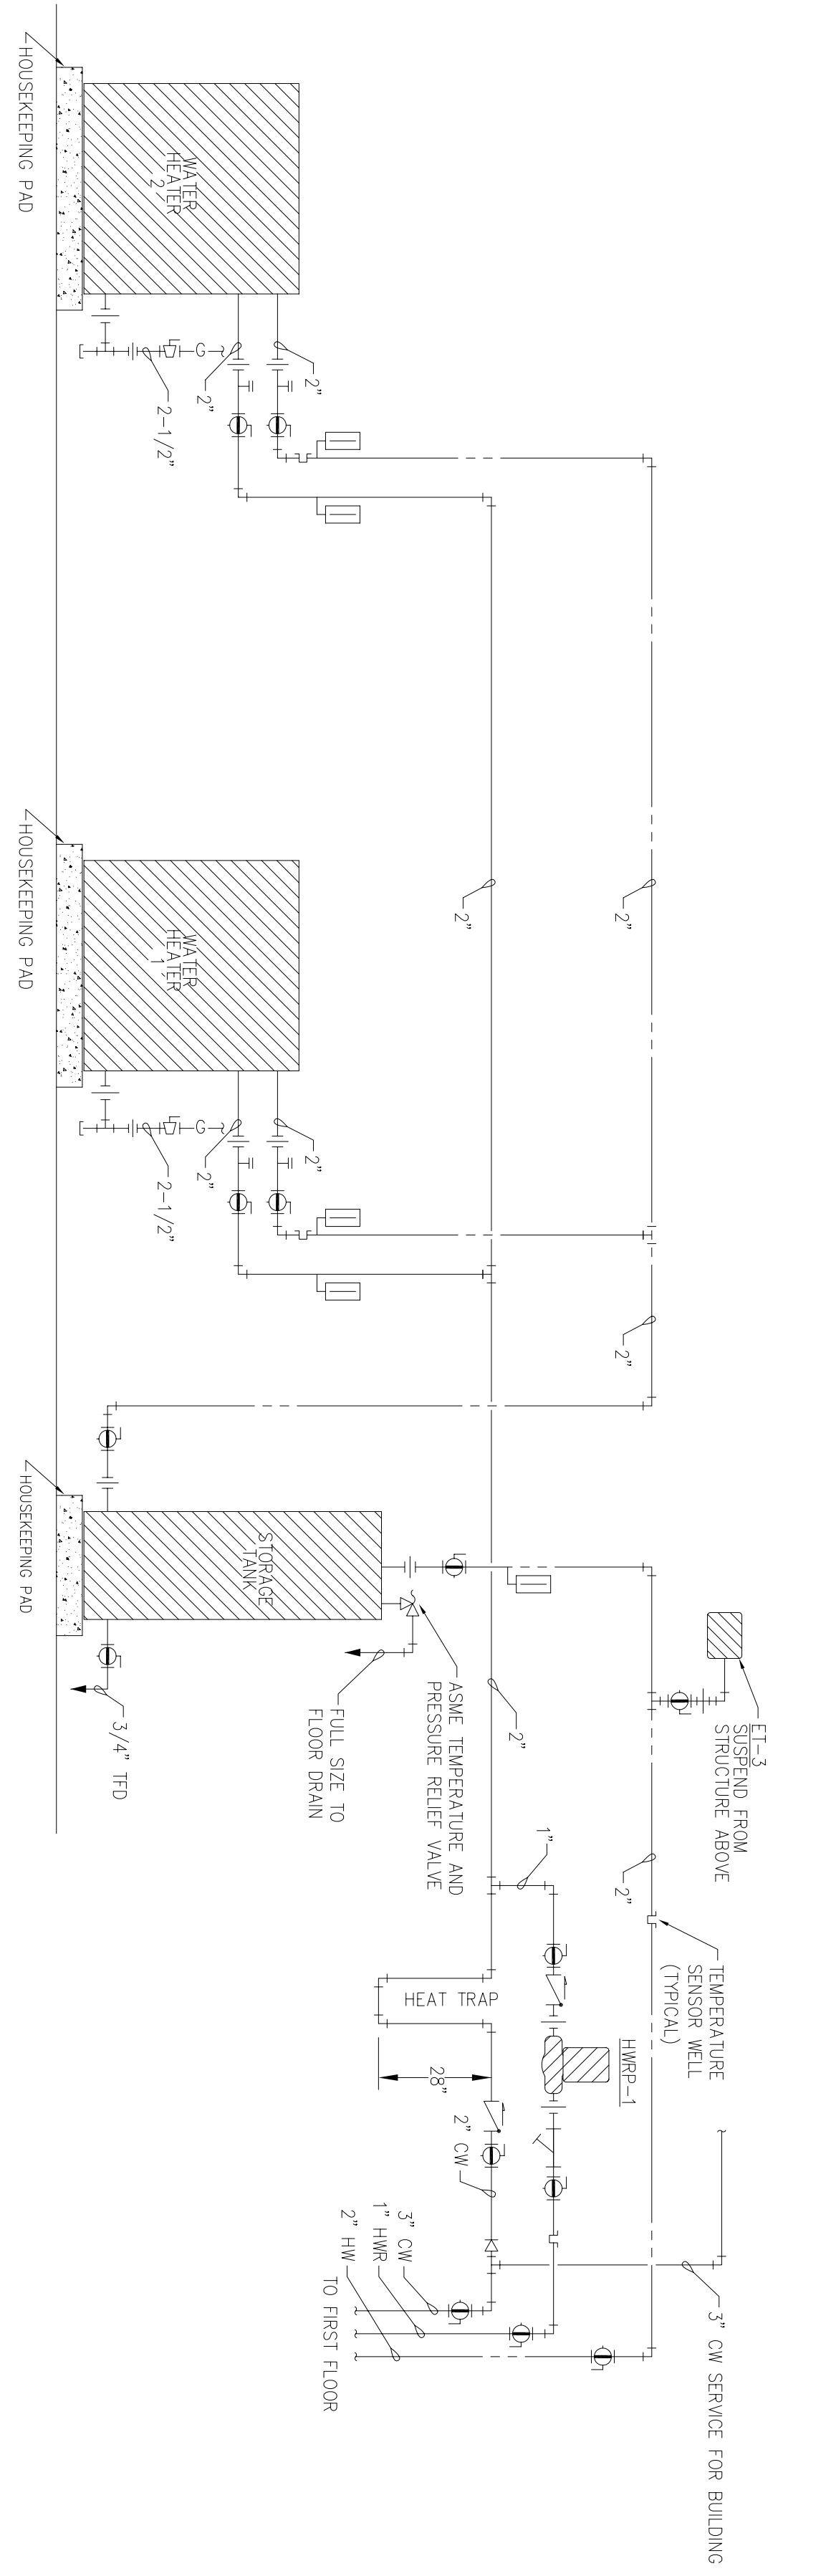


6 TWO-WAY CLEANOUT TO GRADE DETAIL
SCALE: NONE

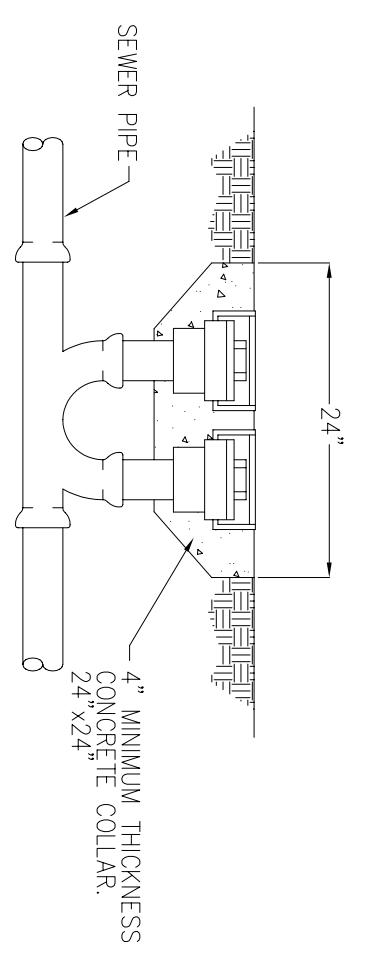


7 SUMP PUMP DETAIL
SCALE: NONE

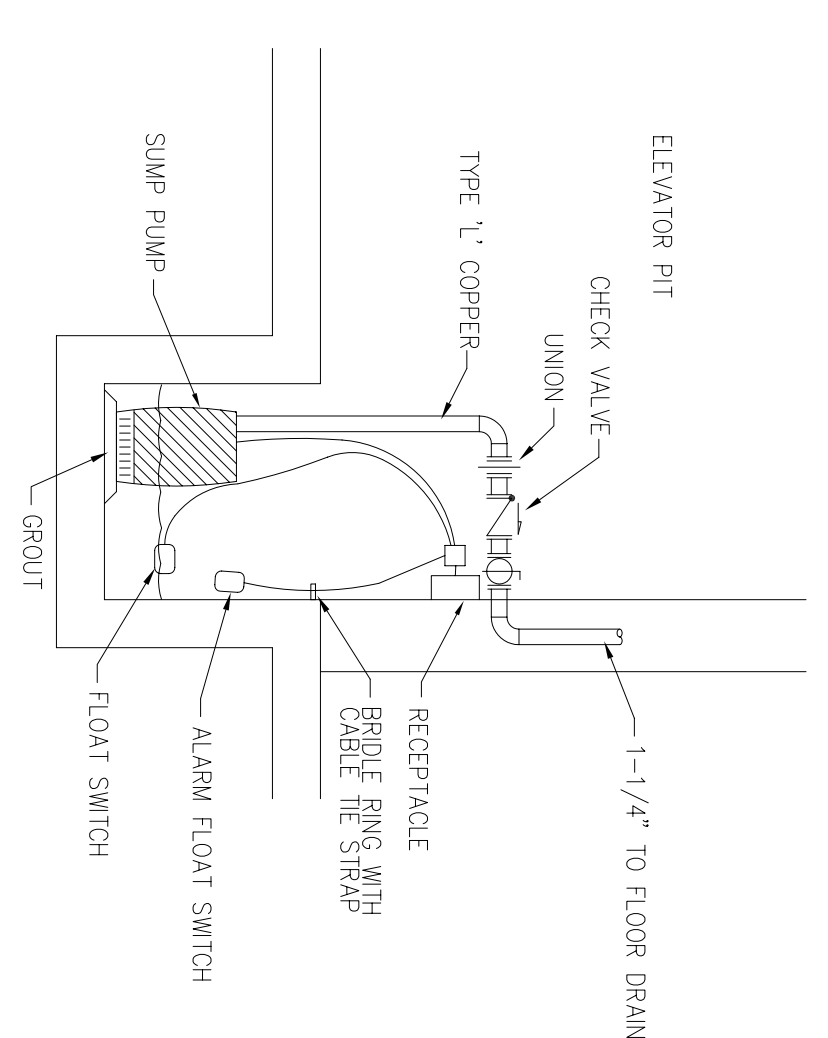


8 DOMESTIC WATER RPZ DETAIL
SCALE: NONE

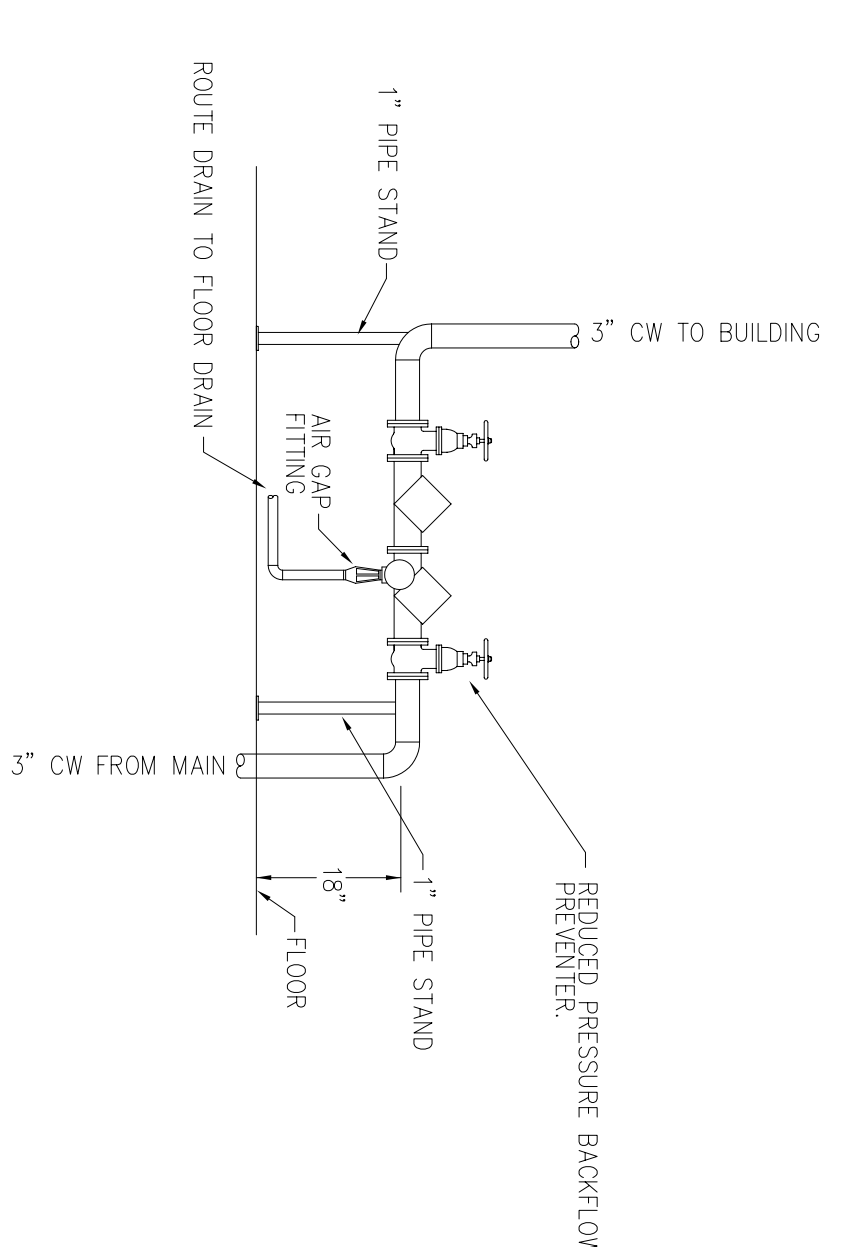


9 SPRINKLER RISER DETAIL
SCALE: NONE

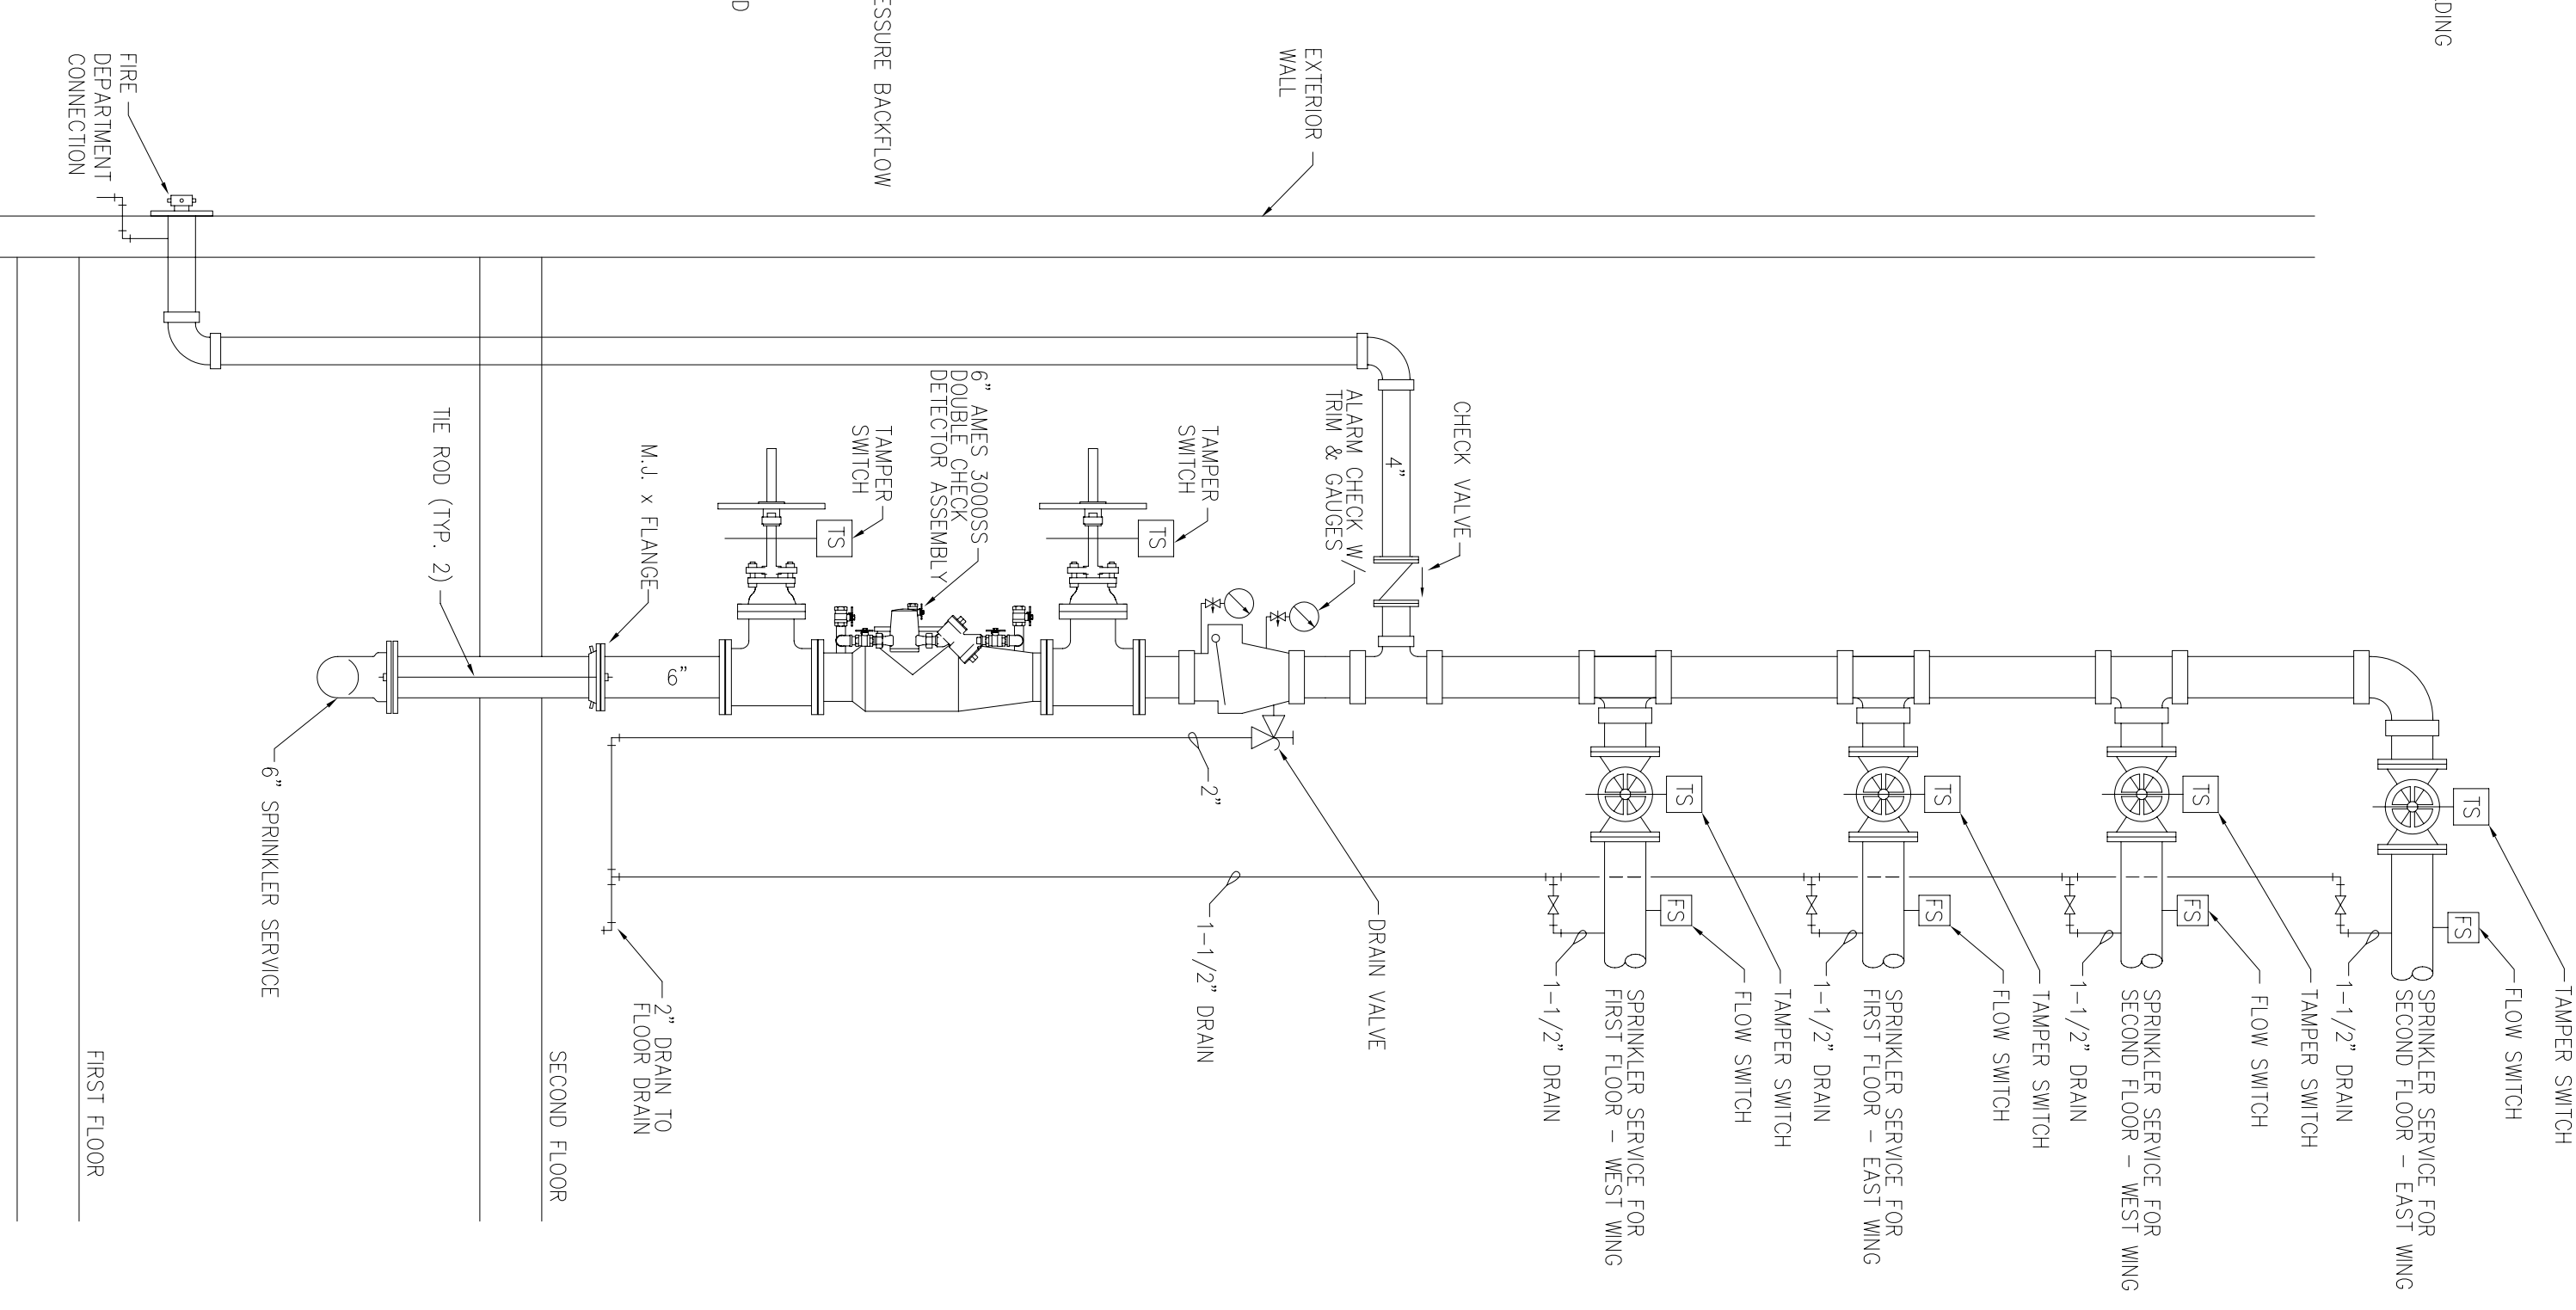


1 PLUMBING RISER
SCALE: NONE

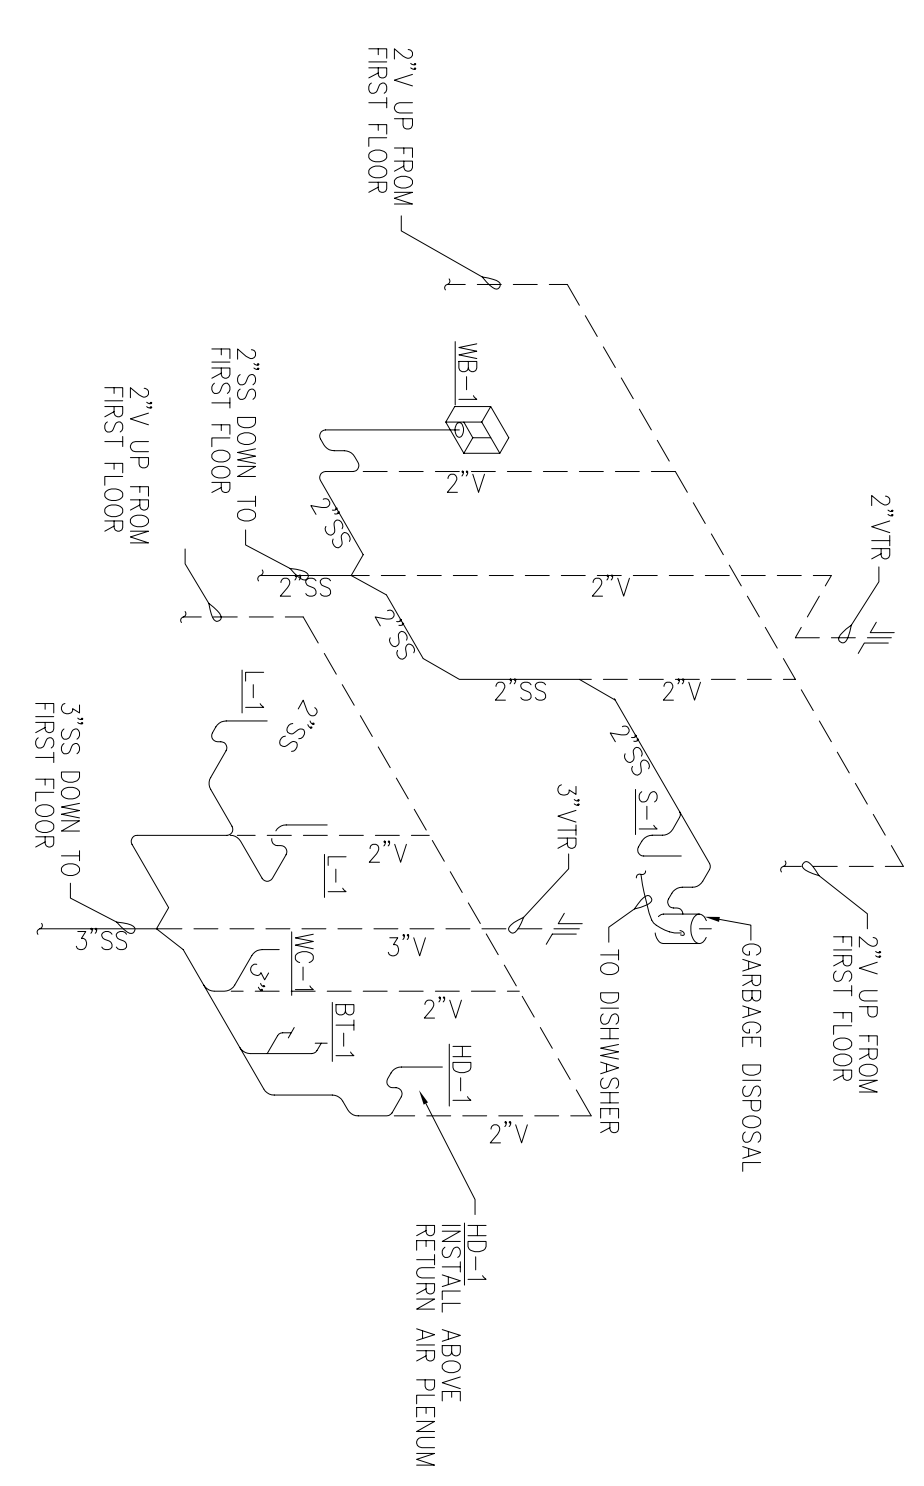


2 PLUMBING RISER
SCALE: NONE

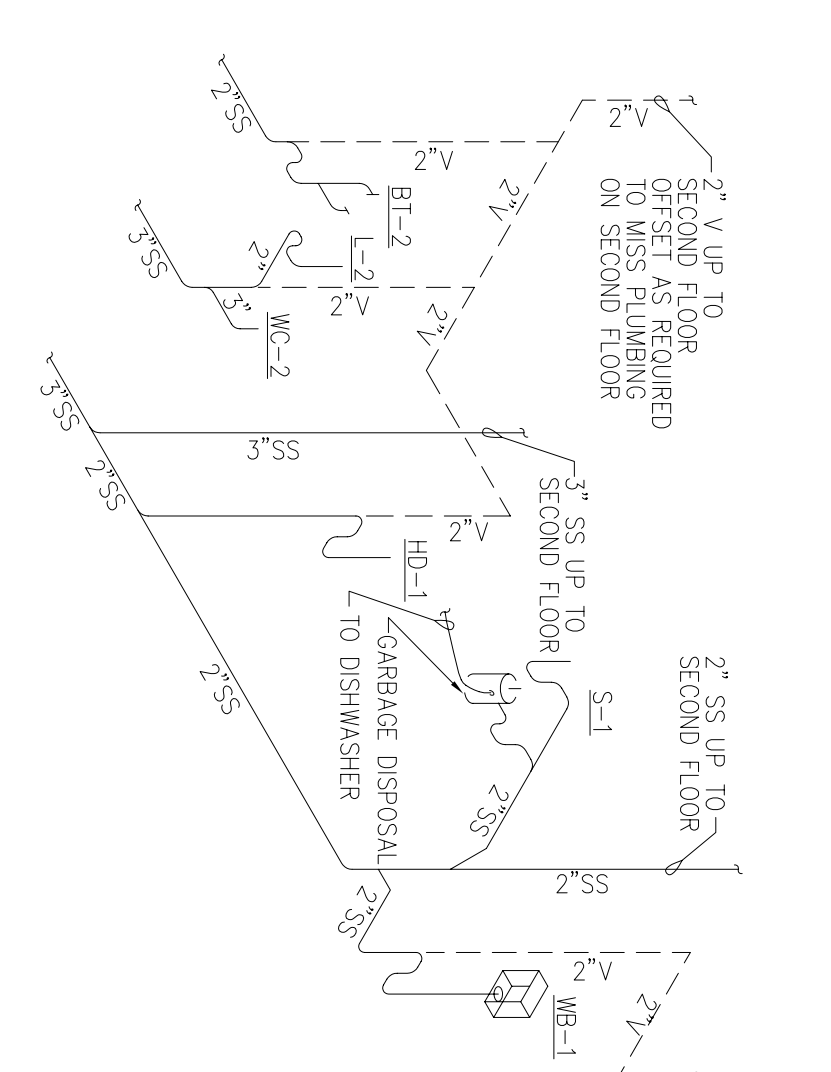

3 PLUMBING RISER
SCALE: NONE

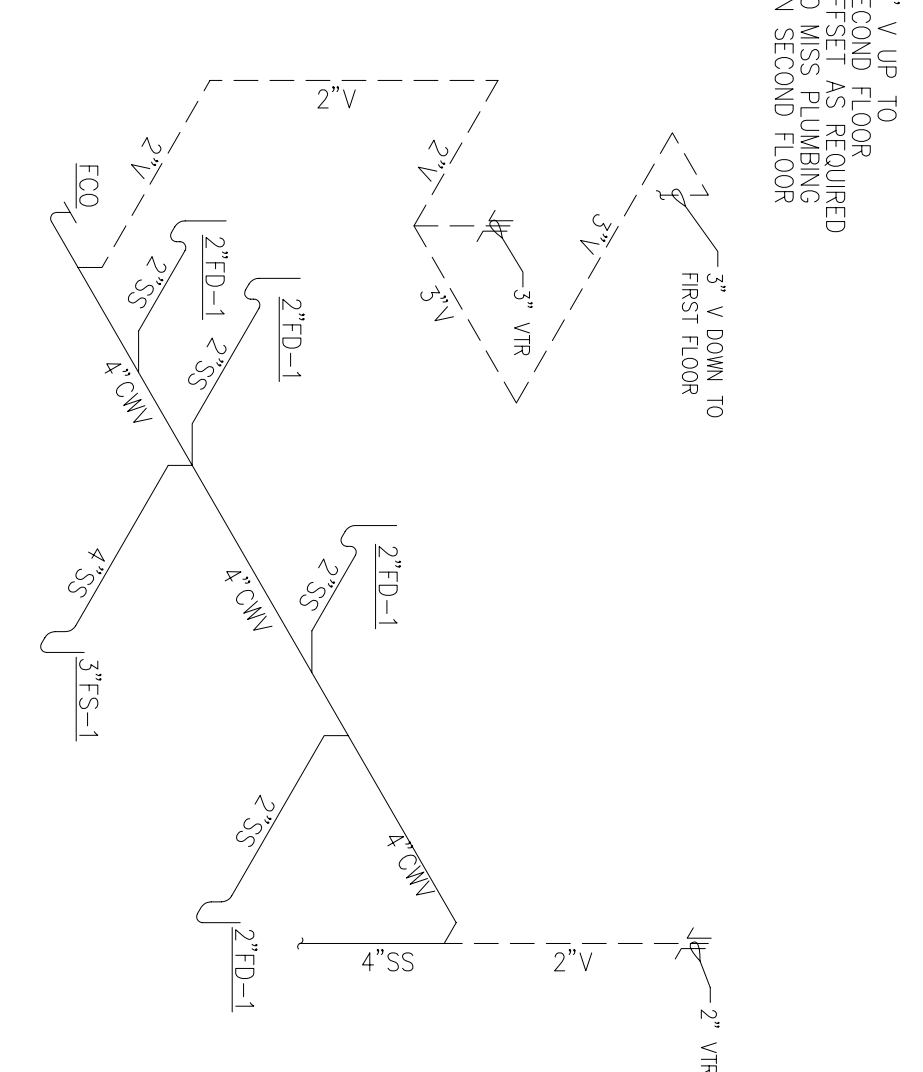

4 PLUMBING RISER
SCALE: NONE

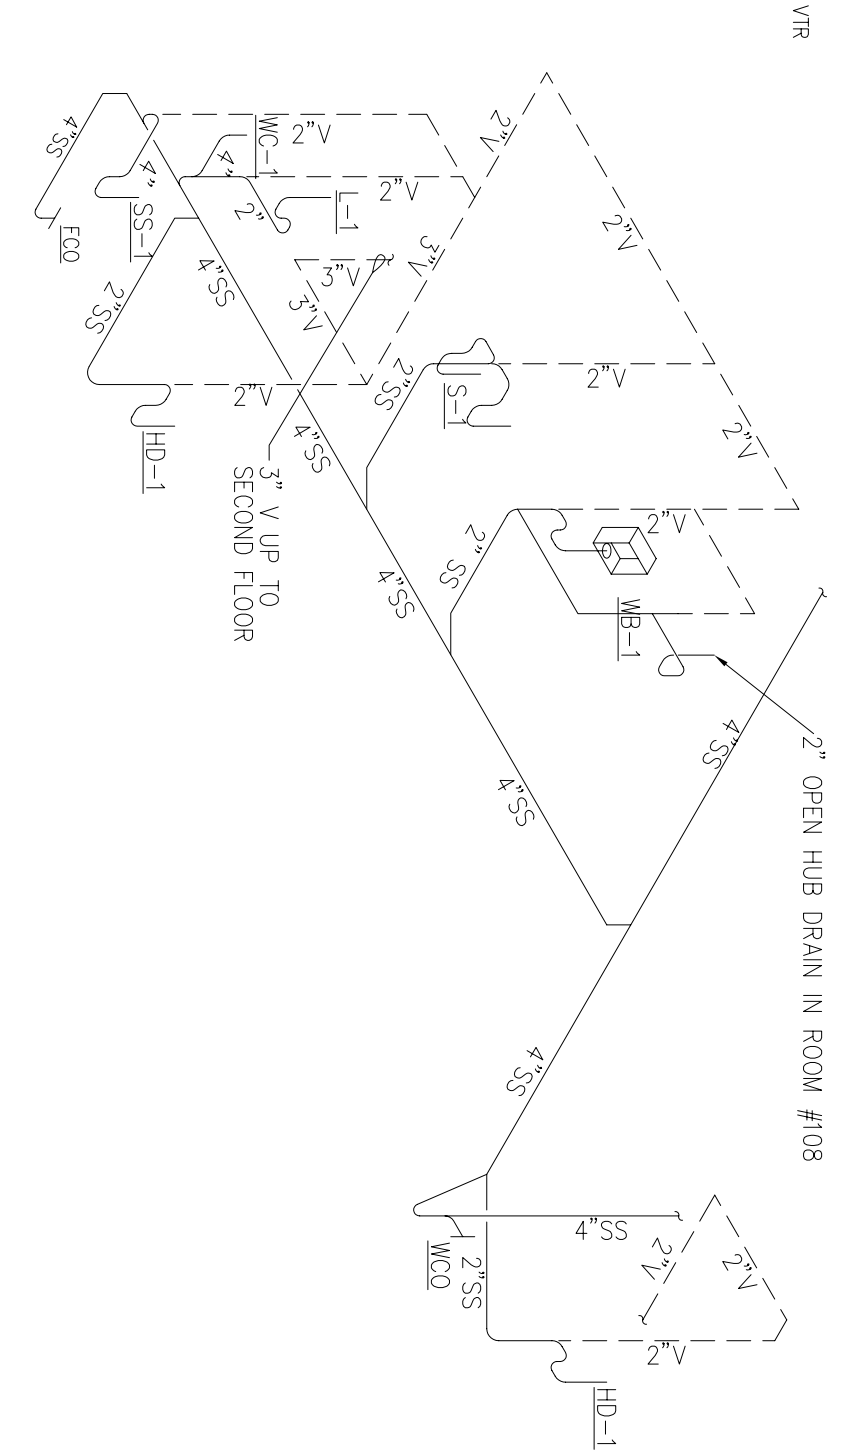

PROJECT TITLE
TEMPORARY LODGING FACILITY

SHEET TITLE
PLUMBING RISERS AND DETAILS AS-BUILT

PROJECT NUMBER
NKA02-5001

DATE
28 MAY 2002

SHEET
P7

92 of 108

No.	Revision/Issue	Date	BY	APP'D
1	No changes from Design to As-Built			

OWNER ENGINEER	CHIEF ENGINEER
CHIEF OF OPERATIONS	BIO ENVIRONMENTAL ENG.
FIRE CHIEF	SAFETY
PROGRAM MANAGER	USING AGENCY

DRAWN BY PNS	LEAD DESIGNER WET
TITLE ENGINEER	FILE LOCATION
DESIGNED BY LSK	PROJECT NUMBER NKA02-5001
DATE 28 MAY 2002	SHEET P7
SCALE NONE	92 of 108