

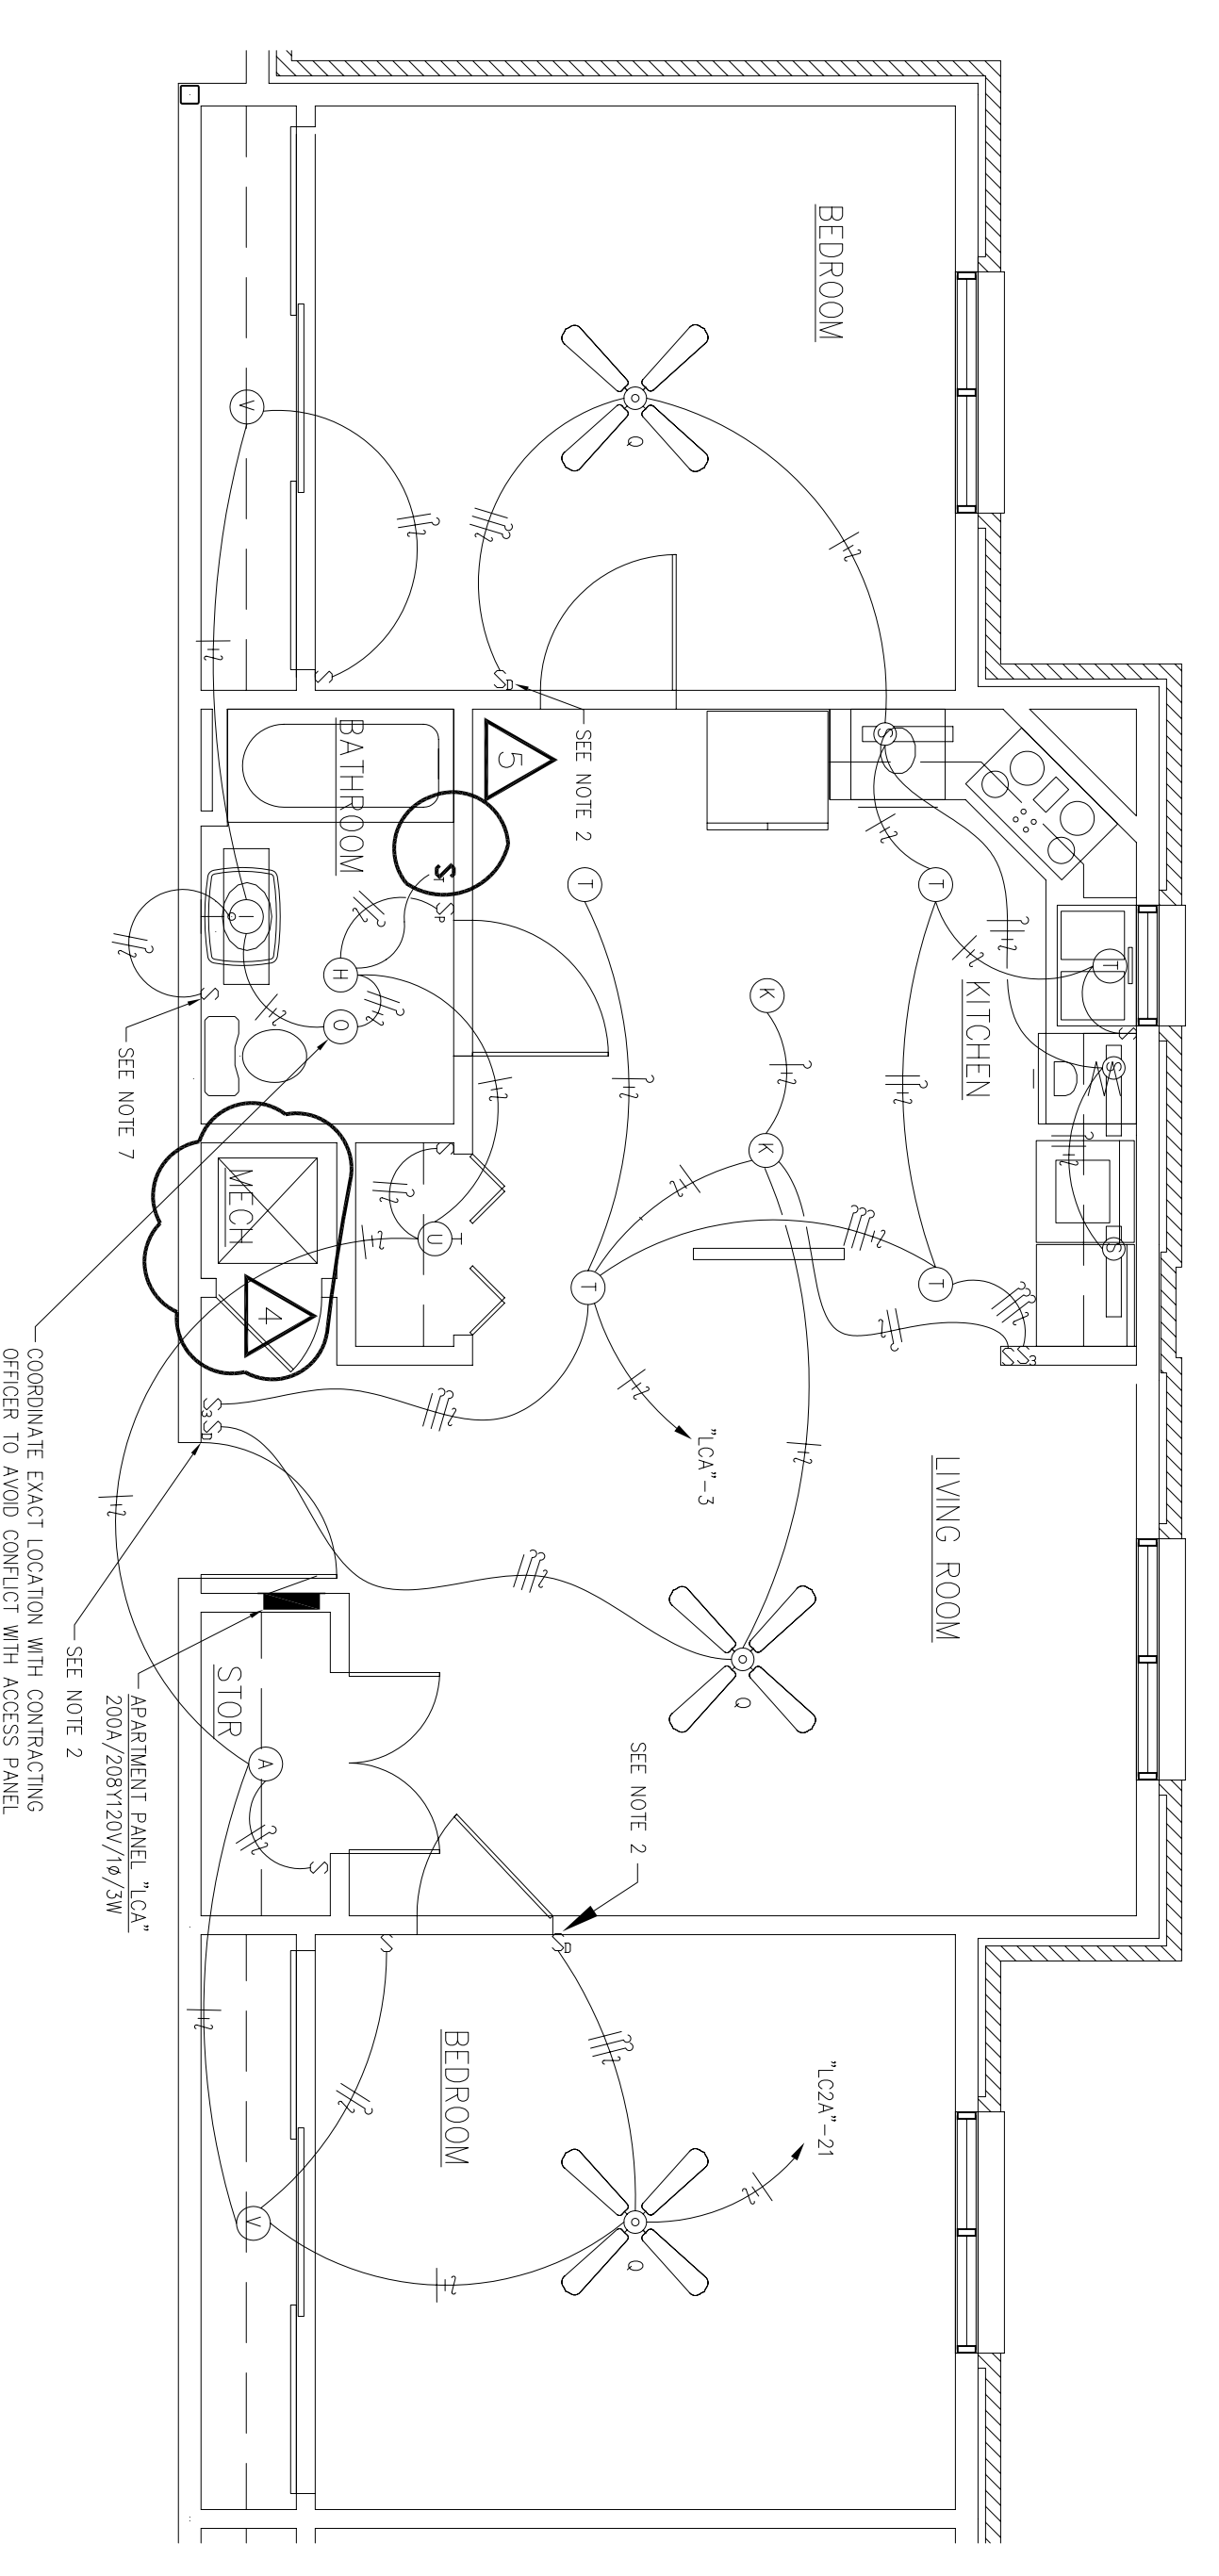


LITTLE ROCK A.F.B.
ARKANSAS


- NOTES:
1. INSTALL ONE TYPE "R" LIGHT FIXTURE @ 2'-0" SPACING BY FLOOR AND ONE TYPE "B" LIGHT FIXTURE AT 7'-0" SPACING EACH FLOOR (LANDING), ELEVATOR CAB, RAMP, AND CHAIRS.
 2. DUAL SLIDE FAN SPEED AND DIMMER CONTROL EQUAL TO LEVITON #630.
 3. TYPE B FIXTURES TO BE NON-SWITCHED.
 4. TO TYPE "R" FIXTURES, REFER TO SHEET PAGE1
 5. DOWN TO BOLLARD LIGHTS.
 6. NOT USED
 7. METAL SWITCH IN SAME ENCLOSURE AS ON RECEPTACLE.

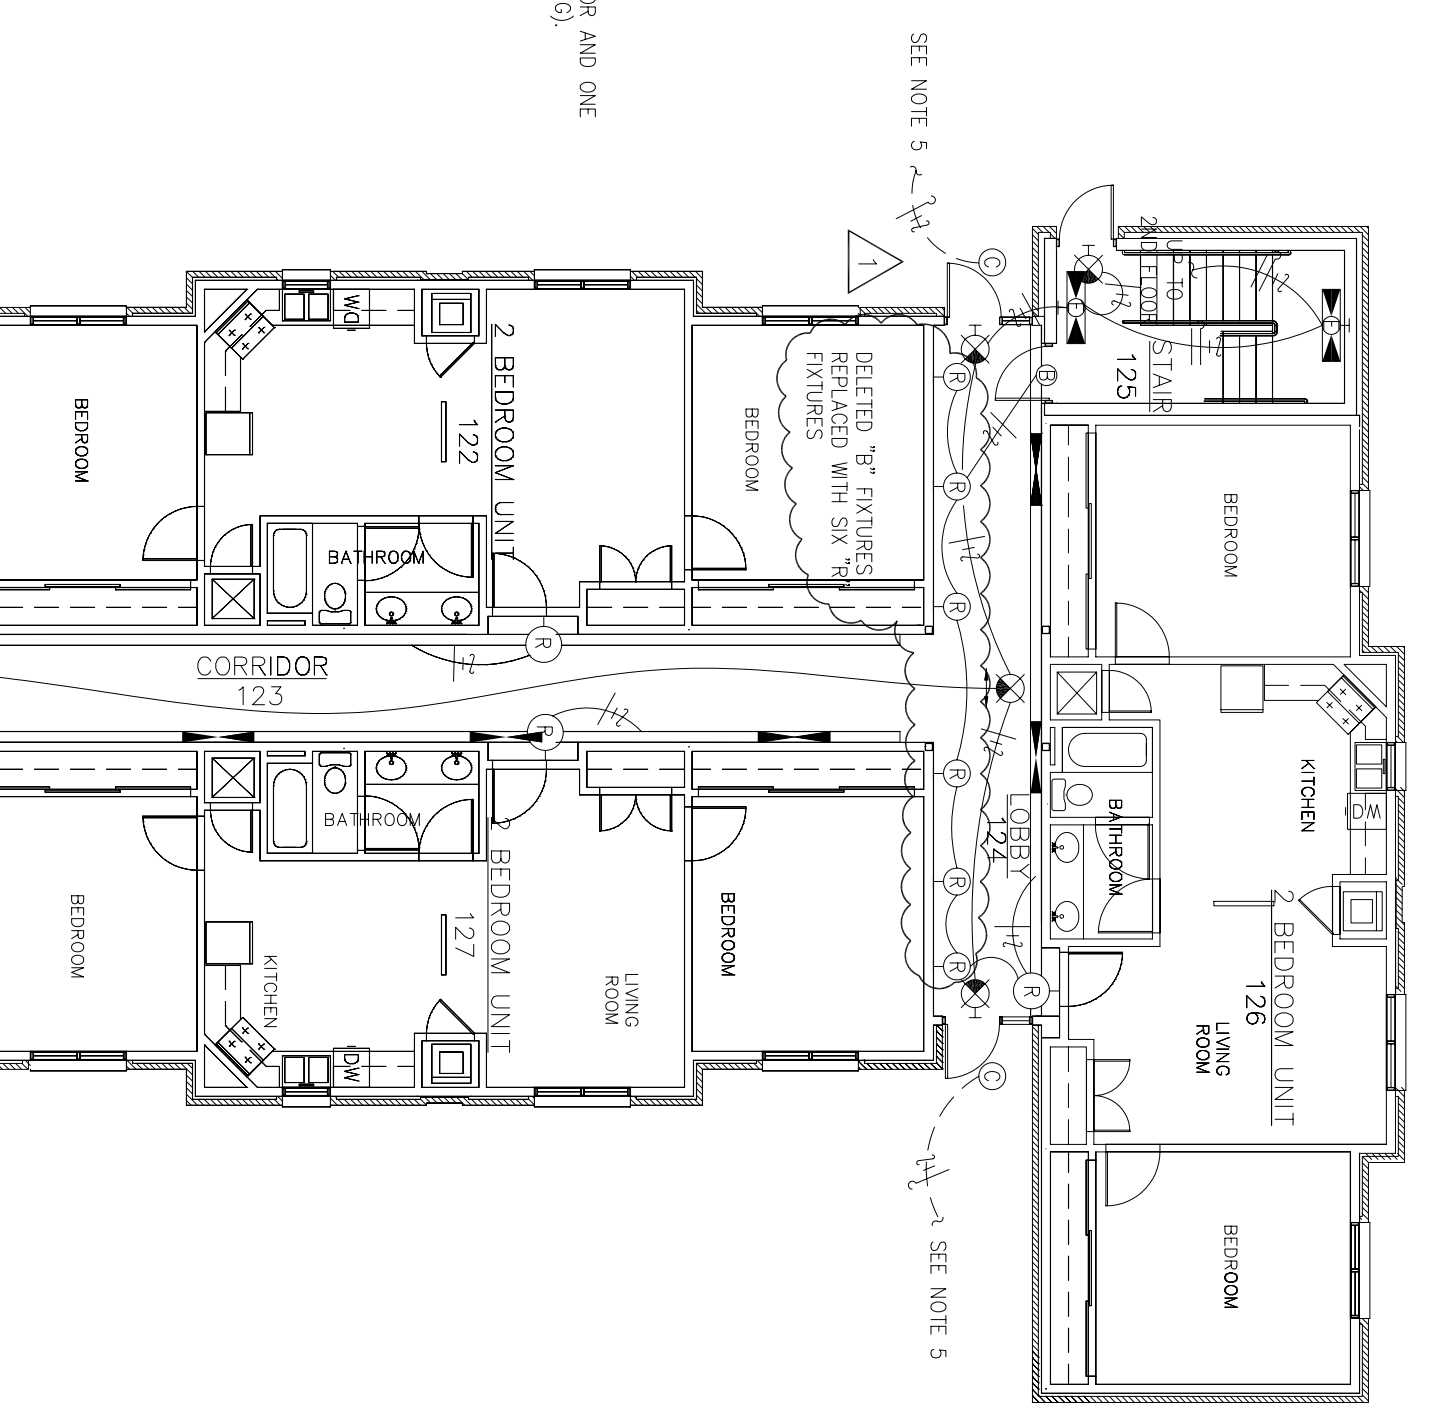

2 TYPICAL TWO BEDROOM ADA UNIT - LIGHTING
SCALE: 1/4" = 1'-0"

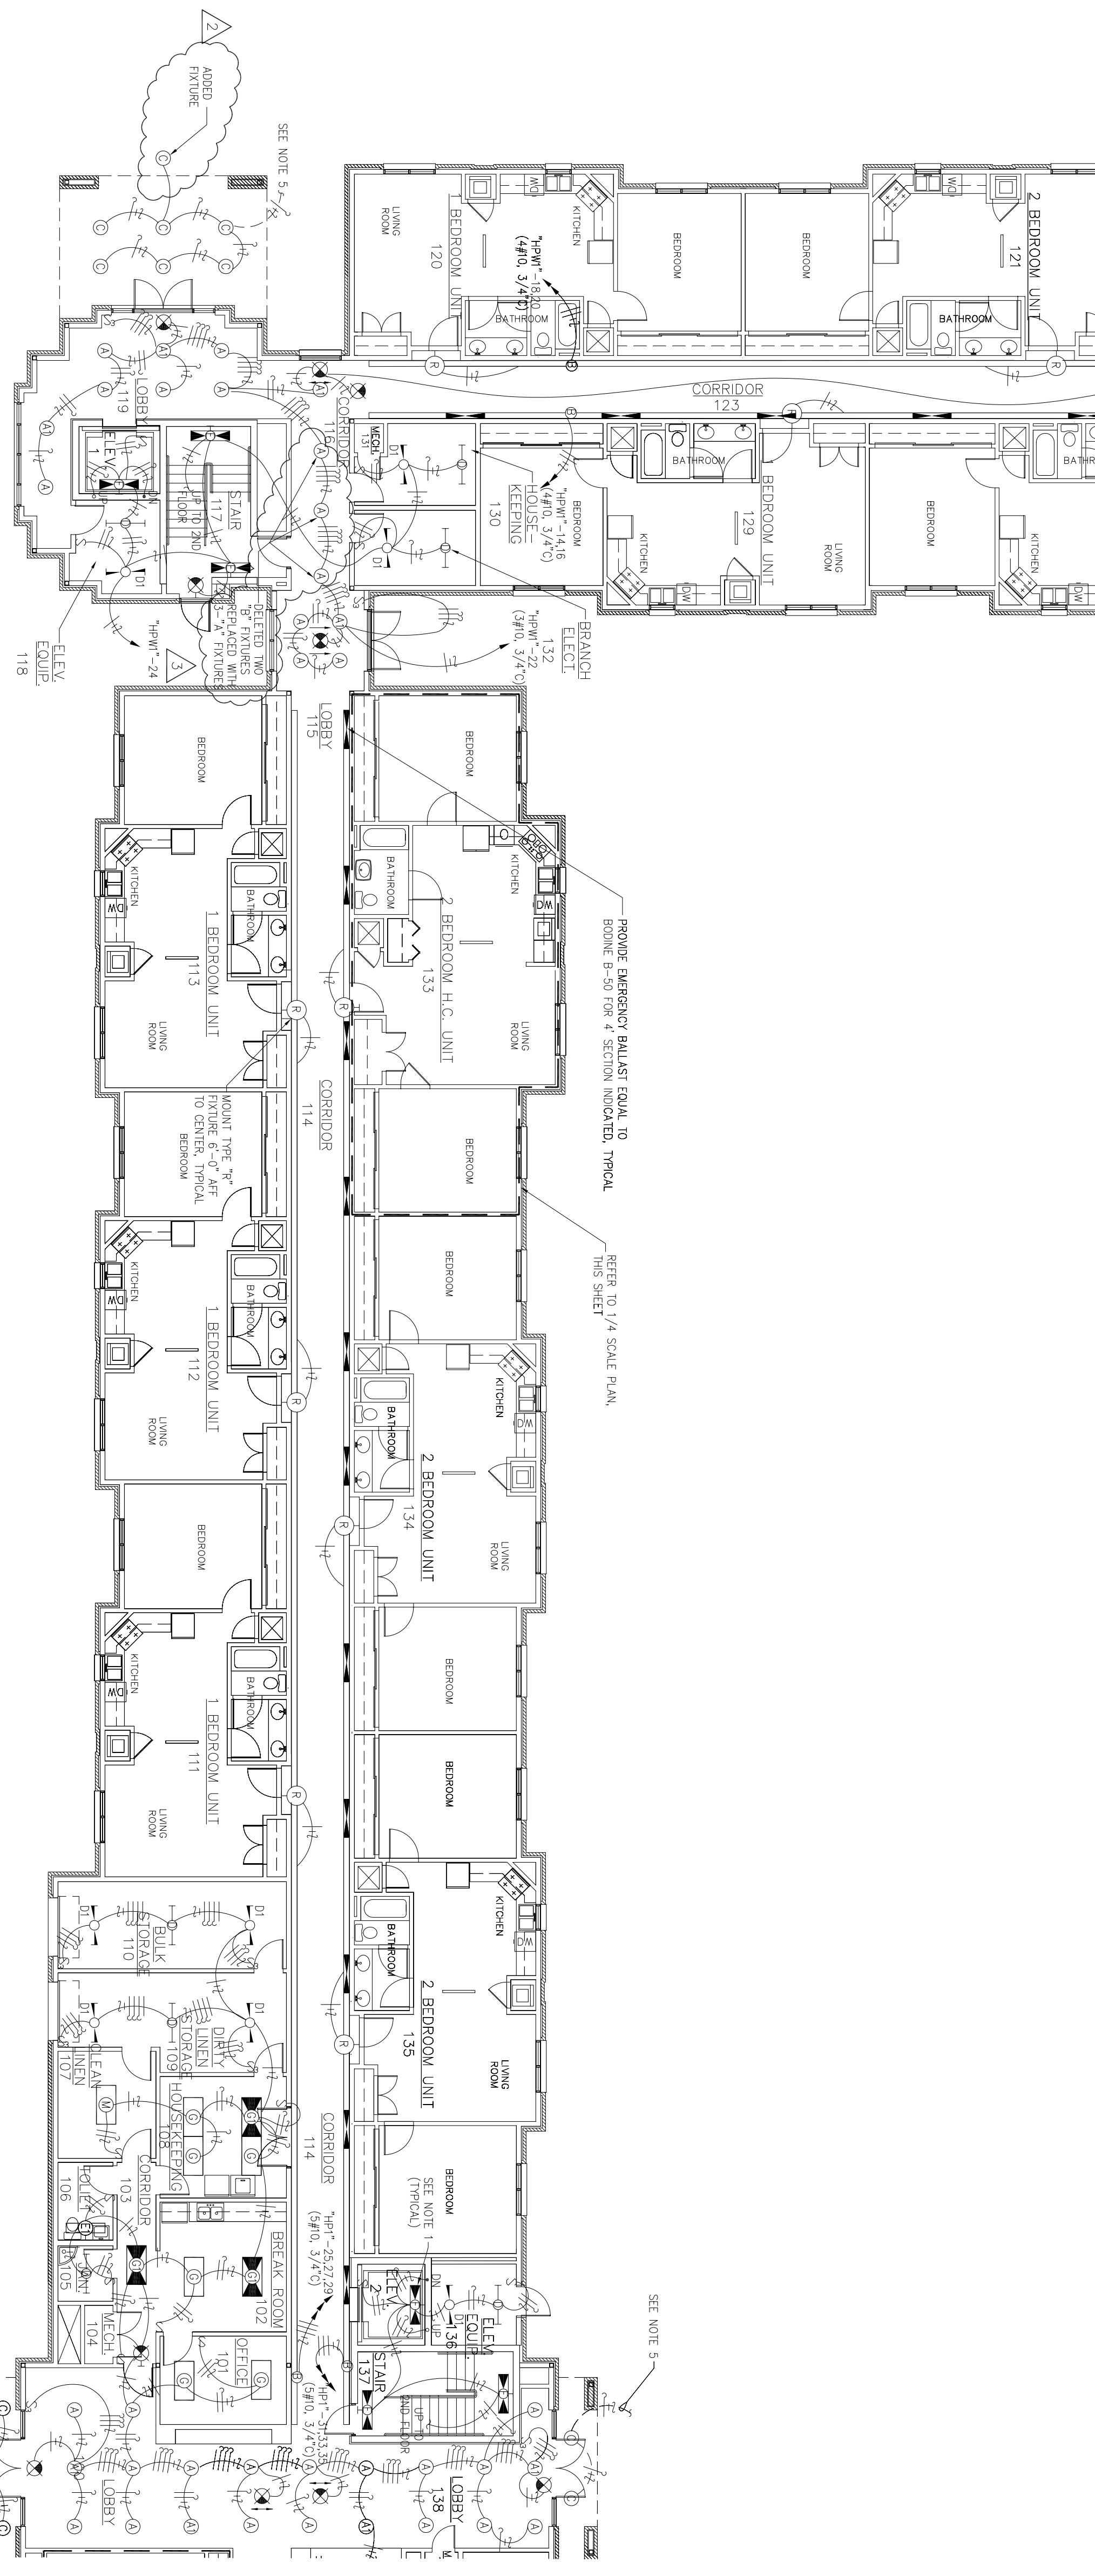

1 PARTIAL FIRST FLOOR LIGHTING PLAN - WEST WING
SCALE: 3/32" = 1'-0"

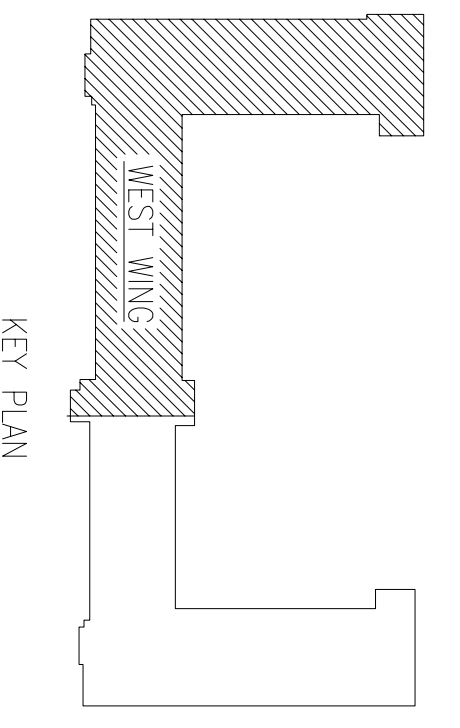

KEY PLAN

CHIEF ENGINEER	CHIEF ENGINEER
CHIEF OF OPERATIONS	BIO ENVIRONMENTAL ENG.
FIRE CHIEF	SAFETY
PROGRAM MANAGER	USING AGENCY

No.	Revision/Issue	Date	BY	APP'D
5	Noted switches added			
4	Deleted "U" fixture in Mech Room and associated switch			
3	Deleted the "B" fixtures and replaced with three "A" fixtures			
2	"C" fixture added outside exterior Porcio			
1	Deleted the "B" fixtures and replaced with six "R" fixtures			

PROJECT TITLE
TEMPORARY LODGING FACILITY

SHEET TITLE
PARTIAL FIRST FLOOR LIGHTING PLAN AS-BUILT

DRAWN BY KRD	LEAD DESIGNER BRM
TECH REVIEWER	FILE LOCATION
DESIGNED BY BIM	PROJECT NUMBER NKA02-5001
DATE 28 MAY 2002	SHEET E2
SCALE AS NOTED	93 of 108