



LITTLE ROCK A.F.B.  
ARKANSAS

NOTES:

1. INSTALL ONE TYPE 'A' LIGHT FIXTURE @ 2'-6" ABOVE PIT FLOOR AND ONE TYPE 'B' LIGHT FIXTURE @ 7'-0" ABOVE PIT FLOOR (LANDING). FIELD VERIFY EXACT LOCATION TO AVOID CONFLICT WITH ELEVATOR CAR, TRUCK, AND CABLES.
2. THE 'B' FIXTURE TO BE NONSWITCHED.

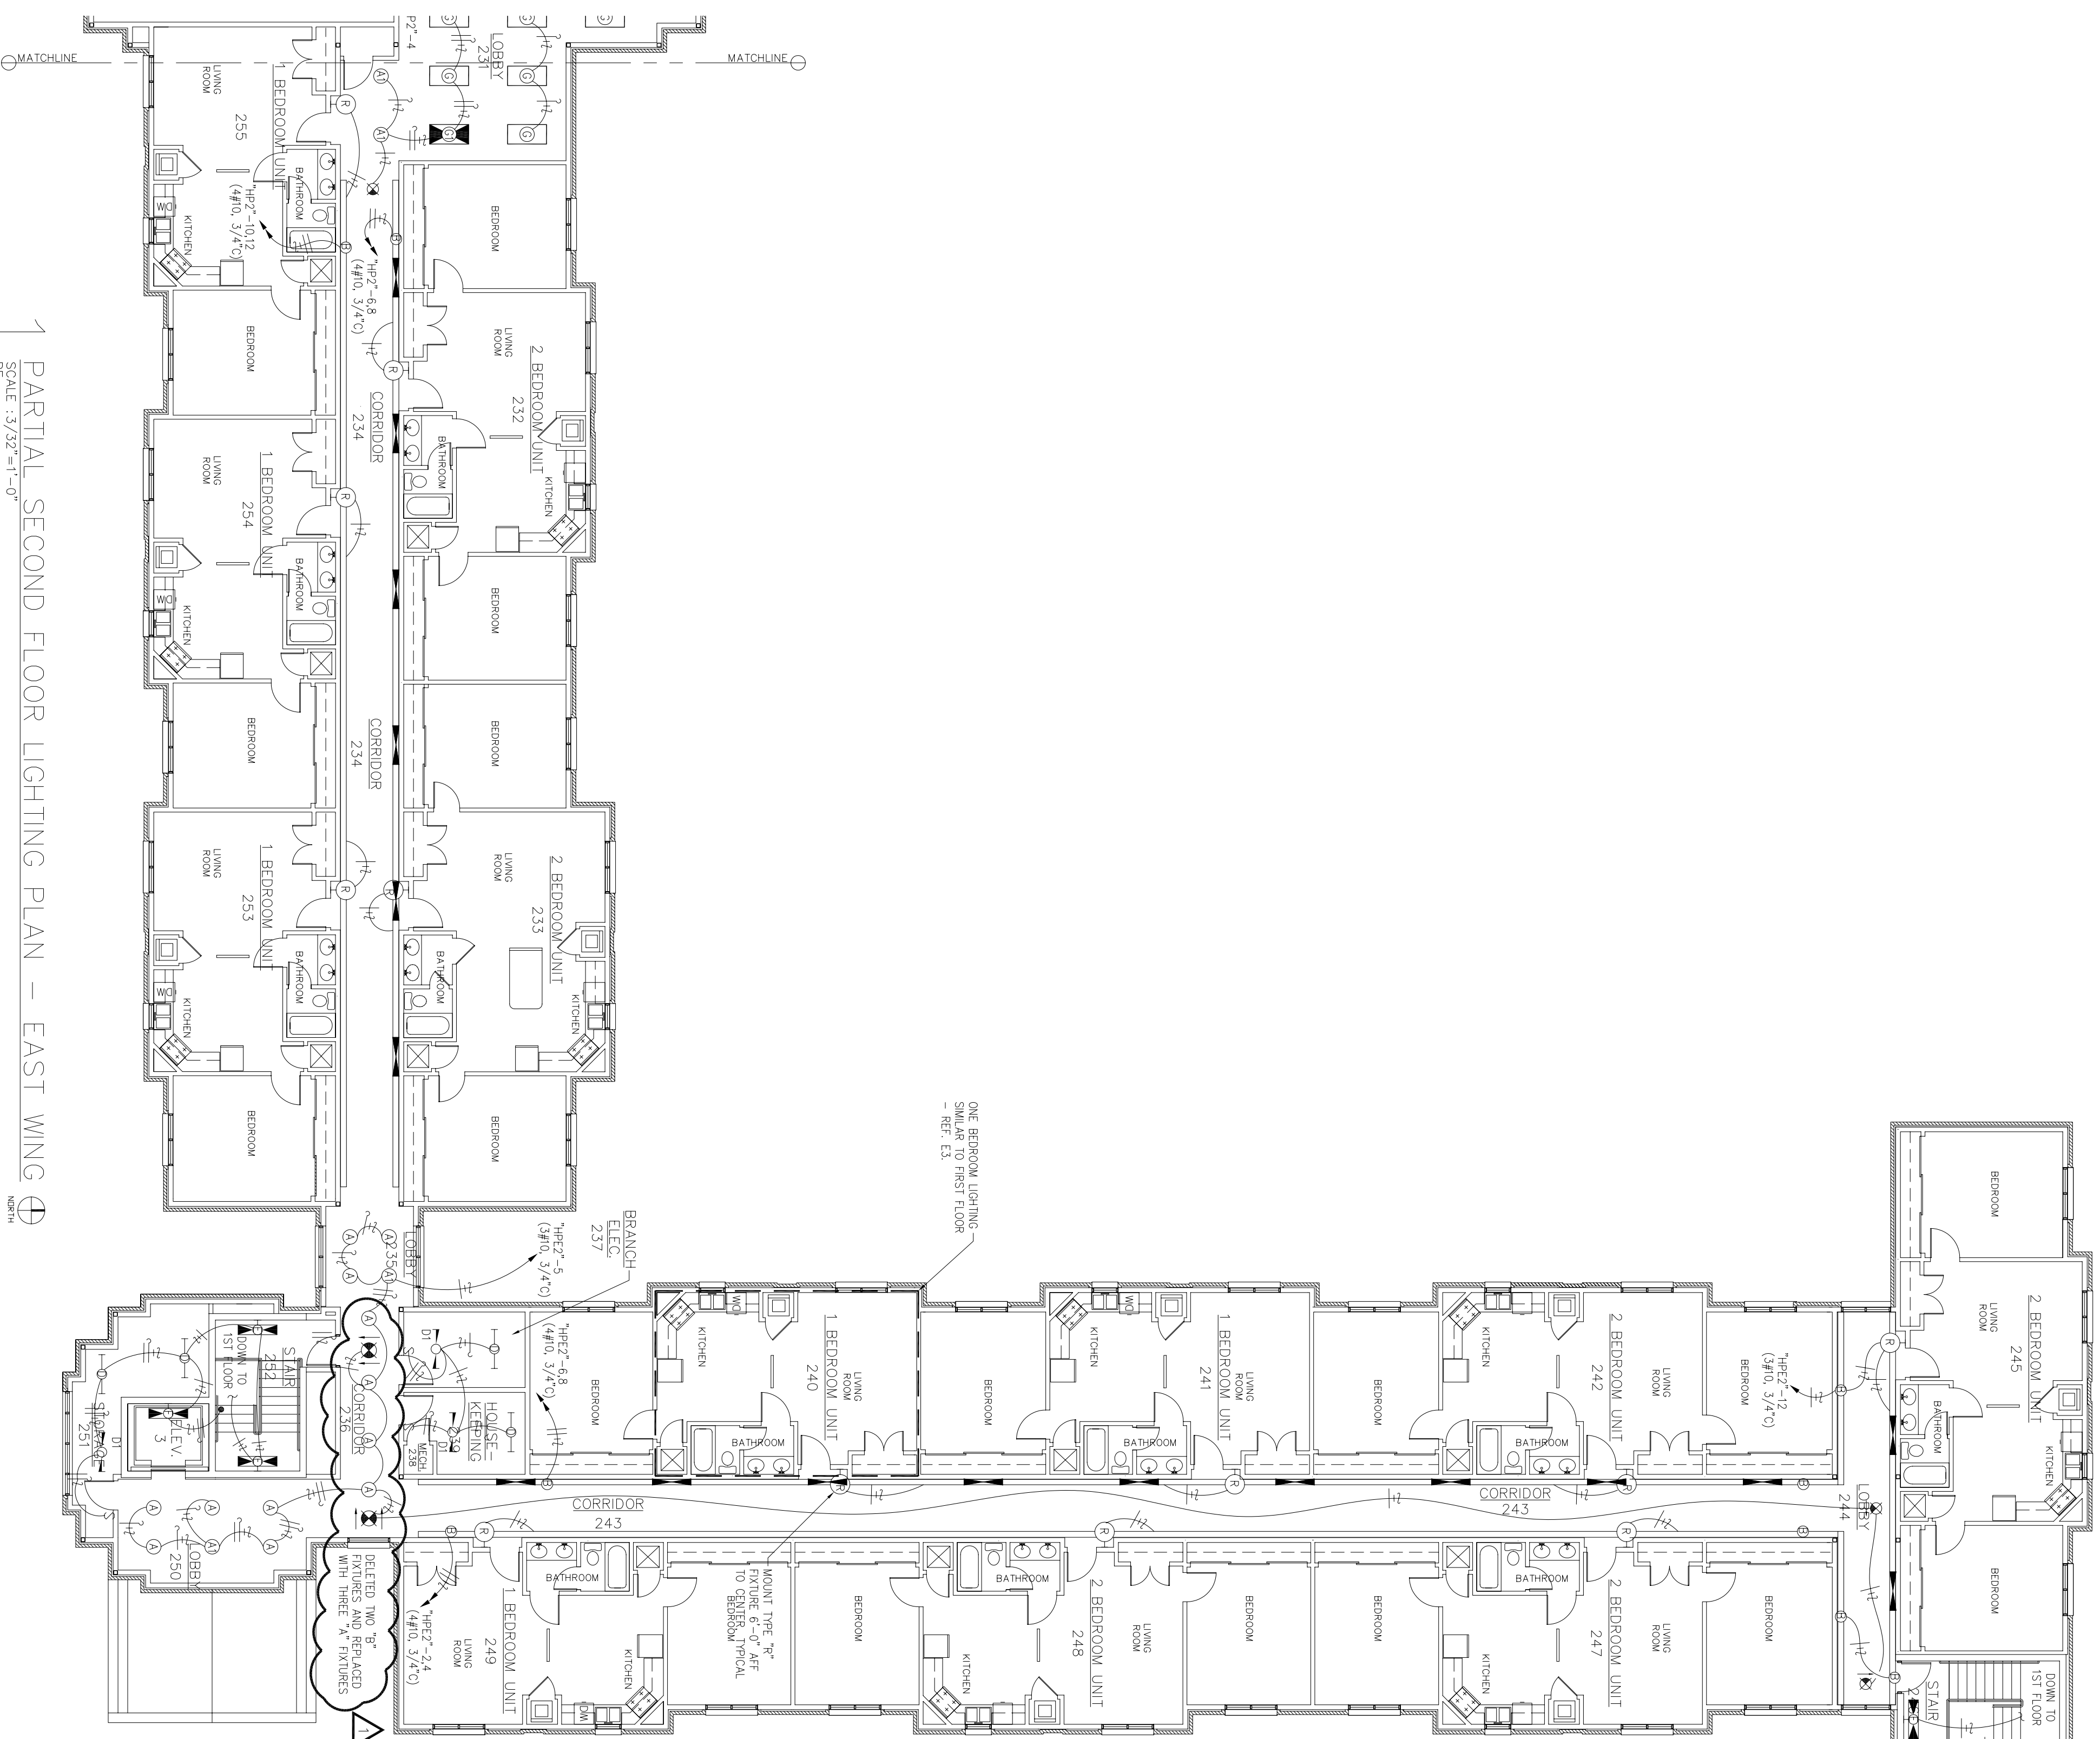

1 PARTIAL SECOND FLOOR LIGHTING PLAN - EAST WING  
SCALE: 3/32"=1'-0"  
RE: 1

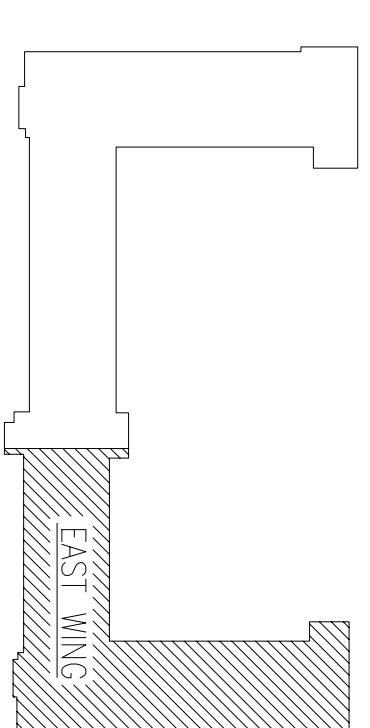

OWNER	CHIEF ENGINEER
CHIEF OF OPERATIONS	BIO ENVIRONMENTAL ENG.
FIRE CHIEF	SAFETY
PROGRAM MANAGER	USING AGENCY

No.	Revision/Issue	Date	BY	APP'D
1	Deleted 'B' fixtures and replaced with three 'A' fixtures			

PROJECT TITLE  
**TEMPORARY LODGING FACILITY**

SHEET TITLE  
**PARTIAL SECOND FLOOR LIGHTING PLAN AS-BUILT**

DRAWN BY KRD	LEAD DESIGNER BRM
TECH. CHECKER BTM	FILE LOCATION
DESIGNED BY BTM	PROJECT NUMBER NKAJK02-5001
DATE 28 MAY 2002	SHEET E7
SCALE AS NOTED	98 of 108