
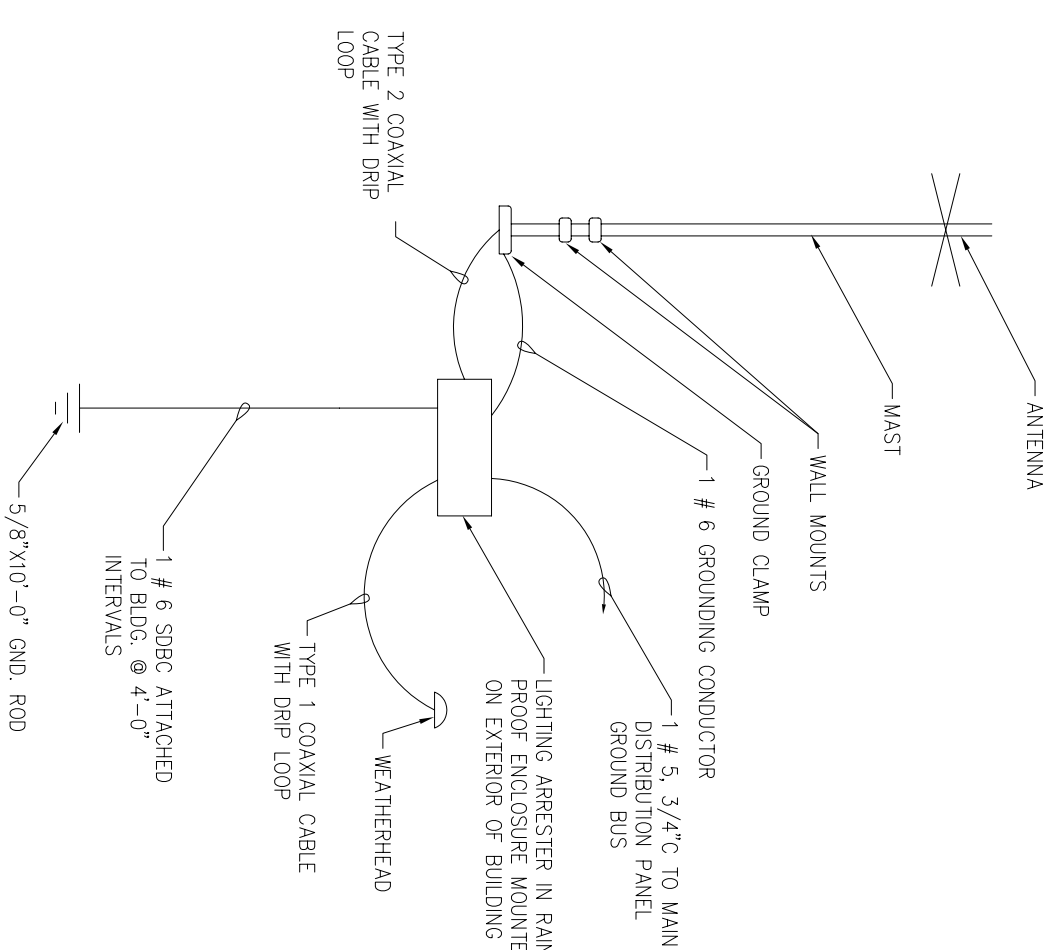
 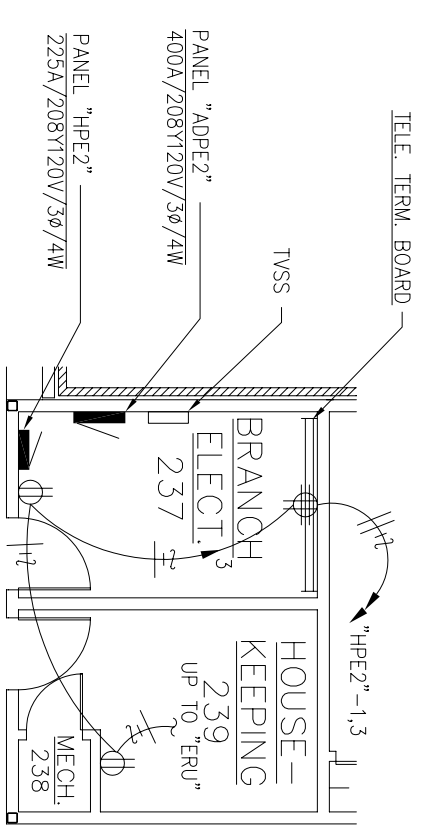
 
 




4 SECOND FLOOR PARTIAL PLAN - ELECTRICAL

SECOND FLOOR PARTIAL PLAN - ELECTRICAL

SCALE : 1/8"=1'-0"

NORTH

6 MONACO ANTENNA MOUNTING DETAIL
SCALE : NONE

7 EXTERIOR LIGHTING CONTROL DIAGRAM
SCALE : NONE

CIVIL ENGINEER	CHEF ENGINEER
CHIEF OF OPERATIONS	BIO ENVIRONMENTAL ENG.
FIRE CHIEF	SAFETY
PROGS&M MANAGER	USING AGENCY

2	10' Ground Triangle U.G. 4/O# CU.			
1	Overhead Door Circuit added HP1 - 36, 38, & 40			
No.	Revision/Issue	Date	BY	APP'D

DRAWN BY	LEAD DESIGNER
KRD	BRM
TECH REVIEWER	FILE LOCATION
DESIGNED BY	PROJECT NUMBER
BTM	NKA002-5001
DATE	SHEET
28 MAY 2002	101 OF 108
SCALE	
AS NOTED	

SHEET TITLE

PARTIAL FLOOR
PLANS - ELECTRICAL
AND EXTERIOR
LIGHTING CONTROL
DIAGRAM

TEMPORARY LODGING FACILITY AS-BUILT

PROJECT TITLE