



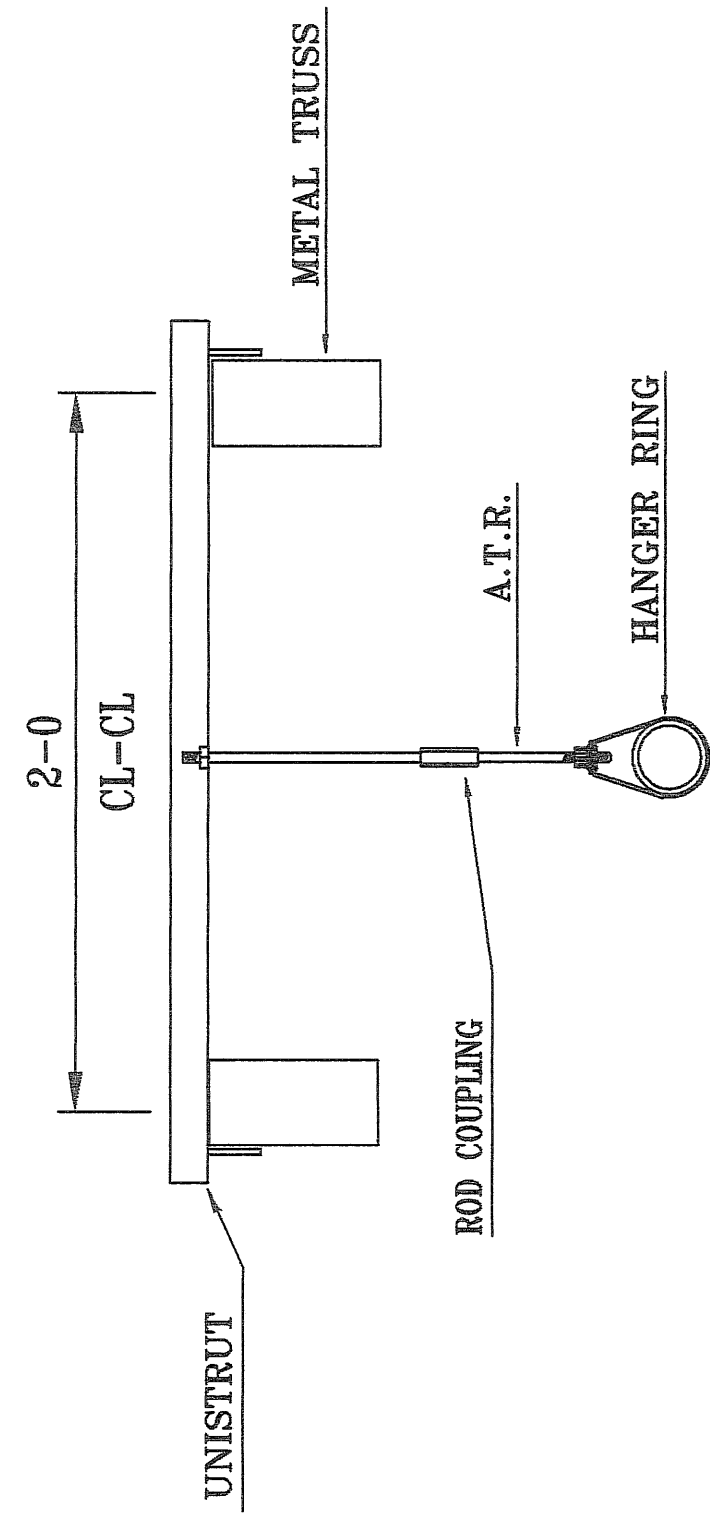

HANGER NO. 04
SAMMY SCREW

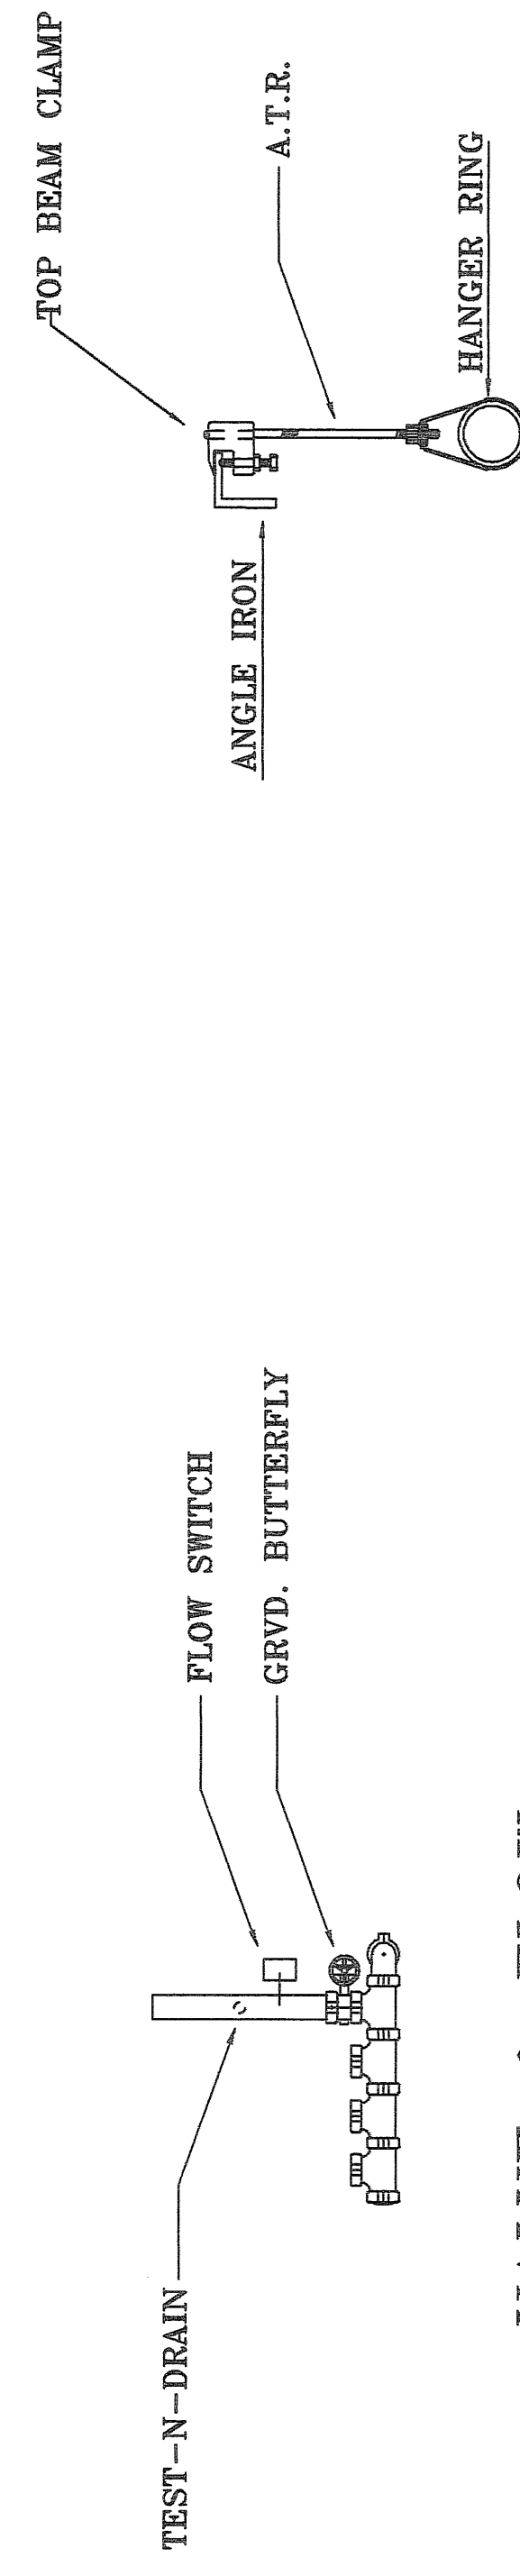


ABBREVIATIONS AND SYMBOLS

TOS – TOP OF STEEL
AFF – ABOVE FINISHED FLOOR
CL – CENTERLINE OF PIPE
COL – COLUMN LINE
WMA – WATER MOTOR ALARM
FDC – FIRE DEPARTMENT CONNECTION
BOC – BACK OF COLUMN
IFW – INSIDE FACE OF WALL
OFW – OUTSIDE FACE OF WALL
IFS – INSIDE FACE OF STUD
CLS – CENTERLINE OF STUD
EOC – EDGE OF CONCRETE

	— WELD TAG
	— BRANCH TAG
	— WATER MOTOR ALARM
	— FIRE DEPT CONNECTION
	— CEILING HEIGHT
	— HYDRAULIC NODE POINT
	— RISE IN PIPE
	— DROP IN PIPE

SYN	CNT	NAME	METAL	TEMP	K	INPT	DEF	WFG	MODEL	ESD	STAT	QVAL
109	PEND	CHROME	CHROME	155	5.60	1/2"	Viding		M-R	Semi-Recessed	VK02	Thread
110	PEND	CHROME	CHROME	155	8.00	3/4"	Viding		M-R	Semi-Recessed	VK02	Thread
1	UPR	BRASS	200	5.60	1/2"	VIKING		M-R			VK300	Thread
7	UPR	BRASS	200	5.60	1/2"	VIKING		M-R			VK300	Thread

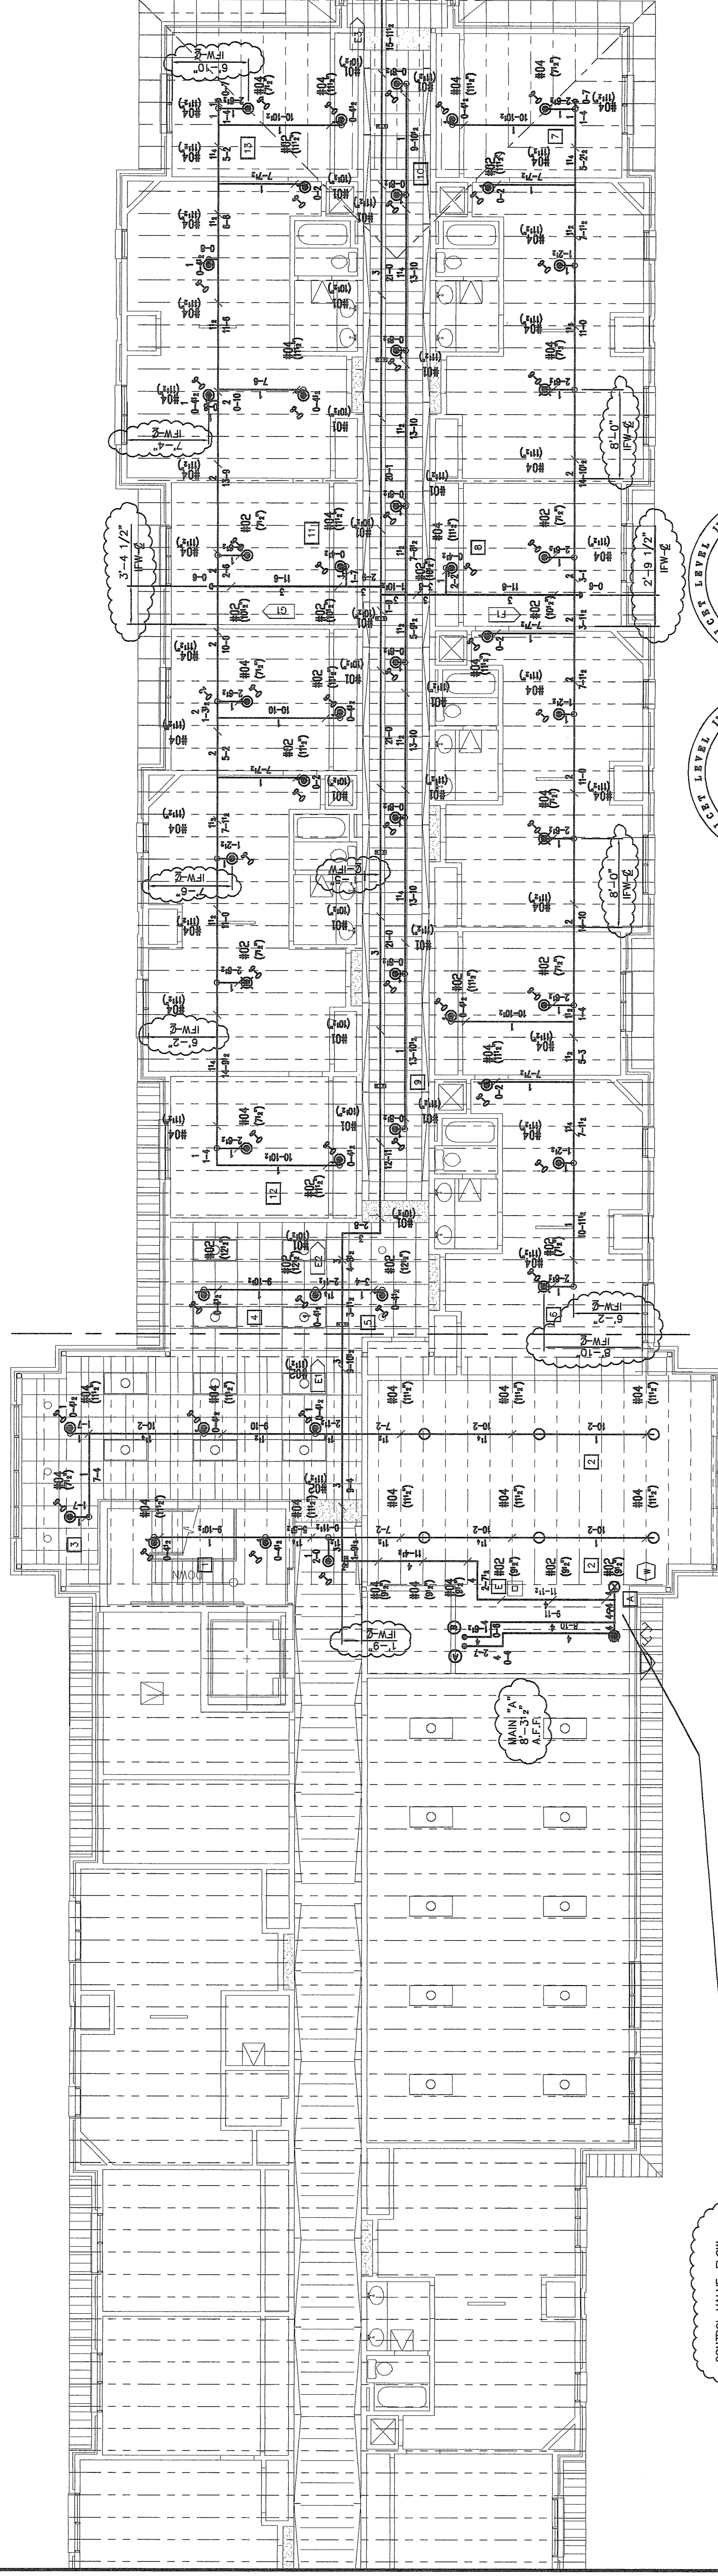

FIRE PROTECTION PLAN
SECOND FLOOR - EAST WING

CONTROL VALVE, FLOW SWITCH, PRESSURE GAUGE AND TEST CONNECTION FOR EACH WING OF EACH FLOOR.

	CONTRACT	ALESSI KEYES
--	-----------------	---------------------

ARKANSAS AUTOMATIC SPRINKLER INC.
P.O. BOX 1370
CABOT, ARKANSAS
72023
(501) 843-9392

PROJECT Little Rock Air Force Base
Temporary Lodging Facility
LRAFB, ARKANSAS

Job No.	02-419	Date:	11-27-02
Drawn By	D. PITTS	Scale	1/8" = 1'
Sheet No.	5 OF 5		