

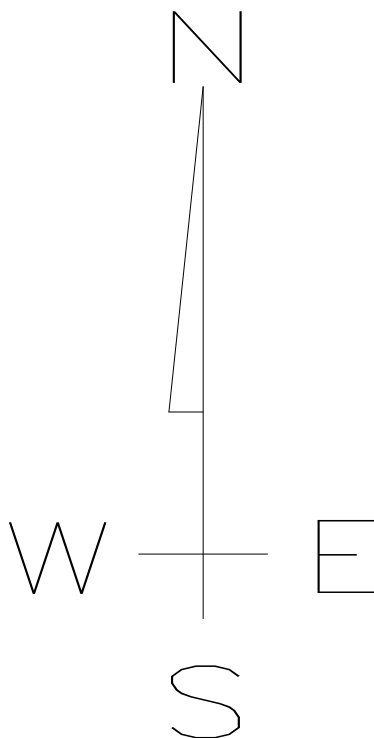
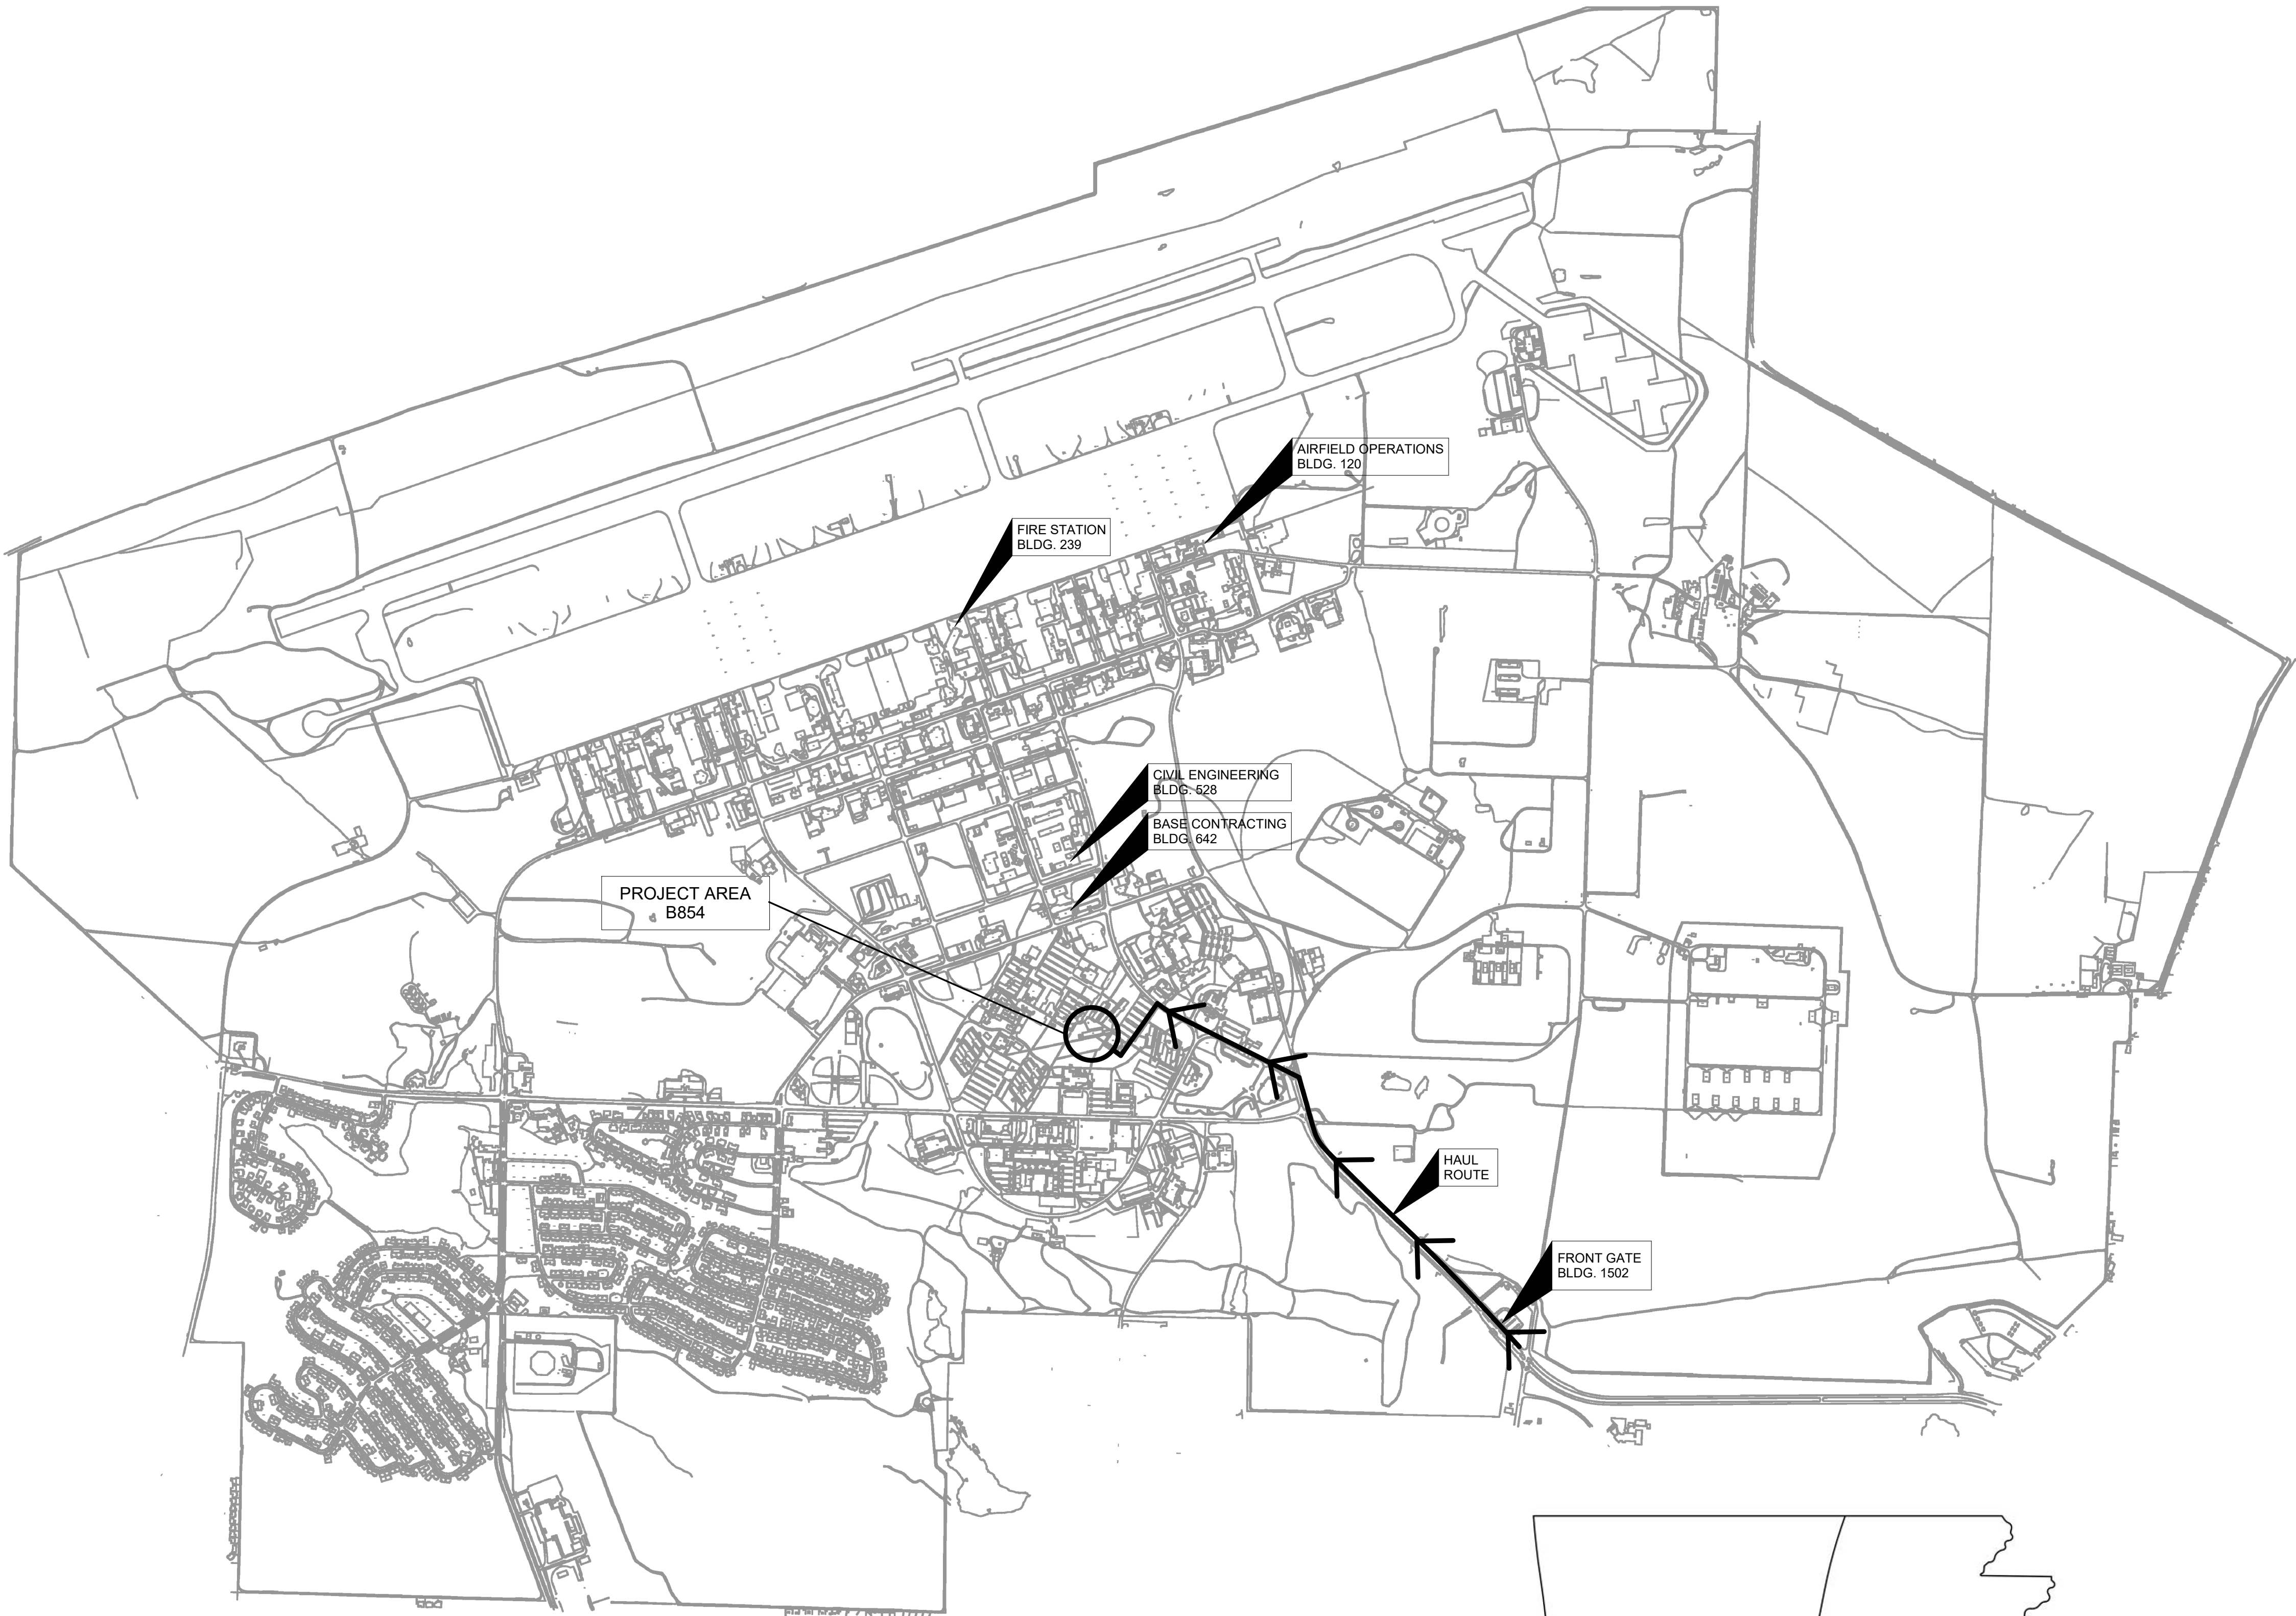


LITTLE ROCK AIR FORCE BASE, ARKANSAS

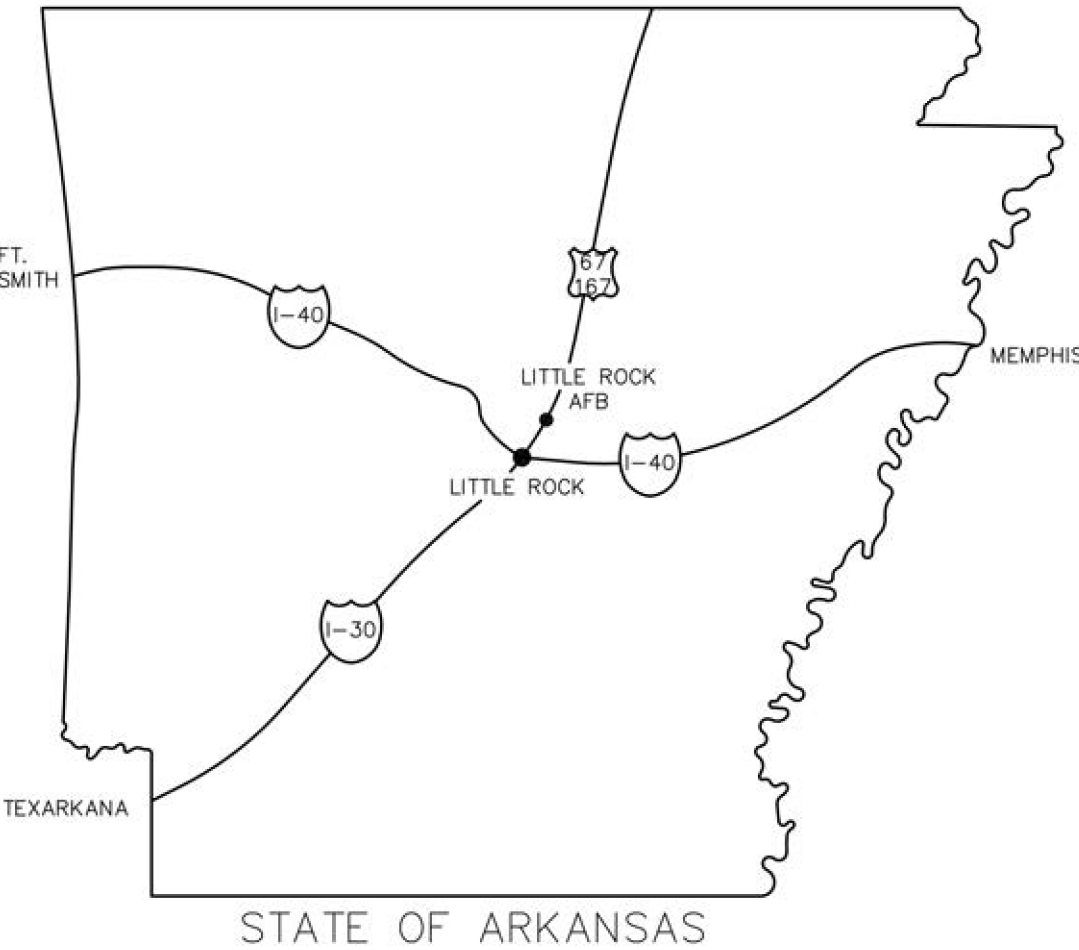

LOCATION PLAN

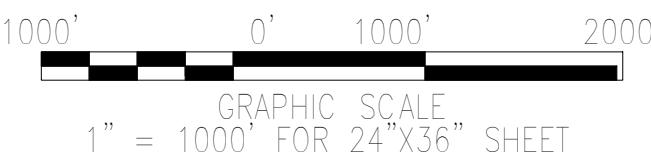

INDEX OF DRAWINGS		
SHEET NO.	LABEL	TITLE
GENERAL		
01	G0.00	LOCATION PLAN, INDEX OF DRAWINGS, AND VICINITY MAP
LIFE SAFETY		
02	LS1.01	LIFE SAFETY - FIRST FLOOR PLAN
03	LS1.02	LIFE SAFETY - SECOND FLOOR PLAN
04	LS1.03	LIFE SAFETY - THIRD FLOOR PLAN
CIVIL		
05	C1.0	EXISTING CONDITIONS
06	C1.1	DEMOLITION PLAN
07	C2.0	CIVIL SITE PLAN
08	C3.0	GRADING PLAN
09	C4.0	EROSION CONTROL PLAN
STRUCTURAL STRENGTHENING		
10	S0.00	GENERAL NOTES
11	S0.01	STRUCTURAL SPECIAL INSPECTIONS
12	S1.01	FOUNDATION PLAN
13	S1.02	SECOND FLOOR FRAMING PLAN
14	S1.03	THIRD FLOOR FRAMING PLAN
15	S1.04	ATTIC FRAMING PLAN
16	S1.05	ROOF FRAMING PLAN
17	S3.01	FOUNDATION DETAILS
18	S4.01	FRAMING DETAILS
19	S4.02	FRAMING DETAILS
STRUCTURAL BALCONY & STAIRS		
20	S1.0	STRUCTURAL NOTES
21	S1.1	FOUNDATION PLAN
22	S2.1	FOUNDATION DETAILS
23	S3.1	2ND FLOOR FRAMING
24	S3.2	3RD FLOOR FRAMING
25	S3.3	ROOF FRAMING
26	S4.1	FRAMING DETAILS
ARCHITECTURAL		
27	AS1.01	ARCHITECTURAL NEW SITE PLAN, NOTES, DETAILS AND SYMBOLS
28	AS1.02	LEGEND
29	AS1.03	ENLARGED STAIR PLANS AND DETAILS
30	AD1.01	ENLARGED PLAN AT RAMP AND SECTIONS
31	AD1.02	FIRST FLOOR DEMOLITION PLAN, NOTES, AND SYMBOLS LEGEND
32	AD1.02	SECOND AND THIRD FLOOR DEMOLITION PLANS AND NOTES
33	A1.01	DEMOLITION BUILDING SECTIONS
34	A1.02	FIRST FLOOR RENOVATION PLAN, ENLARGED STAIR PLANS, AND SYMBOLS LEGEND
35	A1.03	SECOND FLOOR RENOVATION PLAN AND ENLARGED STAIR PLANS
36	A1.04	THIRD FLOOR RENOVATION PLAN AND ENLARGED STAIR PLANS
37	A1.05	FIRST FLOOR REFLECTED CEILING PLAN, DETAIL AND SYMBOLS LEGEND
38	A1.06	SECOND AND THIRD FLOOR REFLECTED CEILING PLANS
39	A1.07	ROOF PLAN AND DETAILS
40	A2.01	ROOF DETAILS
41	A2.02	EXTERIOR ELEVATIONS AND NOTES
42	A3.01	EXTERIOR ELEVATIONS
43	A3.02	BUILDING SECTIONS
44	A3.03	STAIR TOWER SECTIONS AND INFILL DETAILS
45	A4.01	INTERIOR WALL TYPES
46	A4.02	ENLARGED PLANS
47	A4.03	INTERIOR ELEVATIONS, TOILET ACCESSORY SCHEDULE, AND ADA MOUNTING HEIGHTS
48	A5.01	MILLWORK AND INTERIOR DETAILS
49	A6.01	DOOR, FRAME & WINDOW ELEVATIONS, AND SCHEDULES
50	A6.02	DOOR AND WINDOW DETAILS
51	A7.01	FINISH SCHEDULES AND LEGENDS
INTERIORS		
52	IN1.01	FIRST FLOOR FINISH PLAN AND LEGEND
53	IN1.02	SECOND & THIRD FLOOR FINISH PLANS, AND LEGEND
54	IN2.01	FIRST FLOOR SIGNAGE PLAN, SIGN DETAILS AND LEGEND
55	IN2.02	SECOND AND THIRD FLOOR SIGNAGE PLANS
56	IN3.01	FIRST FLOOR FURNITURE PLAN, ENLARGED PLANS AND SCHEDULE - "NOT USED"
57	IN3.02	SECOND AND THIRD FLOOR FURNITURE PLANS - "NOT USED"
FIRE PROTECTION		
58	FA1.00	FIRE ALARM & MNS NOTES
59	FA1.01	FIRE ALARM & MNS - FIRST FLOOR PLAN
60	FA1.02	FIRE ALARM & MNS - SECOND FLOOR PLAN
61	FA1.03	FIRE ALARM & MNS - THIRD FLOOR PLAN
62	FS1.00	FIRE SPRINKLER NOTES AND DETAILS
63	FS1.01	FIRE SPRINKLER - FIRST FLOOR PLAN
64	FS1.02	FIRE SPRINKLER - SECOND FLOOR PLAN
65	FS1.03	FIRE SPRINKLER - THIRD FLOOR PLAN
PLUMBING		
66	P1.01	PLUMBING DEMOLITION PLAN
67	P1.02	PLUMBING DEMOLITION PLAN
68	P2.01	PLUMBING PLAN
69	P2.02	PLUMBING PLAN
70	P3.01	PLUMBING DETAILS
71	P4.01	PLUMBING RISERS
72	P4.02	PLUMBING RISERS
73	P5.01	PLUMBING SCHEDULES
MECHANICAL		
74	M1.01	MECHANICAL DEMOLITION PLAN
75	M1.02	MECHANICAL DEMOLITION PLAN
76	M2.01	MECHANICAL PLAN
77	M2.02	MECHANICAL PLAN
78	M2.03	MECHANICAL PIPING PLAN
79	M2.04	MECHANICAL PIPING PLAN
80	M3.01	MECHANICAL DETAILS
81	M3.02	MECHANICAL DETAILS
82	M3.03	MECHANICAL CONTROLS
83	M4.01	MECHANICAL SCHEDULES
84	M4.02	MECHANICAL SCHEDULES
85	M4.03	MECHANICAL SCHEDULES
ELECTRICAL		
86	EM0.01	ELECTRICAL SITE PLAN
87	E1.01	ELECTRICAL DEMOLITION PLAN
88	E1.02	ELECTRICAL DEMOLITION PLAN
89	E2.01	LIGHTING PLAN
90	E2.02	LIGHTING PLAN
91	E3.01	LIGHTING CALCS PLAN
92	E3.02	LIGHTING CALCS PLAN
93	E3.03	LIGHTING CALCS PLAN - EMERGENCY
94	E3.04	LIGHTING CALCS PLAN - EMERGENCY
95	E4.01	POWER AND SYSTEMS PLAN
96	E4.02	POWER AND SYSTEMS PLAN
97	E5.01	ELECTRICAL ROOF PLAN
98	E6.01	ELECTRICAL DETAILS
99	E7.01	ELECTRICAL SCHEDULES
100	E7.02	ELECTRICAL SCHEDULES



LITTLE ROCK A.F.B.
ARKANSAS



ARCHITECTURE, INC.
507 MAIN STREET
NORTH LITTLE ROCK, ARKANSAS 72114
PHONE: 501-375-3380
WWW.CLEMENTSARCHITECTS.COM

CIVIL ENGINEER				CHIEF ENGINEER			
CHIEF OF OPERATIONS				BIO ENVIRONMENTAL			
FIRE CHIEF				SAFETY			
ENVIRONMENTAL				CONSTRUCTION MANAGER			
PROGRAM MANAGER				USING AGENCY			
							APPD
							BY
							Date
							Revision/Issue
							No.

PROJECT TITLE REPAIR (SUS) AIRMEN DORMITORY BLDG 854		SHEET TITLE LOCATION PLAN, INDEX OF DRAWINGS, AND VICINITY MAP	
DRAWN BY HRS, BD, DR	LEAD DESIGNER C&A	PROJECT NUMBER NKAK 21-1034	SHEET G0.00
DESIGNED BY C&A	DATE 29 FEB, 2024	SCALE AS NOTED	01 OF 100

